
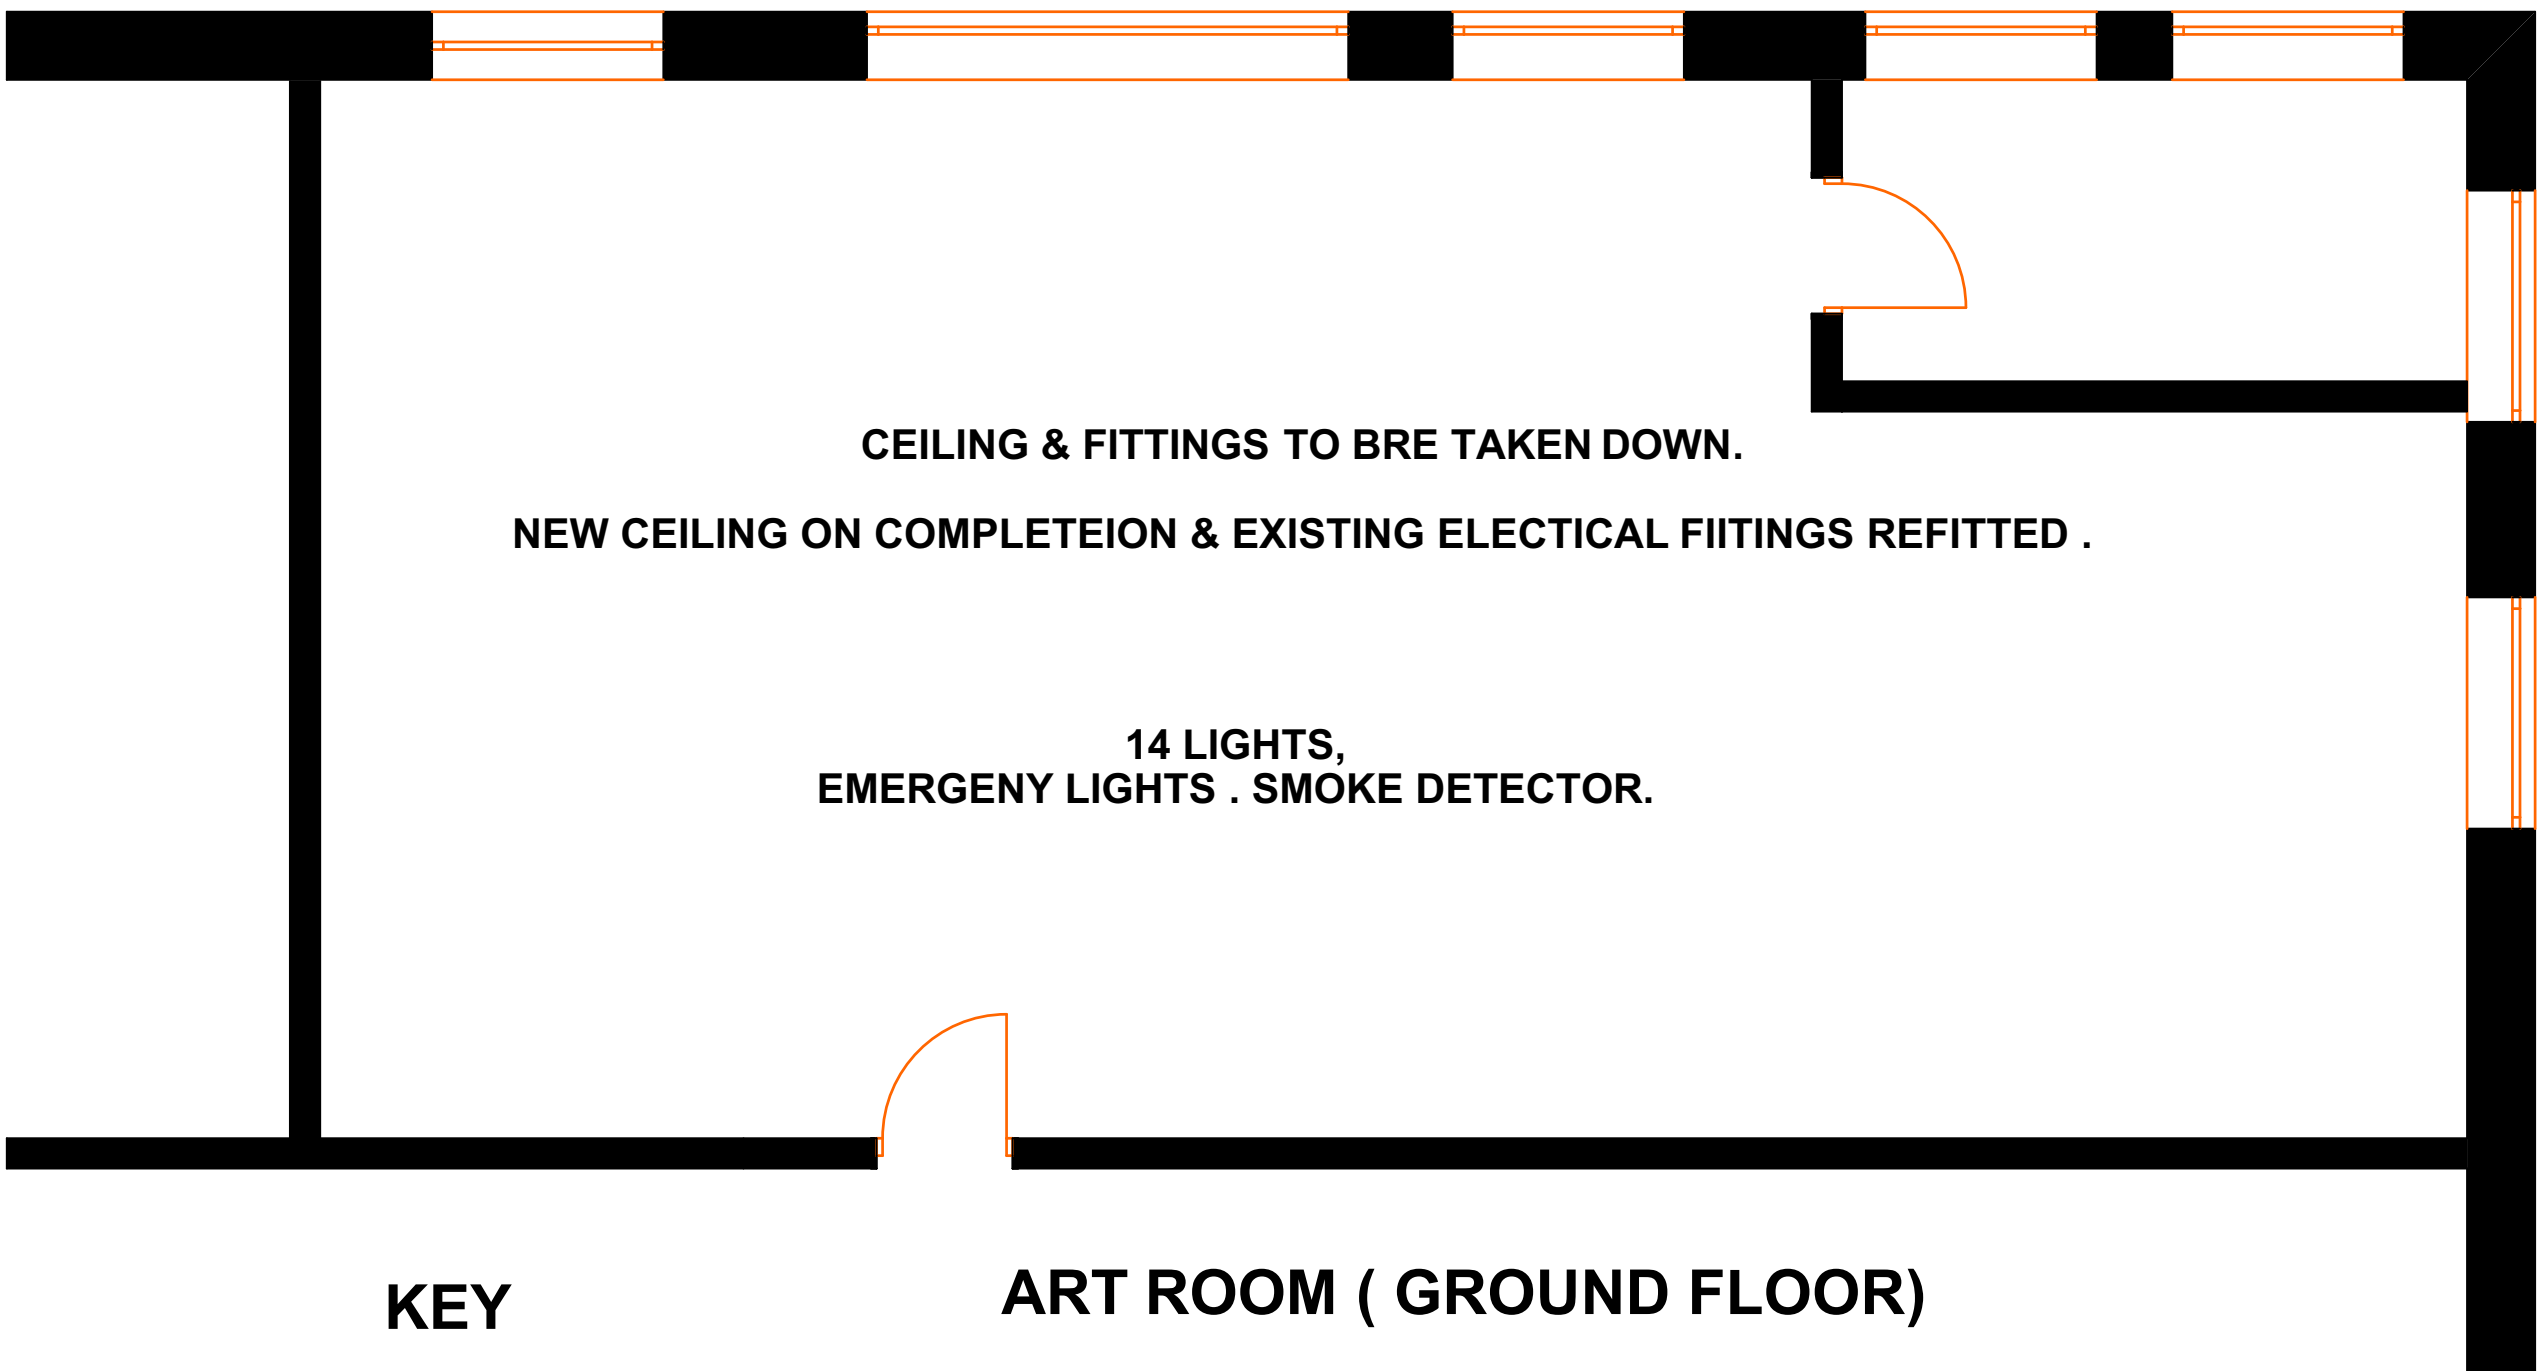


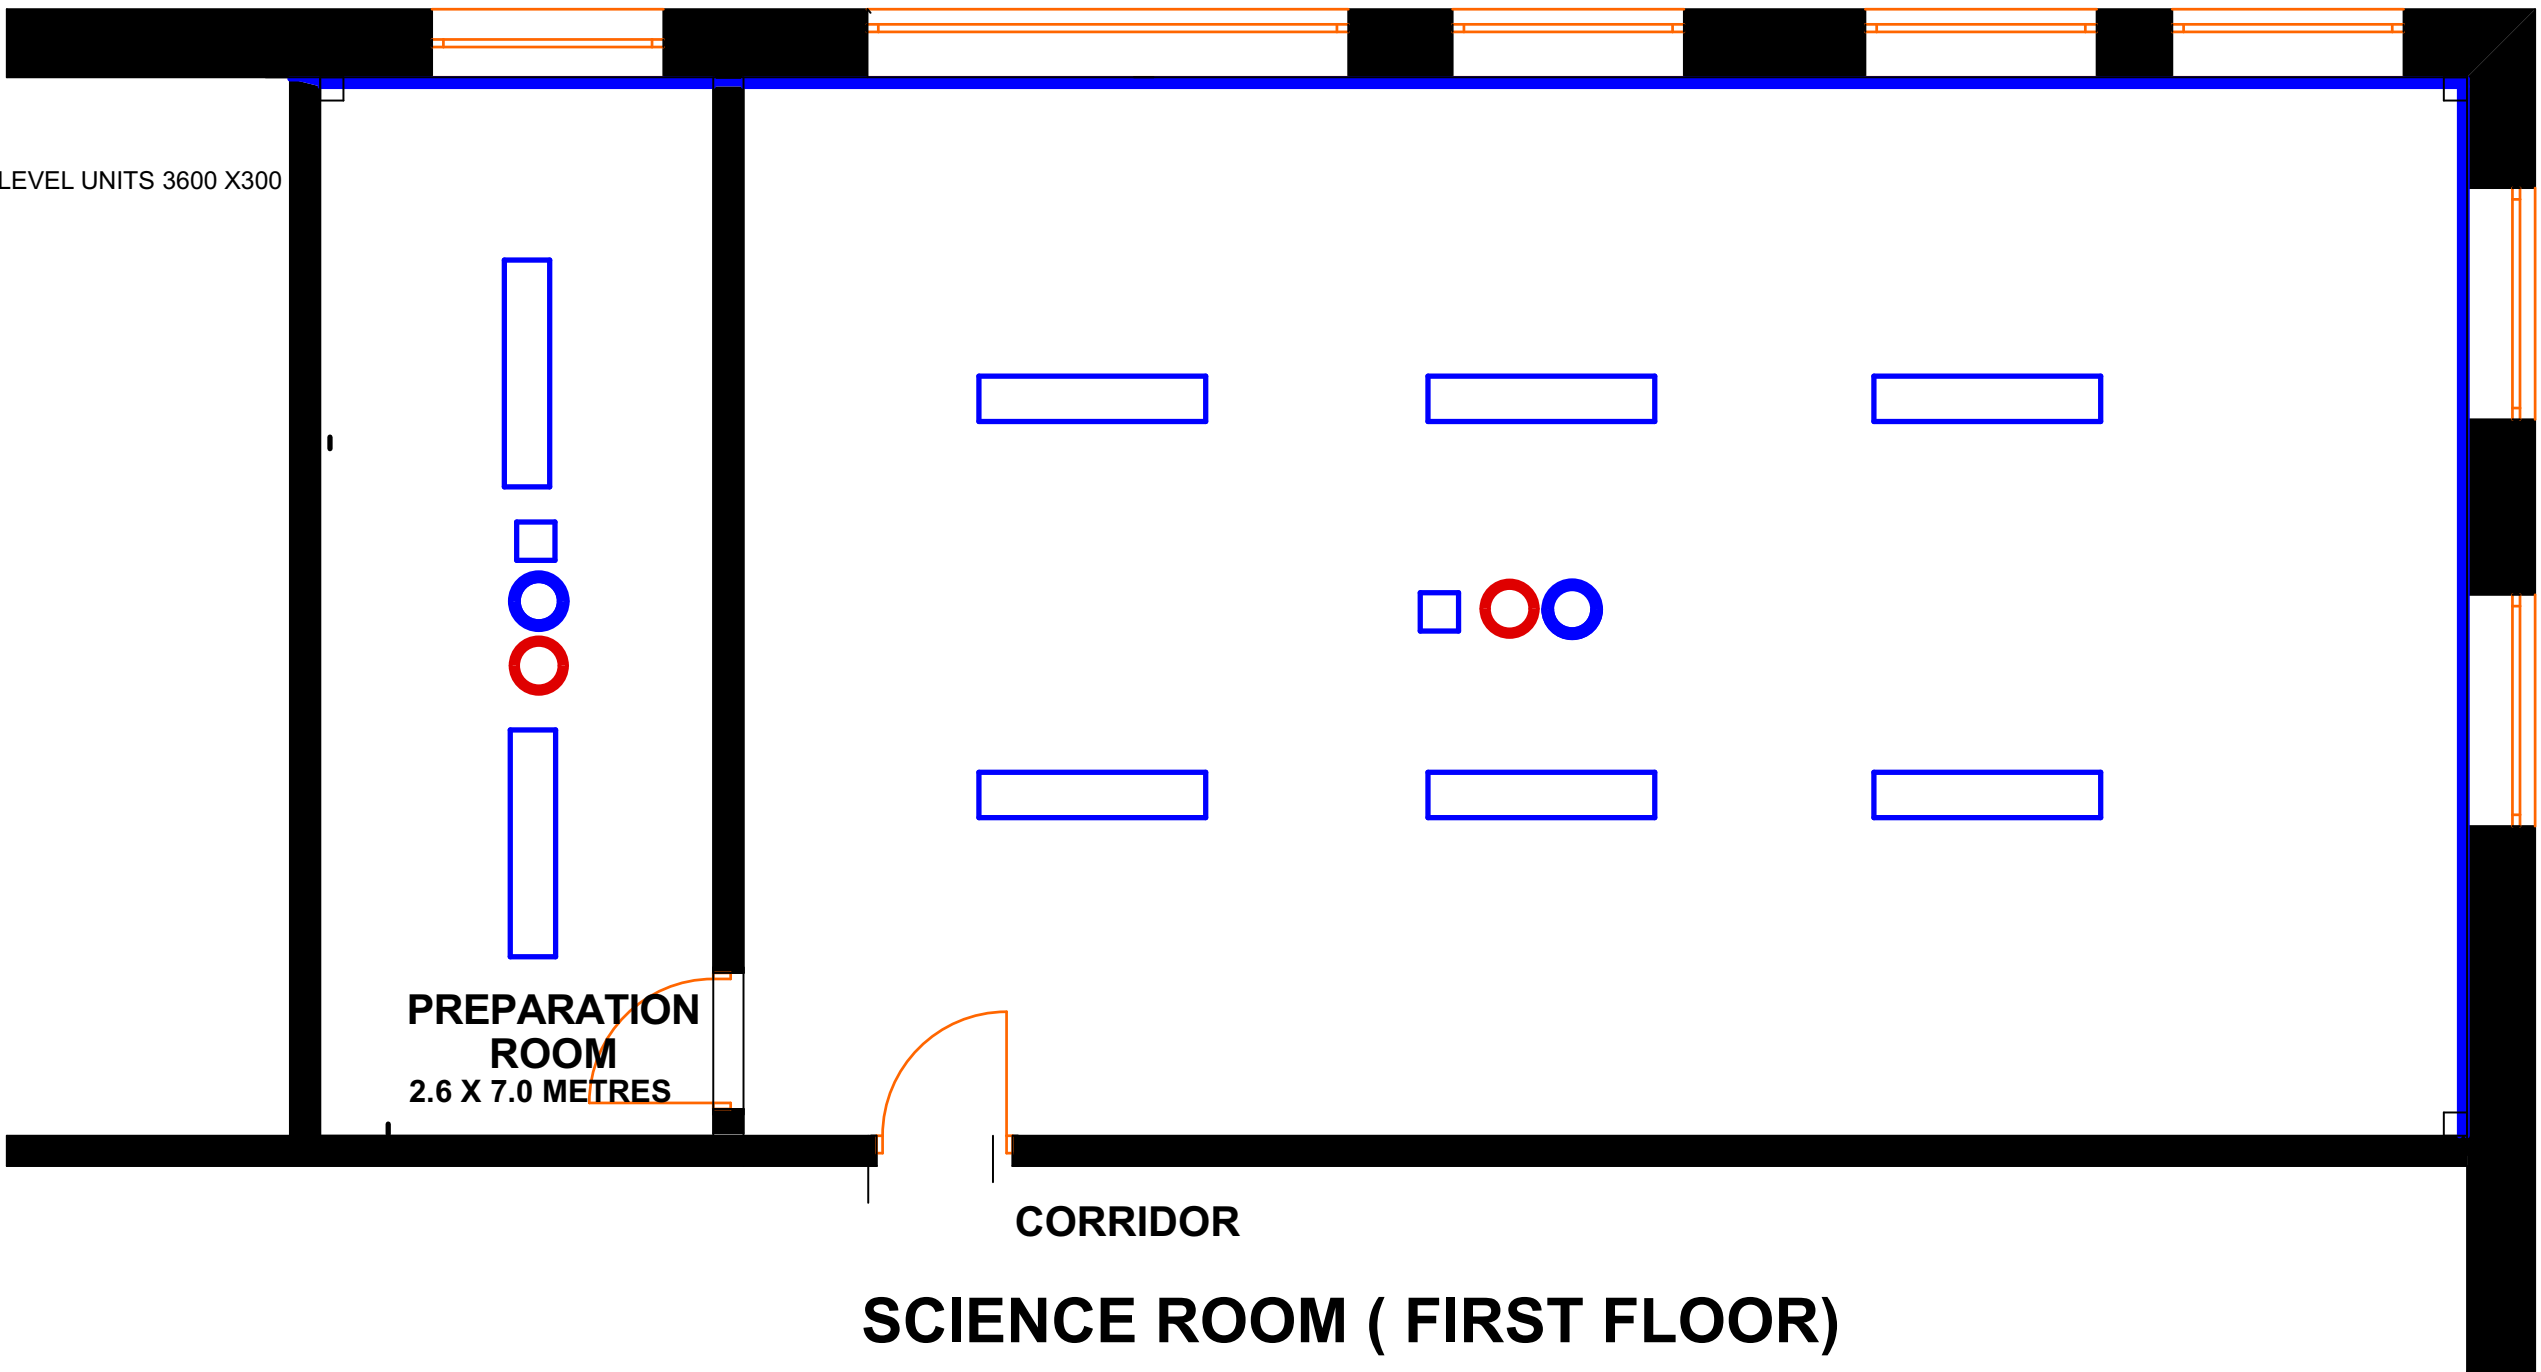

- KEY**
-  EMERGENCY LIGHT
 -  LIGHT FITTING
 -  GAS DETECTOR
 -  CARBON DIOXIDE SENSOR

Drawing 17. Reflected Ceiling Plans. Scale 1:50

ADAMSTOWN COMMUNITY COLLEGE
SCIENCE ROOM & PREPARATION ROOM

P M Ging Architect