



NOTES:

1. THE MAIN /SUB CONTRACTORS TO ALLOW FOR THE RE-MODELING OF THE RECEPTION AREA AND THE STORE AREA AT GROUND FLOOR.
2. THE MAIN CONTRACTOR TO REVIEW ARCHITECTS DRAWINGS AND DEMOLITION WORKS.
3. THE MECHANICAL CONTRACTOR TO ALLOW FOR TRACING ALL SERVICES AND MAKE ALL SERVICES IN THE WORKS AREA SAFE PRIOR TO THE DEMOLITION WORKS STARTING.
4. THE MECHANICAL & ELECTRICAL CONTRACTORS SHALL COORDINATE FINAL POSITION OF ALL EQUIPMENT AND SERVICES WITH ALL OTHER TRADES.
5. THIS DRAWING IS TO BE READ IN CONJUNCTION WITH SPECIFICATION, RELEVANT ARCHITECTS, FIRE AND STRUCTURAL ENGINEERS DRAWINGS. IF IN DOUBT CONTACT ENGINEER.

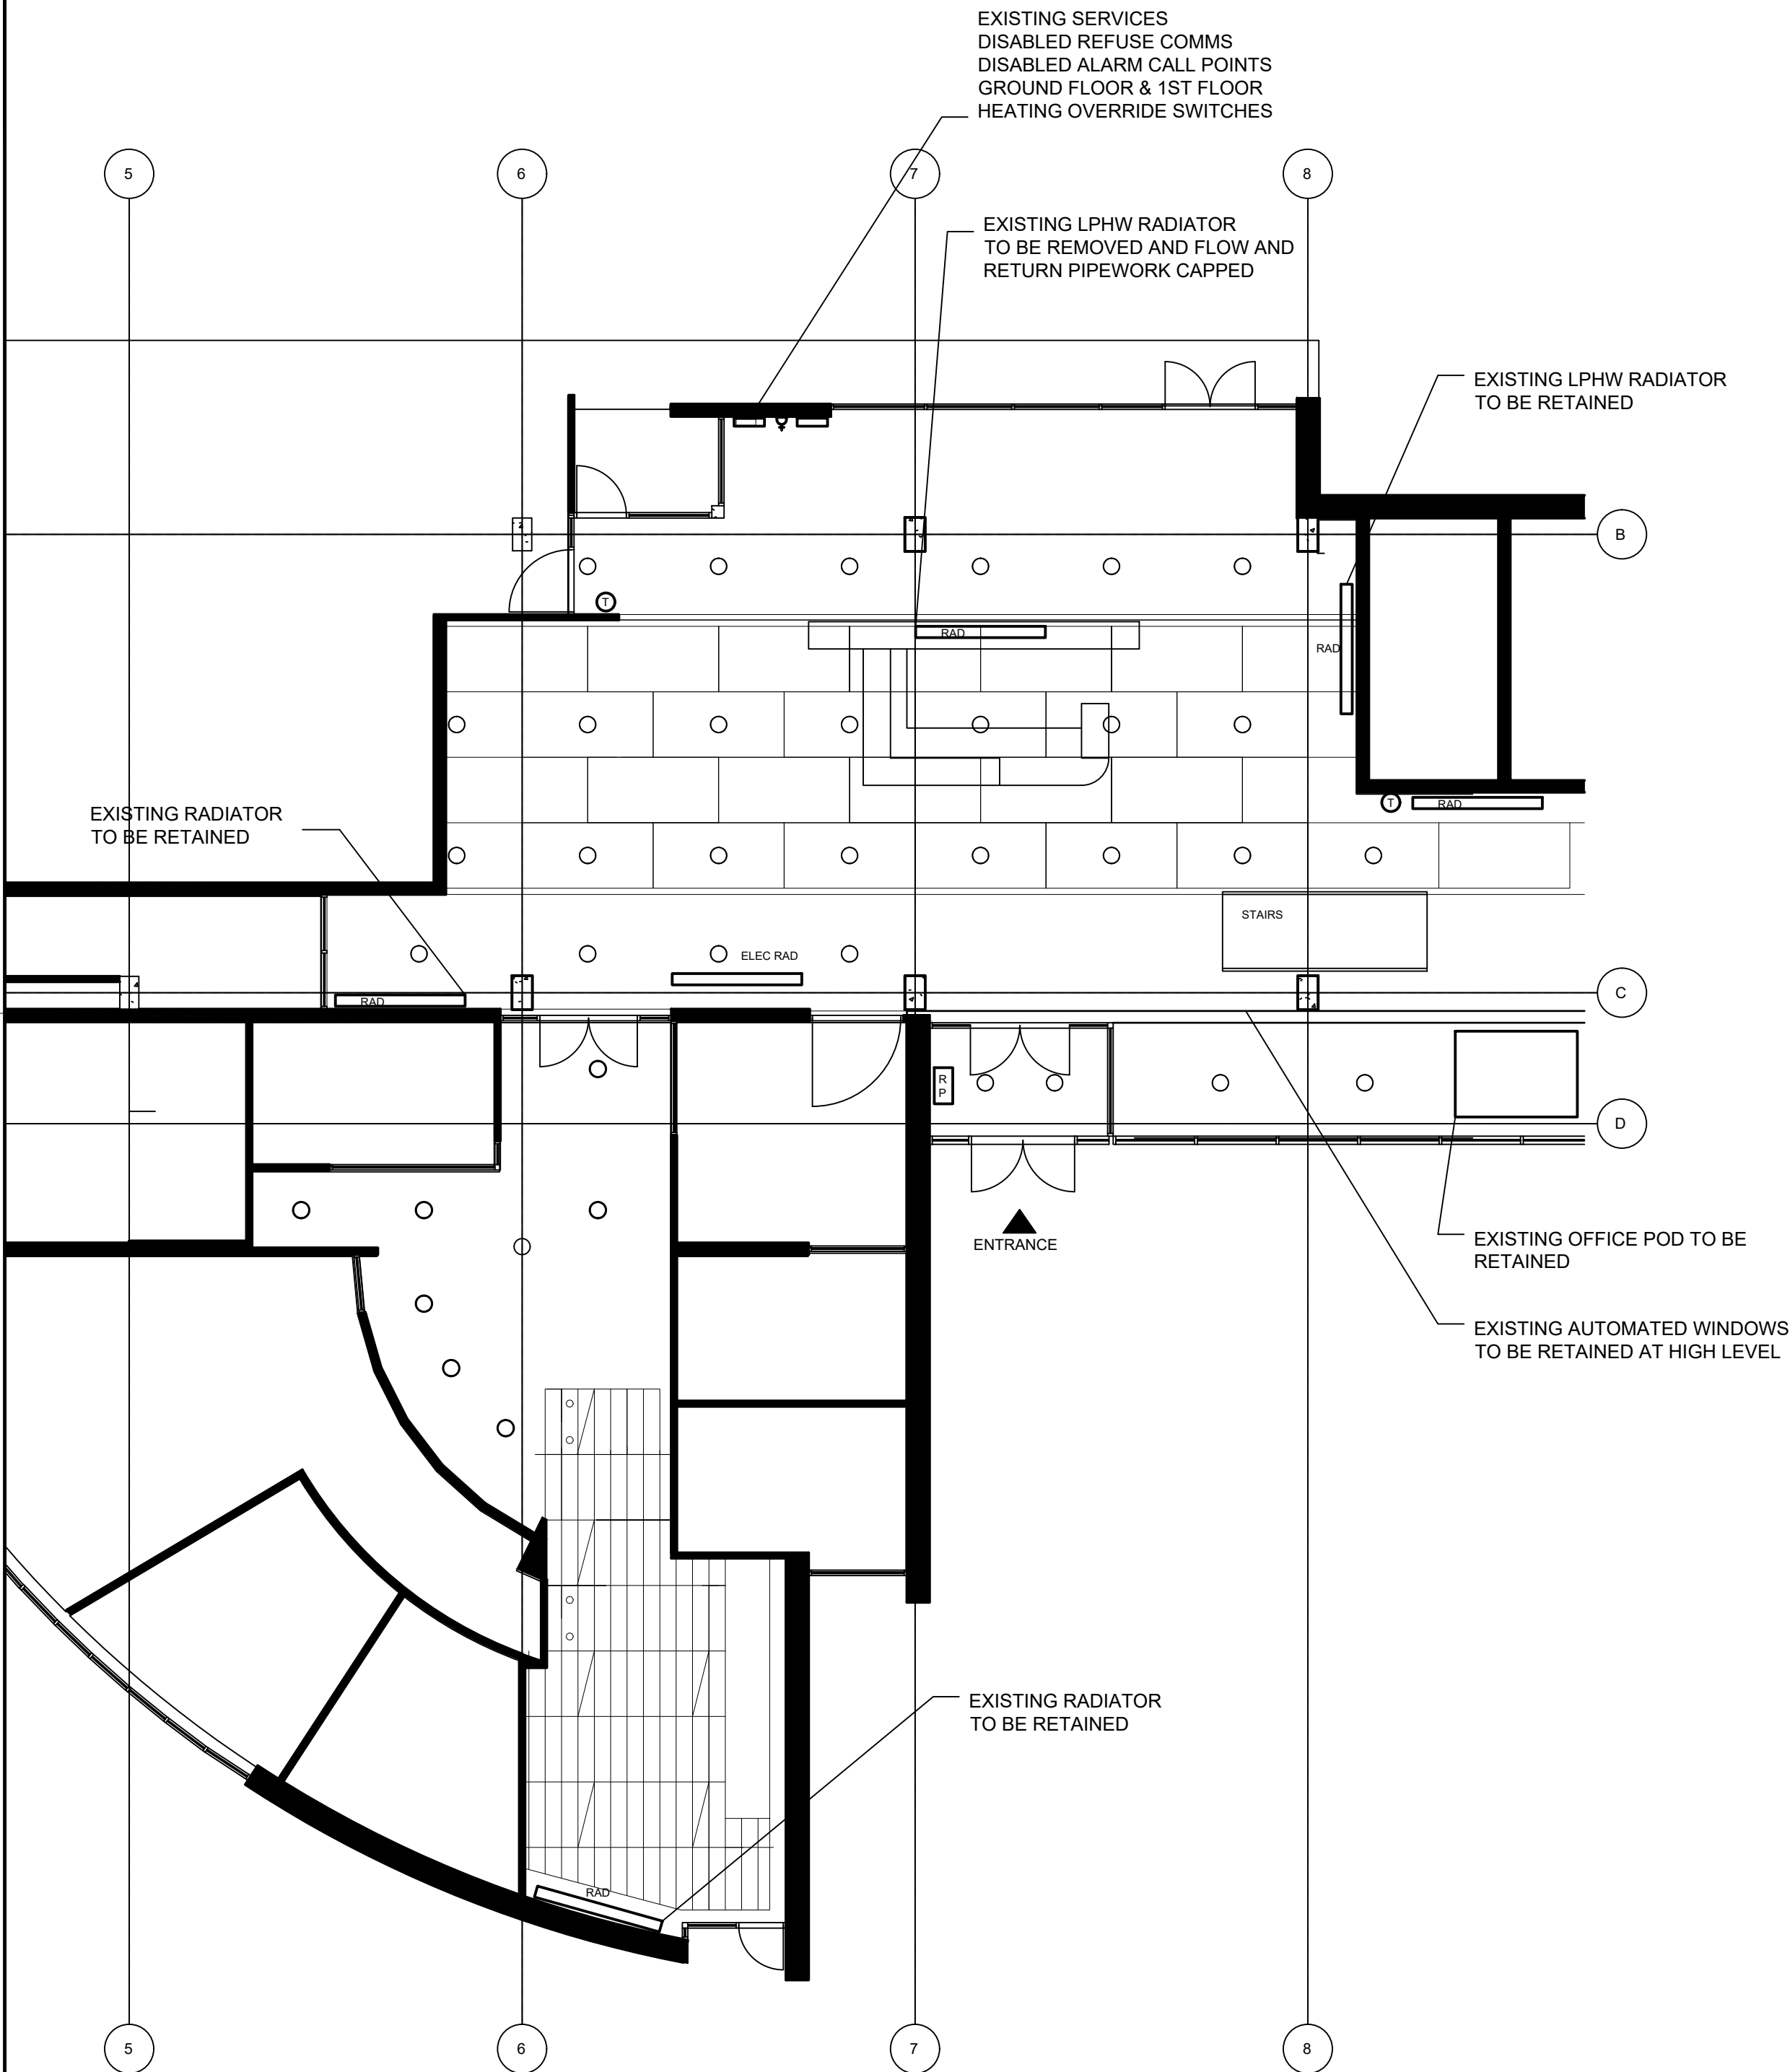

EXISTING FLOOR PLAN

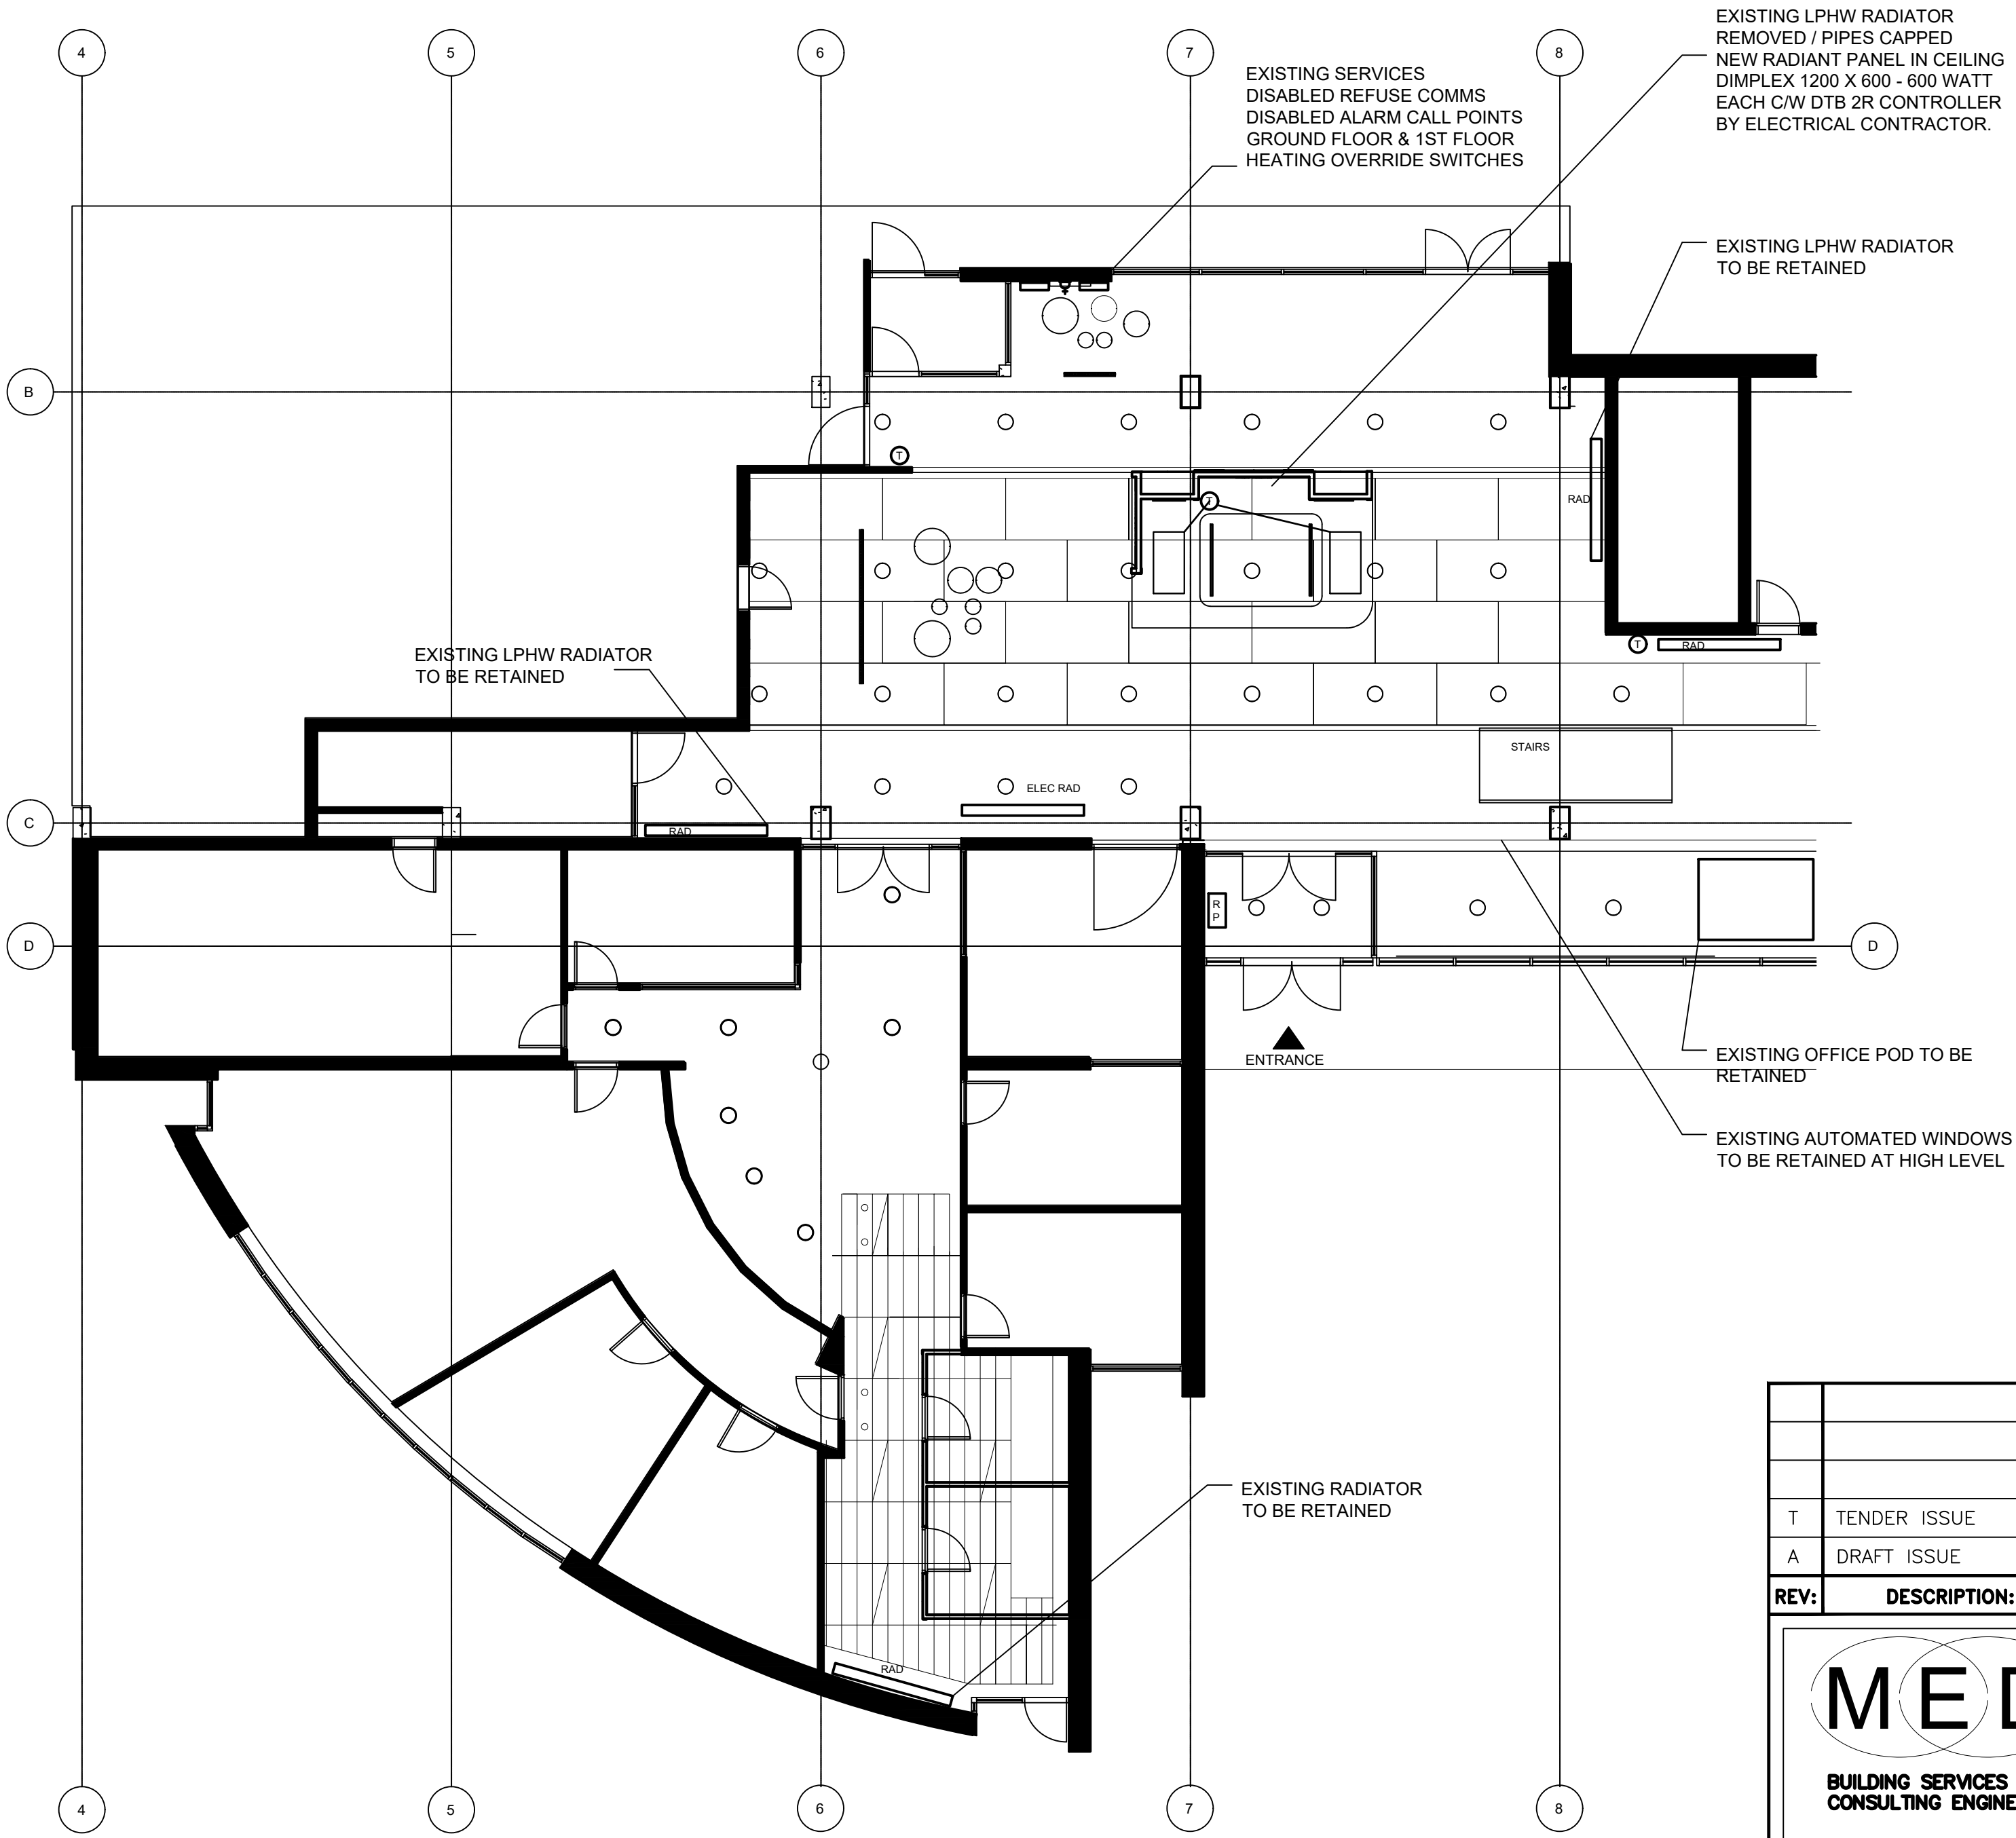

PROPOSED FLOOR PLAN

T	TENDER ISSUE	29/09/25	O.S.	P.S.
A	DRAFT ISSUE	26/09/25	O.S.	P.S.
REV:	DESCRIPTION:	DATE:	BY:	APP:
MED BUILDING SERVICES LIMITED. CONSULTING ENGINEERS Address: Unit 6 Clonsilla Business Centre, Craig Crescent, Clonsilla, Dublin 22 Telephone: 01 457 2025 Facsimile: 01 457 2027 Mobile: 086 3828065 E-mail: info@medservices.ie				
Project: EPA WEXFORD POB 300 JOHNSTOWN, WEXFORD Co, WEXFORD.				
Title: EXISTINNG/PROPOSED MECHANICAL SERVICES TO BE MODIFIED GROUND FLOOR PLAN				
Scale: 1:100 @ A1	Start Date: 16/09/25	Dwg. By: O.Smith	Des. By: P.Spratt	App. By: P.Spratt
Drawing Status: TENDER	Project No: 2509-049	Drawing No: M-100	Rev:	T