


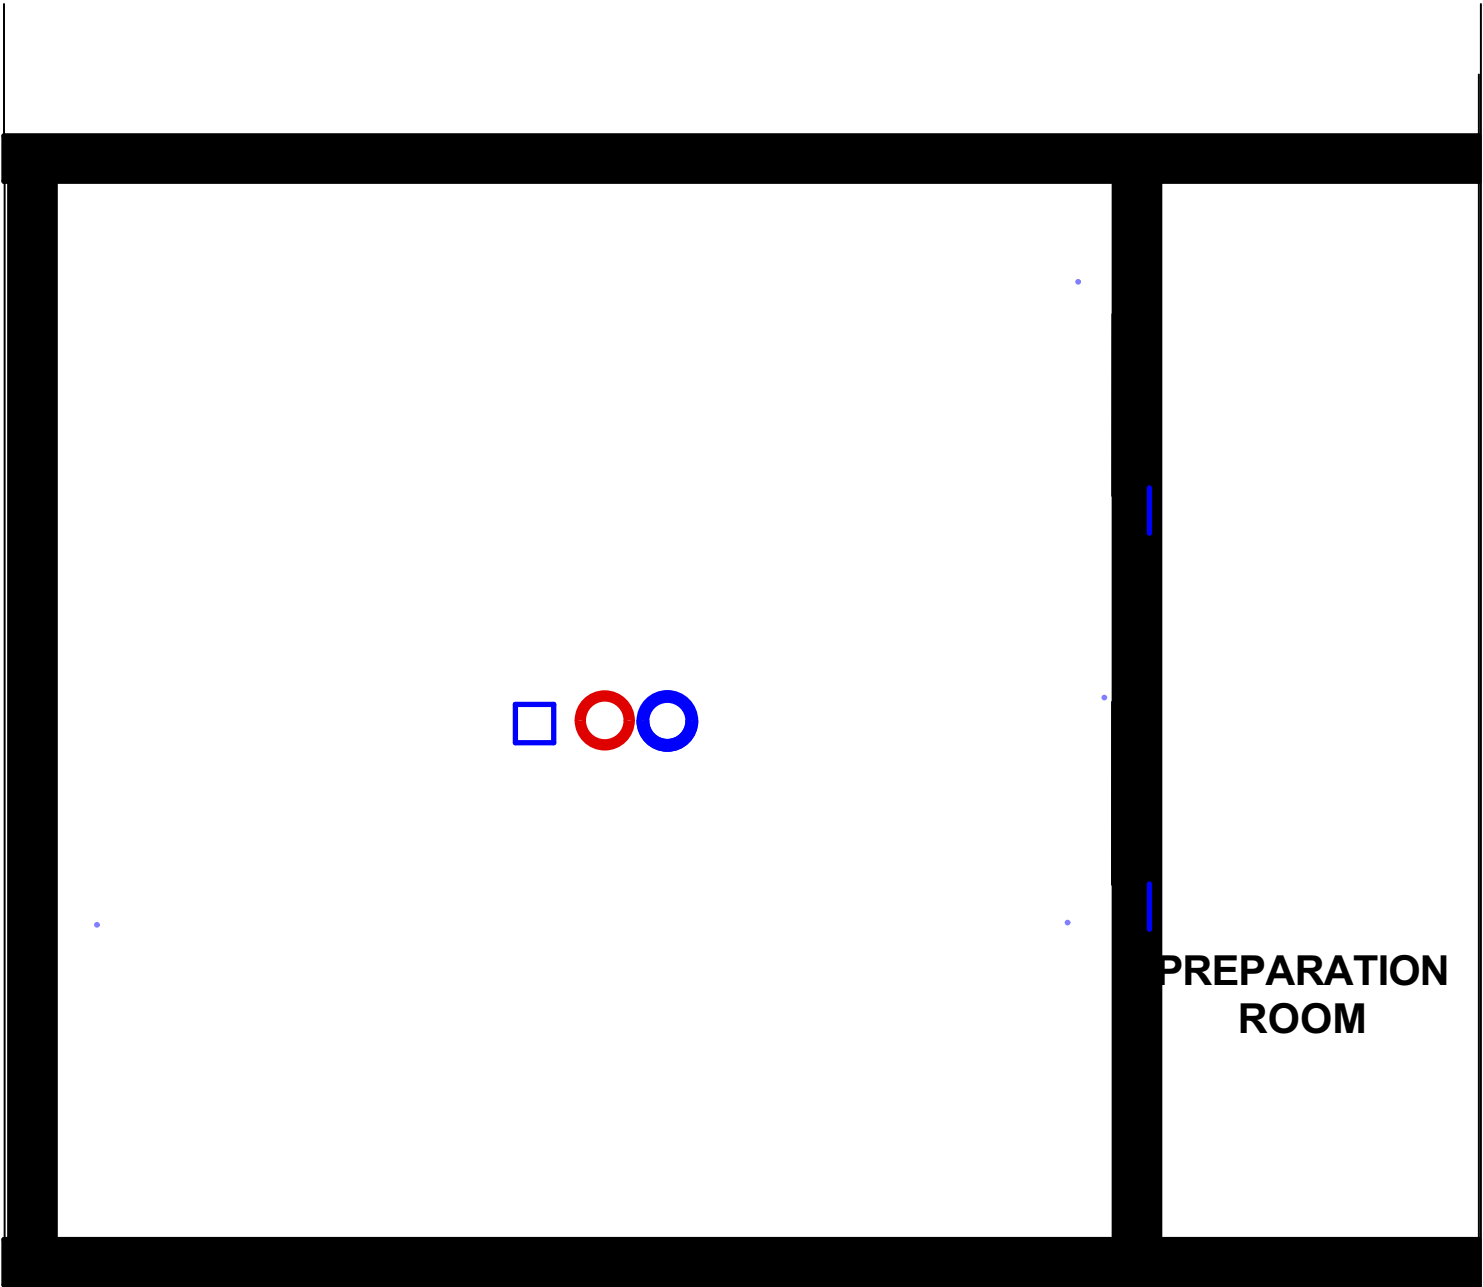

Key

-  GAS DETECTOR
-  CARBON DIOXIDE SENSOR

Drawing 17. Reflected Ceiling Plan.Scale 1:50

SCIENCE ROOM at
FINGAL COMMUNITY COLLEGE

P M Ging Architect