

Planning Drawing

NOTES: USE FIGURED DIMENSIONS ONLY

COPYRIGHT RESERVED. THIS DRAWING IS NOT TO BE USED FOR A PURPOSE OTHER THAN THAT FOR WHICH IT HAS BEEN ISSUED BY GAFFNEY & CULLIVAN ARCHITECTS LTD. NOR IS IT TO BE COPIED OR REPRODUCED, RETAINED OR DISCLOSED EITHER WHOLLY OR IN PART BY OR TO ANY UNAUTHORISED PERSONS WITHOUT WRITTEN CONSENT.


1. ALL DIMENSIONS TO BE CHECKED ON SITE.
2. DO NOT SCALE THIS DRAWING. ONLY FIGURED DIMENSIONS TO BE TAKEN AS ACCURATE.
3. ARCHITECTS TO BE INFORMED IMMEDIATELY OF ANY DISCREPANCIES
4. WORKS BELOW GROUND LEVEL ARE PROVISIONAL ONLY.

Electrical Legend:

- Light Switch
- PRR
- A/O Glamox A35-S
- B/O Glamox A15-S
- C/O Glamox A20-S
- Double Socket
- WH Fan Spur
- FAN Fan Spur
- HD Spur Hand dryer

Spurs - To be allowed for heating pumps and controls
Spurs - To be allowed for Water heating and shower pumps presumably

- W/E 2xCAT 6A Point
BCA Rated
- 32A PS Shower Supply
- Mullan Lighting
Copenhagen Large Scandinavian Dome
Pendant Light 73cm
- DB Distribution Board
- BH Emergency Bulkhead
- EXIT Exit Hanging
- EMO Emergency pin spot
- X1 HARTE Modern L shaped
bollard light 0.8m (T102)
- X2 Mullan Ross Marine Bulkhead
Wall Light Emergency IP65

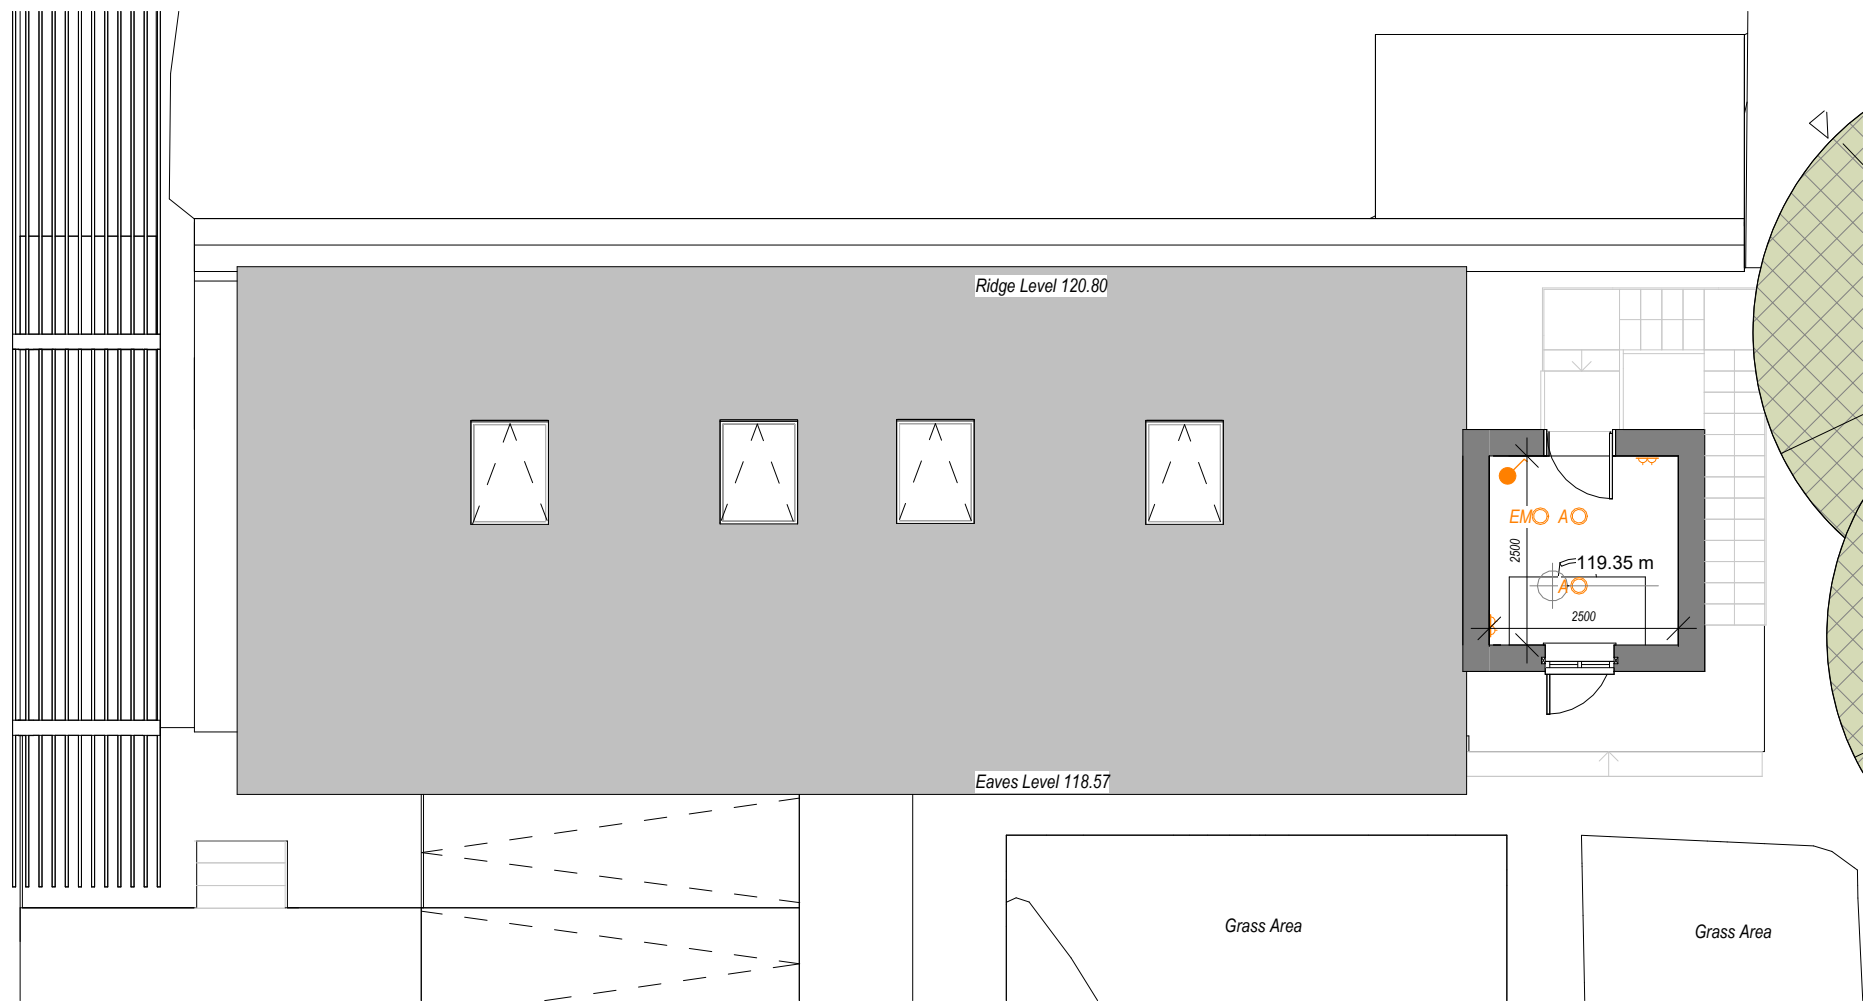

2 FF Electrical Layout
SCALE: 1:100

Rev 01	19/03/2026	Issue for Planning
Rev Nr.	Date	Description
 GCAL GAFFNEY & CULLIVAN ARCHITECTS LTD		
Project Title: Potting Shed Shared Island		
Client: Tyrone Guthrie Centre		
Drawing Title: Proposed Electrical Layout		
Scale: As indicated @ A1	Date: 14/10/25	
Drawn by AF	Designed by DC	Checked by DC
Drawing No: 25-024- TGC- GCAL- 01- 00- DR- A-	006	Rev Rev 01