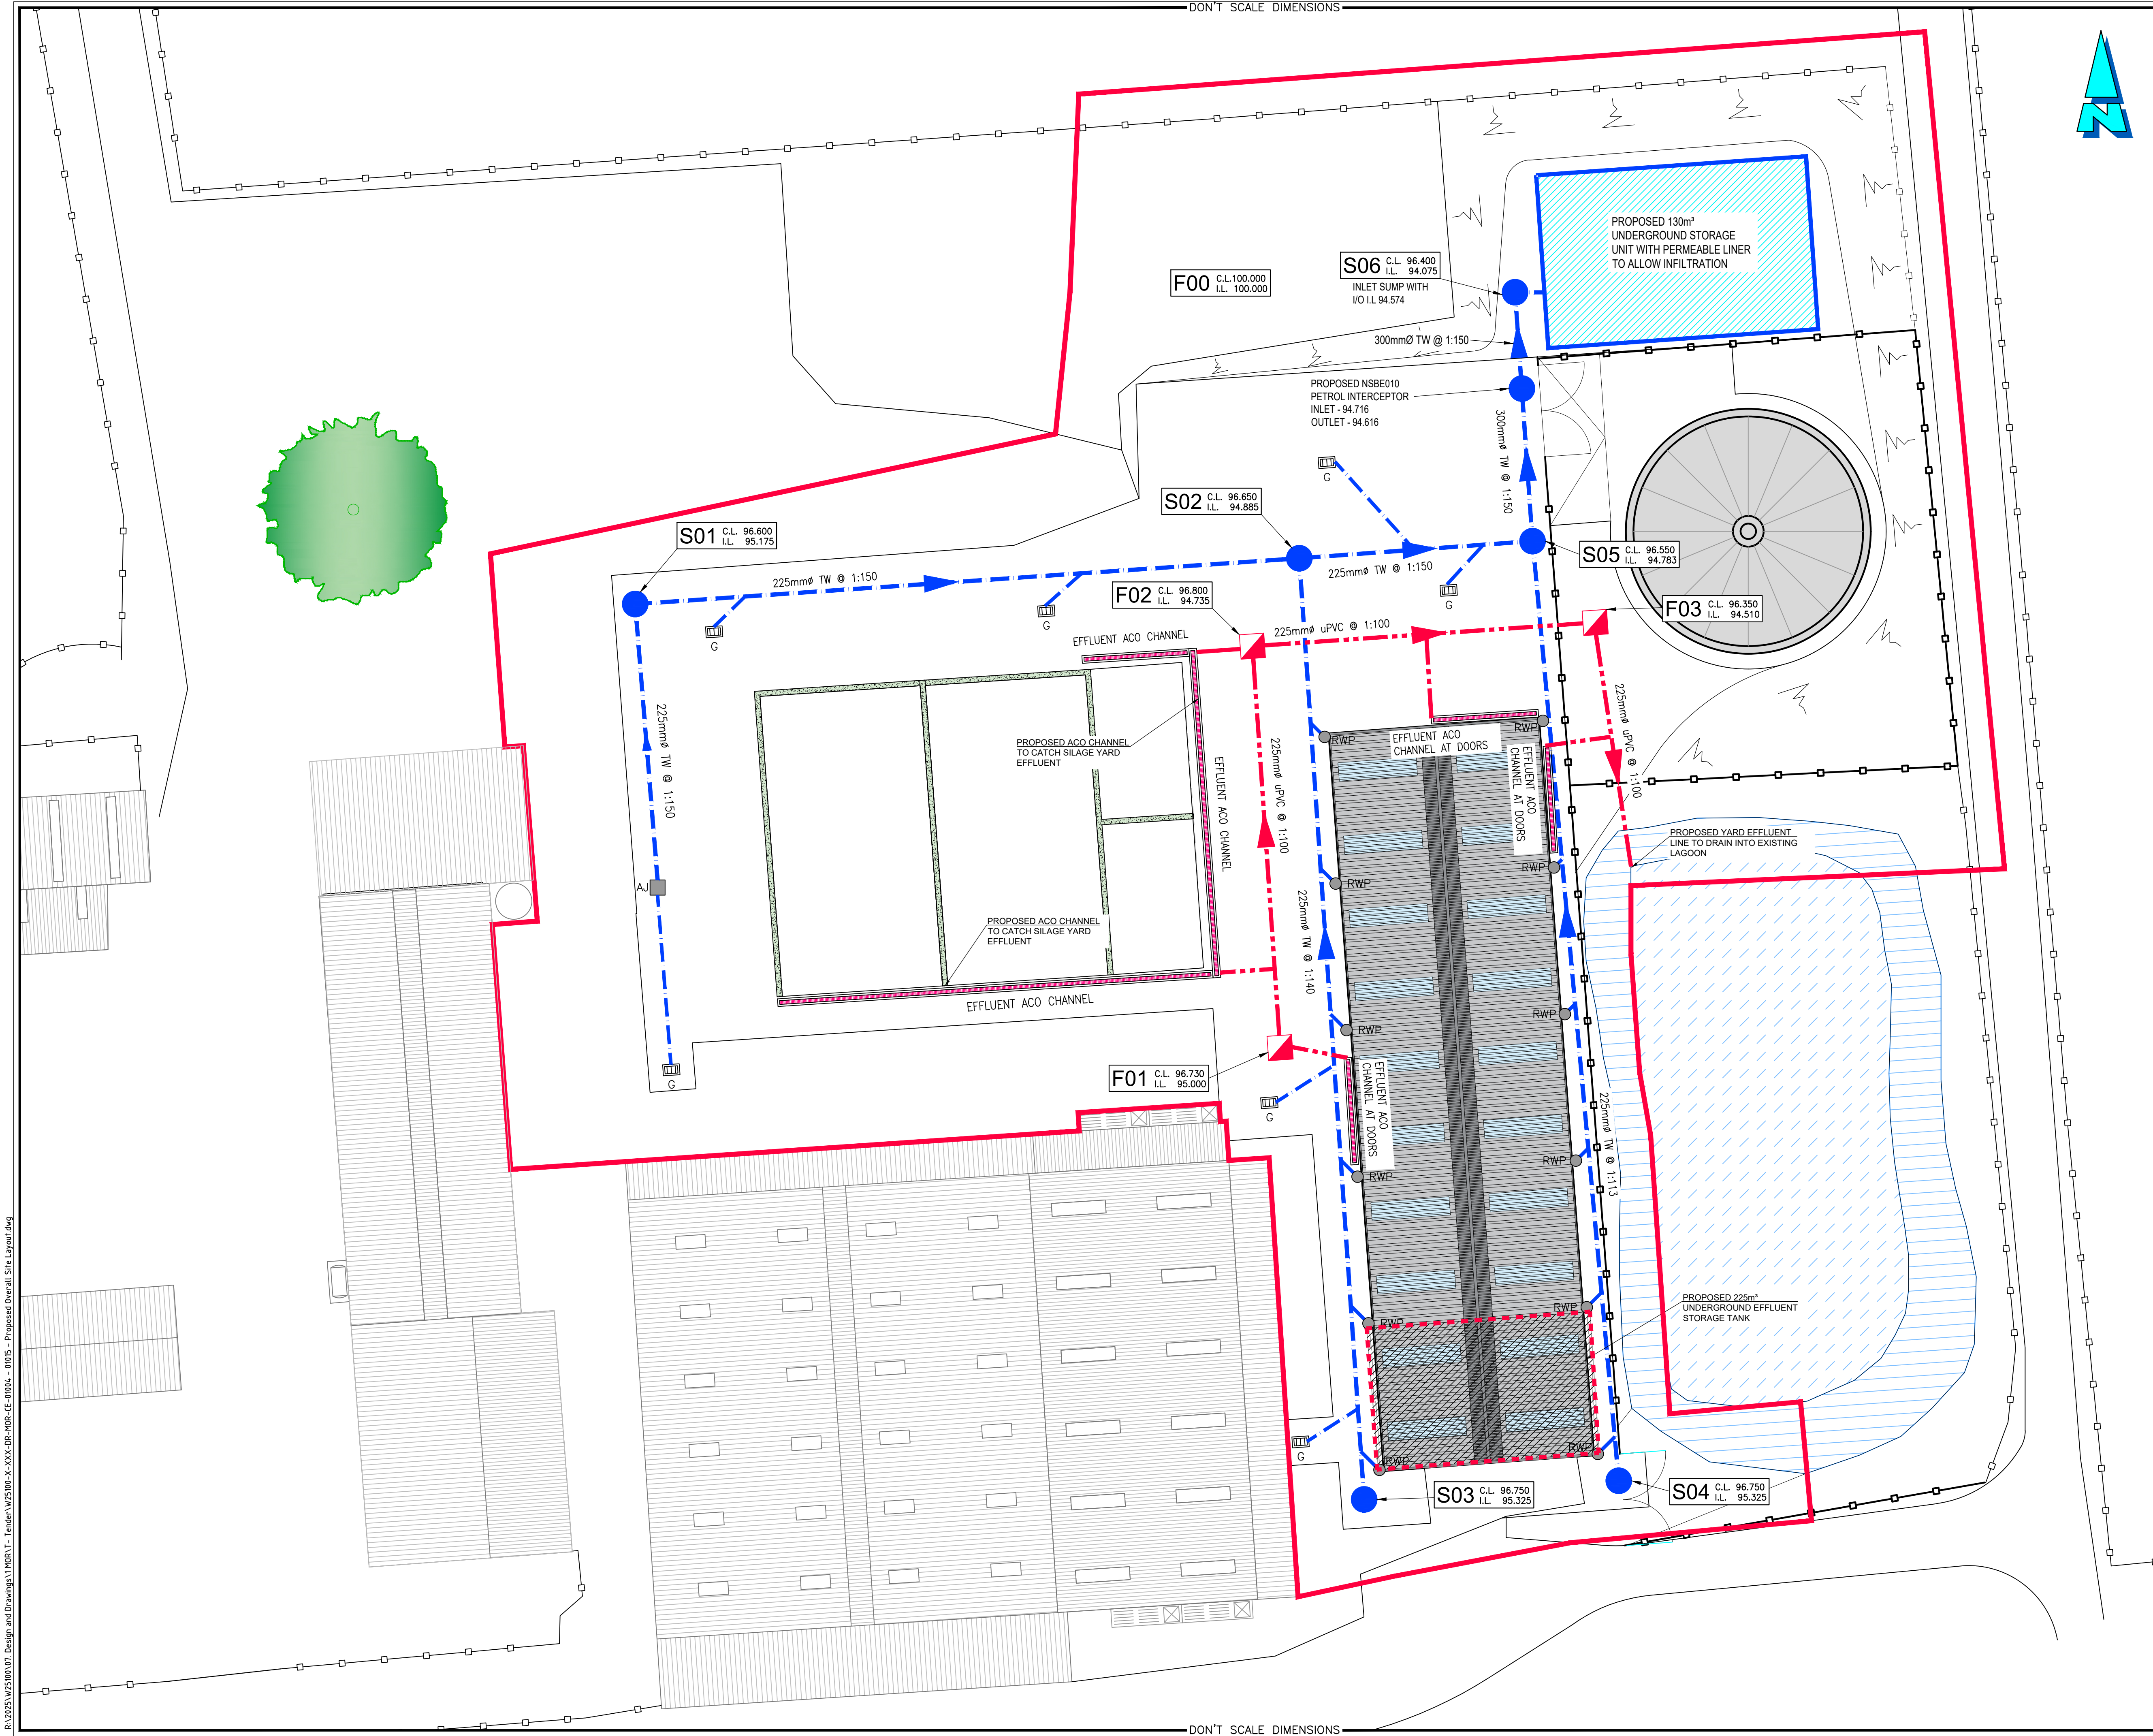


Health and Safety:

THIS DRAWING TO BE READ IN CONJUNCTION WITH ALL OTHER RELEVANT DRAWINGS, THE SPECIFICATION AND THE SAFETY AND HEALTH PLAN.

THE APPOINTMENT OF THE PROJECT SUPERVISOR DESIGN PROCESS IS THE CLIENT'S RESPONSIBILITY.

TEMPORARY WORKS PROPOSALS AND/OR METHOD STATEMENTS TO BE SUBMITTED TO THE PSPD AND THE PCS FOR WORKS WHICH INVOLVE PARTICULAR RISKS.

Note:

- NO PART OF THIS DRAWING MAY BE REPRODUCED OR TRANSMITTED IN ANY FORM OR STORED IN ANY RETRIEVAL SYSTEM OF ANY NATURE WITHOUT THE WRITTEN PERMISSION OF MALONE O'REGAN CONSULTING ENGINEERS AS COPYRIGHT HOLDER EXCEPT AS AGREED FOR USE ON THE PROJECT FOR WHICH THE DRAWING WAS ORIGINALLY ISSUED.
- THE APPOINTMENT OF THE PROJECT SUPERVISOR DESIGN PROCESS IS THE CLIENT'S RESPONSIBILITY.
- ALL DIMENSIONS IN mm UNLESS NOTED OTHERWISE.
- THE CONTRACTOR SHALL CHECK ALL DIMENSIONS PRIOR TO COMMENCEMENT OF CONSTRUCTION. DISCREPANCIES SHALL BE REPORTED TO THIS OFFICE IN WRITING.
- THIS DRAWING TO BE READ IN ACCORDANCE WITH ALL RELEVANT ENGINEERS' DRAWINGS AND SPECIFICATIONS.

LEGEND:

SITE BOUNDARY SHOWN AS:

DRAINAGE - LEGEND

- PROPOSED SURFACE WATER DRAINAGE: 150mm @SLOPE 1:25
- PROPOSED ROAD GULLY: G
- PROPOSED A.J.: A.J.
- PROPOSED R.W.P.: RWP
- PROPOSED EFFLUENT WATER DRAINAGE: 150mm @SLOPE 1:25
- PROPOSED ACO DRAIN CHANNEL EFFLUENT:
- PROPOSED UNDERGROUND SURFACE WATER STORAGE TANK WITH PERMEABLE LINER:
- PROPOSED SELF CONTAINED UNDERGROUND EFFLUENT STORAGE TANK:

0 TENDER ISSUE 24.07.2026 SON JK

Rev. Description Date Drawn Chkd

Status: P8 - ISSUED FOR TENDER

MOR
MALONE O'REGAN
CONSULTING ENGINEERS

3-4 Canada Street
Waterford
Co. Waterford.
X91 V52K
Tel: +353 51 876 855
Email: waterford@mor.ie
Web: www.maloneyregan.com

Offices also in:

DUBLIN : Tel: +353 1 260 2655 Email: dublin@mor.ie
GALWAY: Tel: +353 91 531 069 Email: galway@mor.ie
LONDON: Tel: +44 208 5281685 Email: london@mor.ie

Client: TEAGASC

Job: FARMYARD DEVELOPMENT AT TEAGASC SOLOHEAD

Drawing: PROPOSED DRAINAGE LAYOUT

Job No	Revision	Approver	Scale	Sheet
W25100	T	JK	A1 1:200 A3 1:400	A1

Drg No: W25100-X-XXX-DR-MOR-CE-01005