


Library

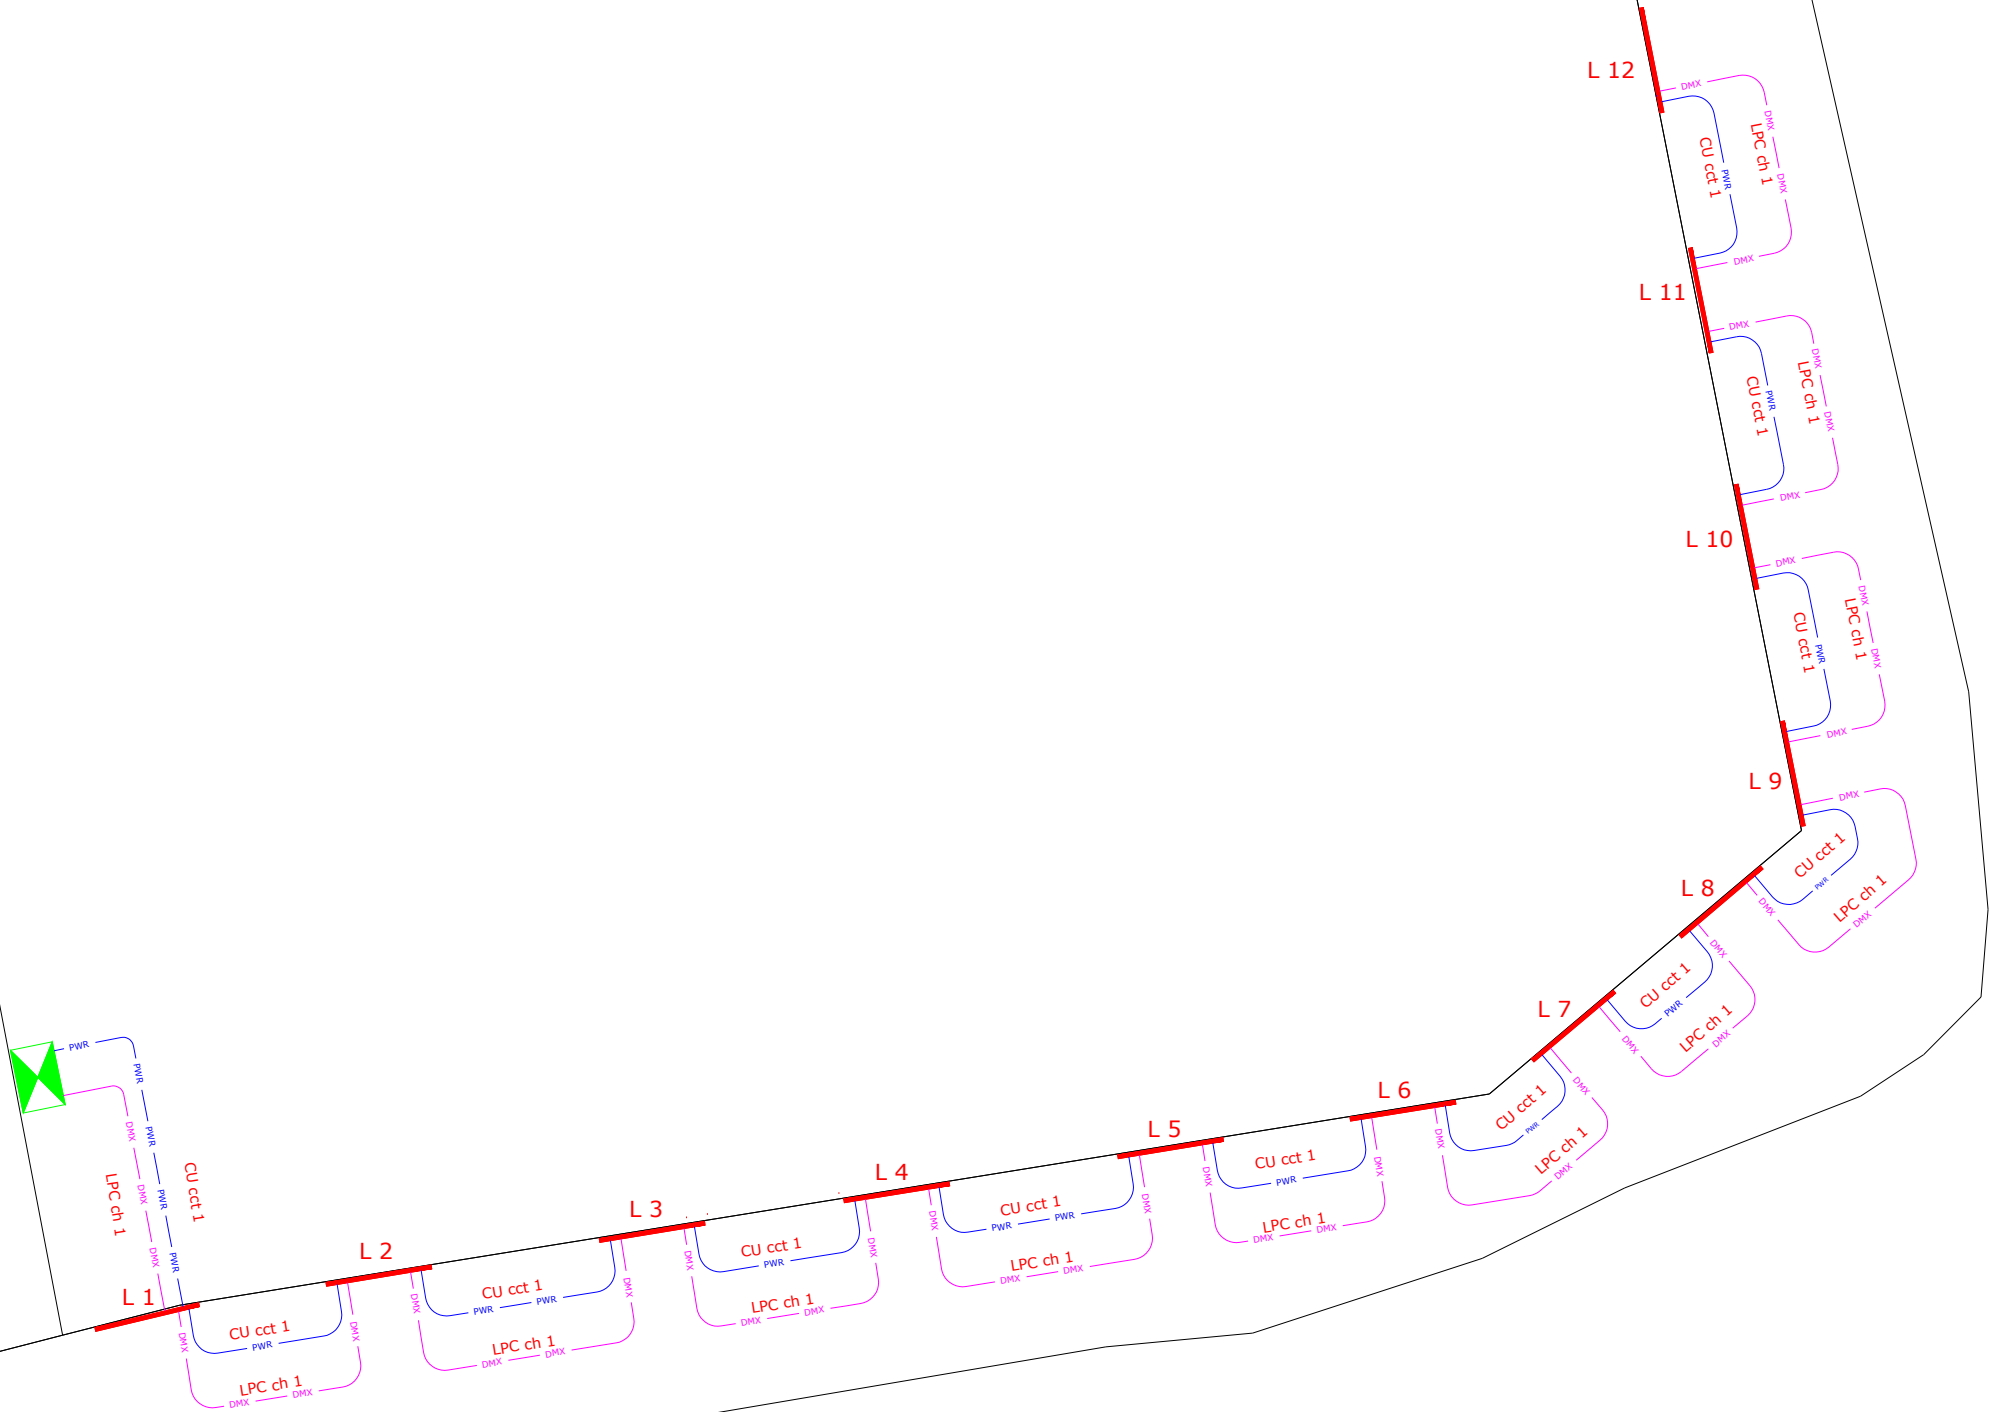

LANE

© COPYRIGHT RESERVED (Redmond AMS Ltd.)

Urbis Sculptline S100 6291 RGBW Diffuser P25 striated 40 Oslon SSL 150 350mA 346982, complete with mounting kit and embellishment plate. Mounted on adjustable brackets, below lower cornice, aimed downwards. To be fixed using chemical anchors only. 50W connected load at maximum output.

Urbis Sculptline S50 6291 RGBW Diffuser P25 Striated 20 Oslon SSL 150 350mA 346982, complete with mounting kit and embellishment plate. Mounted on adjustable brackets, above lower cornice, aimed upward. To be fixed using chemical anchors only. 25W connected load at maximum output.

Urbis Sculptline S50 6291 RGBW Diffuser P25 Striated 20 Oslon SSL 150 350mA 346982, complete with mounting kit and embellishment plate. Mounted on adjustable brackets, above upper cornice, aimed upward. To be fixed using chemical anchors only. 25W connected load at maximum output.

Urbis Lighting Playback Controller, Urbis DMX Splitter, and Urbis Cellular Router to be installed close to the consumer unit within the building.

Contractor will be required to find appropriate routing for cables within the building.

Ducts and cables to be laid in accordance with Waterford City & County Council specifications and I. S. 10101: Latest version.

Be advised that other services may exist that are not shown on this drawing. This drawing should not be taken as definitive or an indication that it is safe to dig.

Drawing title:
As Built Illumination Layout ~ Below Lower Cornice

Project title:
Fáilte Ireland Urban Animation ~ Central Library

Client:
Waterford City & County Council

Project number: 22006	Date: 04/06/2025	Hard copy approved:
Drawing number: 22006 - 1A	Revision: 0	Drawn by: Patrick Redmond

Read in conjunction with associated lighting calculations

Do not scale from drawing All dimensions in metres

Document control: TD 09 Version: 1.0

Redmond Analytical Management Services Ltd.
Rosewood House, Mount Seaton, Camolin, Enniscorthy, Co. Wexford. Y21 K8P3
086 2356356 info@redmondams.ie www.redmondams.ie




MSLL ~ Society of Light and Lighting

MILP ~ Institution of Lighting Professionals



Library

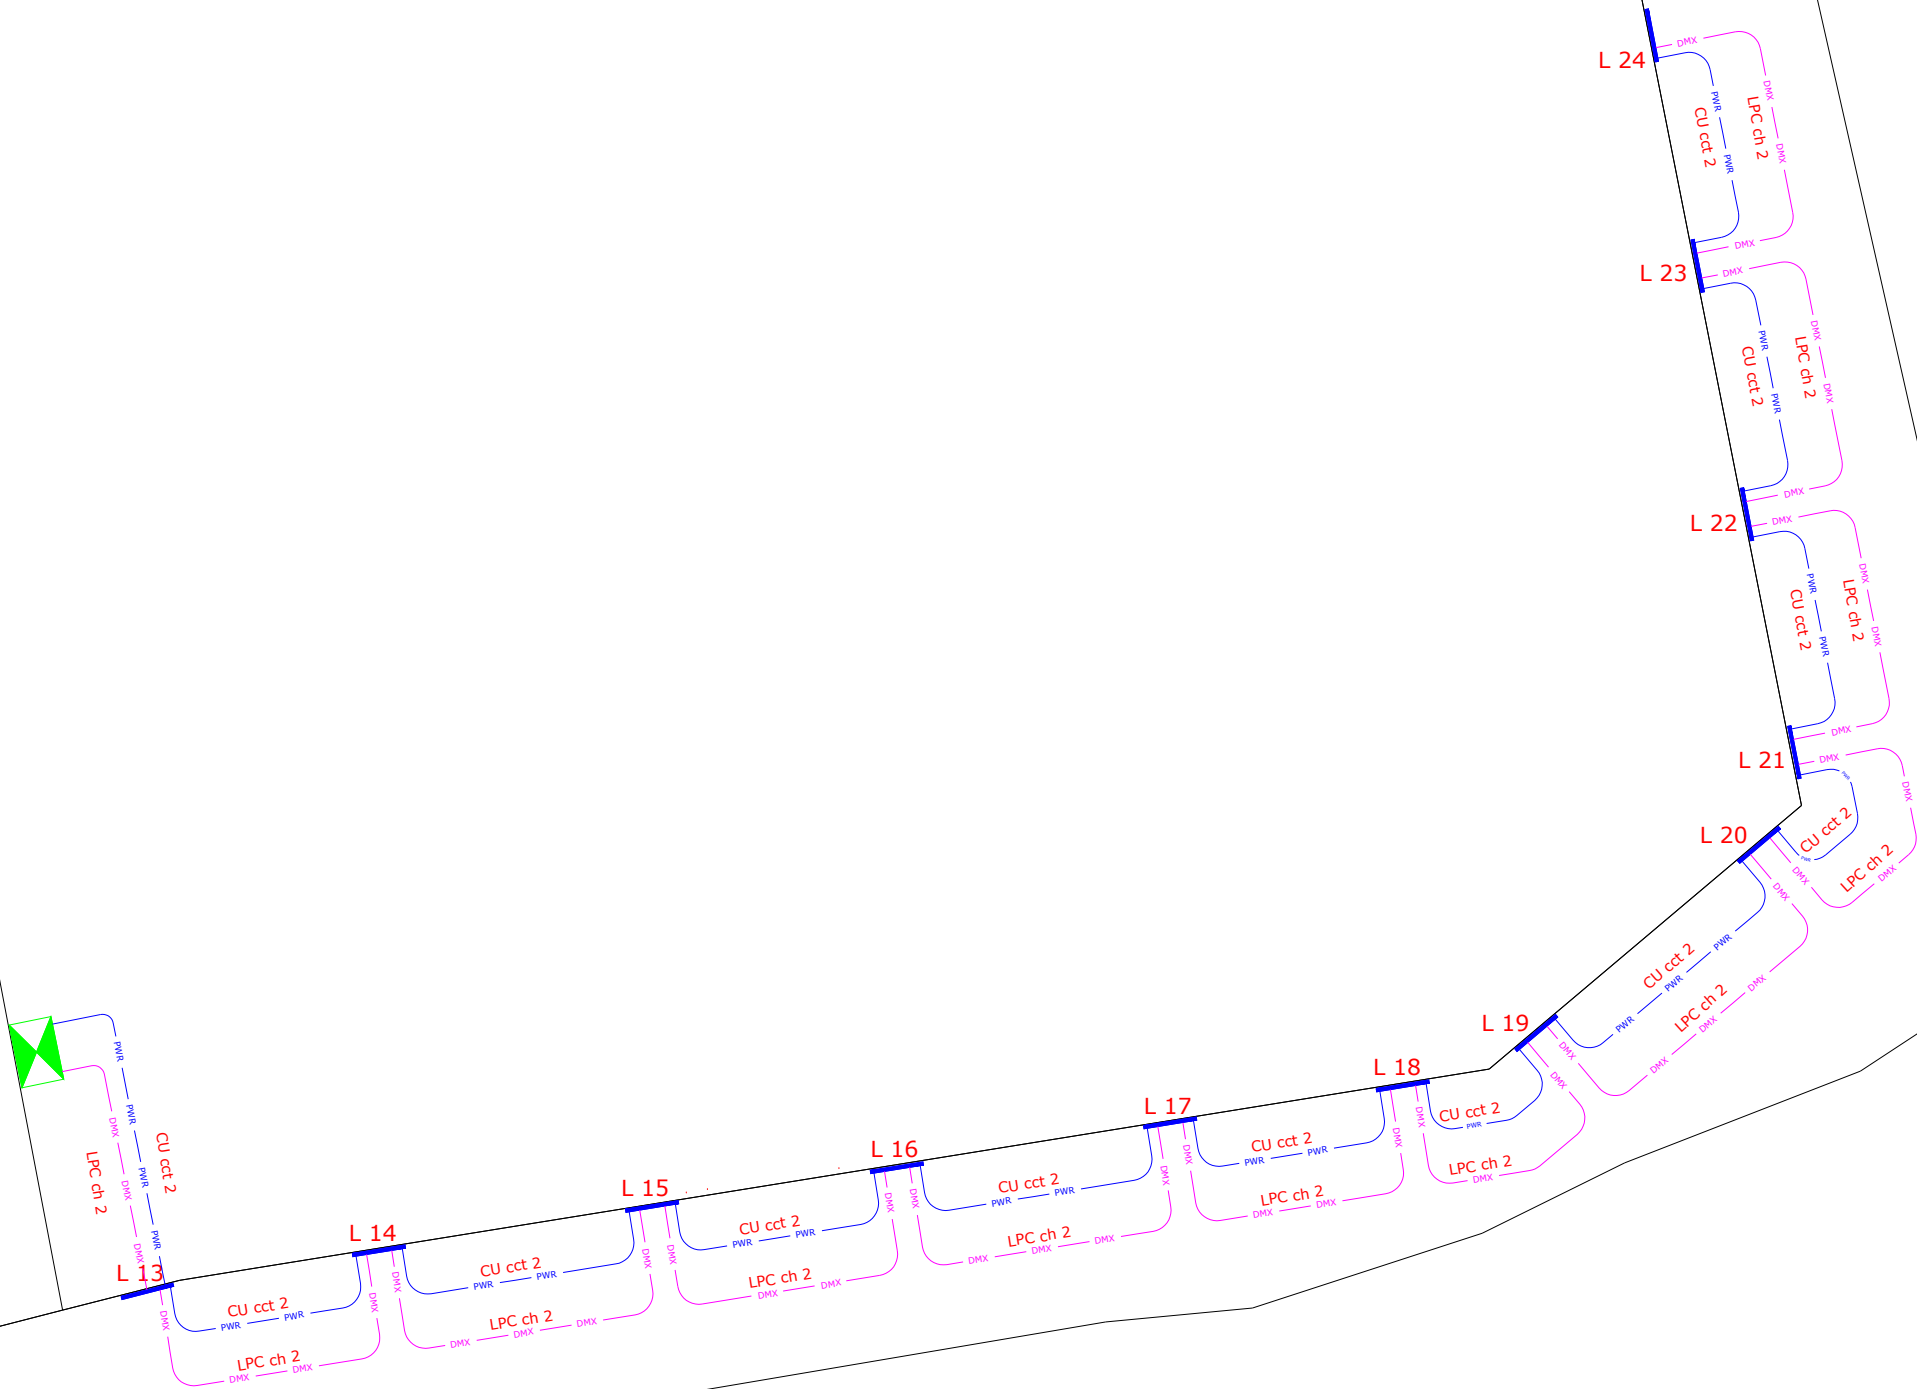

Urbis Sculptline S100 6291 RGBW Diffuser P25 striated 40 Oslon SSL 150 350mA 346982, complete with mounting kit and embellishment plate. Mounted on adjustable brackets, below lower cornice, aimed downwards. To be fixed using chemical anchors only. 50W connected load at maximum output.

Urbis Sculptline S50 6291 RGBW Diffuser P25 Striated 20 Oslon SSL 150 350mA 346982, complete with mounting kit and embellishment plate. Mounted on adjustable brackets, above lower cornice, aimed upward. To be fixed using chemical anchors only. 25W connected load at maximum output.

Urbis Sculptline S50 6291 RGBW Diffuser P25 Striated 20 Oslon SSL 150 350mA 346982, complete with mounting kit and embellishment plate. Mounted on adjustable brackets, above upper cornice, aimed upward. To be fixed using chemical anchors only. 25W connected load at maximum output.

Urbis Lighting Playback Controller, Urbis DMX Splitter, and Urbis Cellular Router to be installed close to the consumer unit within the building.

Contractor will be required to find appropriate routing for cables within the building.

Ducts and cables to be laid in accordance with Waterford City & County Council specifications and I. S. 10101: Latest version.

Be advised that other services may exist that are not shown on this drawing. This drawing should not be taken as definitive or an indication that it is safe to dig.

Drawing title:
As Built Illumination Layout ~ Above Lower Cornice

Project title:
Fáilte Ireland Urban Animation ~ Central Library

Client:
Waterford City & County Council

Project number: 22006	Date: 04/06/2025	Hard copy approved:
Drawing number: 22006 - 2A	Revision: 0	Drawn by: Patrick Redmond

Read in conjunction with associated lighting calculations

Do not scale from drawing All dimensions in metres

Document control: TD 09 Version: 1.0

Redmond Analytical Management Services Ltd.
Rosewood House, Mount Seaton, Camolin, Enniscorthy, Co. Wexford. Y21 K8P3
086 2356356 info@redmondams.ie www.redmondams.ie




MSLL ~ Society of Light and Lighting

MILP ~ Institution of Lighting Professionals



Library

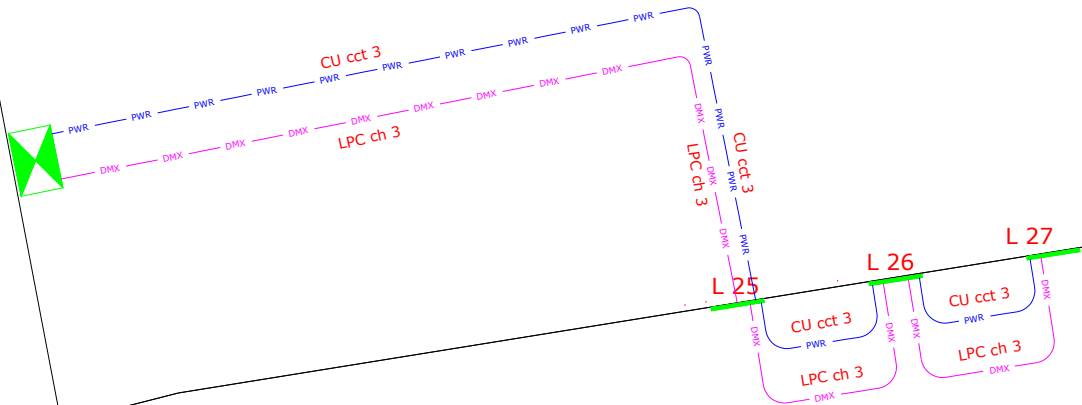

© COPYRIGHT RESERVED (Redmond AMS Ltd.)

Urbis Sculptline S100 6291 RGBW Diffuser P25 striated 40 Oslon SSL 150 350mA 346982, complete with mounting kit and embellishment plate. Mounted on adjustable brackets, below lower cornice, aimed downwards. To be fixed using chemical anchors only. 50W connected load at maximum output.

Urbis Sculptline S50 6291 RGBW Diffuser P25 Striated 20 Oslon SSL 150 350mA 346982, complete with mounting kit and embellishment plate. Mounted on adjustable brackets, above lower cornice, aimed upward. To be fixed using chemical anchors only. 25W connected load at maximum output.

Urbis Sculptline S50 6291 RGBW Diffuser P25 Striated 20 Oslon SSL 150 350mA 346982, complete with mounting kit and embellishment plate. Mounted on adjustable brackets, above upper cornice, aimed upward. To be fixed using chemical anchors only. 25W connected load at maximum output.

Urbis Lighting Playback Controller, Urbis DMX Splitter, and Urbis Cellular Router to be installed close to the consumer unit within the building.

Contractor will be required to find appropriate routing for cables within the building.

Ducts and cables to be laid in accordance with Waterford City & County Council specifications and I. S. 10101: Latest version.

Be advised that other services may exist that are not shown on this drawing. This drawing should not be taken as definitive or an indication that it is safe to dig.

Drawing title: As Built Illumination Layout ~ Above Upper Cornice		
Project title: Fáilte Ireland Urban Animation ~ Central Library		
Client: Waterford City & County Council		
Project number: 22006	Date: 04/06/2025	Hard copy approved:
Drawing number: 22006 - 3A	Revision: 0	Drawn by: Patrick Redmond
Read in conjunction with associated lighting calculations		
Do not scale from drawing		All dimensions in metres
Document control: TD 09		Version: 1.0
Redmond Analytical Management Services Ltd. Rosewood House, Mount Seaton, Camolin, Enniscorthy, Co. Wexford. Y21 K8P3		
086 2356356	info@redmondams.ie	www.redmondams.ie



REDMOND
ANALYTICAL MANAGEMENT SERVICES
LIGHTING | ENERGY | DESIGN | SUPPORT

MSLL ~ Society of Light and Lighting

MILP ~ Institution of Lighting Professionals





Upper cornice

Lower cornice

- © COPYRIGHT RESERVED (Redmond AMS Ltd.)
- Urbis Sculptline S100 6291 RGBW Diffuser P25 Striated 40 Osion SSL 150 350mA 346982, complete with mounting kit and embellishment plate. Mounted on adjustable brackets, below lower cornice, aimed downwards. To be fixed using chemical anchors only. 50W connected load at maximum output.
- Urbis Sculptline S50 6291 RGBW Diffuser P25 Striated 20 Osion SSL 150 350mA 346982, complete with mounting kit and embellishment plate. Mounted on adjustable brackets, above lower cornice, aimed upward. To be fixed using chemical anchors only. 25W connected load at maximum output.
- Urbis Sculptline S50 6291 RGBW Diffuser P25 Striated 20 Osion SSL 150 350mA 346982, complete with mounting kit and embellishment plate. Mounted on adjustable brackets, above upper cornice, aimed upward. To be fixed using chemical anchors only. 25W connected load at maximum output.
- Urbis Lighting Playback Controller, Urbis DMX Splitter, and Urbis Cellular Router to be installed close to the consumer unit within the building.
- Contractor will be required to find appropriate routing for cables within the building.
- Ducts and cables to be laid in accordance with Waterford City & County Council specifications and I. S. 10101: Latest version.

Be advised that other services may exist that are not shown on this drawing. This drawing should not be taken as definitive or an indication that it is safe to dig.		
Drawing title: As Built Illumination Layout ~ South Elevation		
Project title: Fáilte Ireland Urban Animation ~ Central Library		
Client: Waterford City & County Council		
Project number: 22006	Date: 04/06/2025	Hard copy approved:
Drawing number: 22006 - 4A	Revision: 0	Drawn by: Patrick Redmond
Read in conjunction with associated lighting calculations		
Do not scale from drawing		All dimensions in metres
Document control: TD 09		Version: 1.0
Redmond Analytical Management Services Ltd. Rosewood House, Mount Seaton, Camolin, Enniscorthy, Co. Wexford. Y21 K8P3 086 2356356 info@redmondams.ie www.redmondams.ie		



ANALYTICAL MANAGEMENT SERVICES
LIGHTING | ENERGY | DESIGN | SUPPORT

MSLL ~ Society of Light and Lighting

MILP ~ Institution of Lighting Professionals



© COPYRIGHT RESERVED (Redmond AMS Ltd.)

Urbis Sculptline S100 6291 RGBW Diffuser P25 striated 40 Osion SSL 150 350mA 346982, complete with mounting kit and embellishment plate. Mounted on adjustable brackets, below lower cornice, aimed downwards. To be fixed using chemical anchors only. 50W connected load at maximum output.

Urbis Sculptline S50 6291 RGBW Diffuser P25 Striated 20 Osion SSL 150 350mA 346982, complete with mounting kit and embellishment plate. Mounted on adjustable brackets, above lower cornice, aimed upward. To be fixed using chemical anchors only. 25W connected load at maximum output.

Urbis Sculptline S50 6291 RGBW Diffuser P25 Striated 20 Osion SSL 150 350mA 346982, complete with mounting kit and embellishment plate. Mounted on adjustable brackets, above upper cornice, aimed upward. To be fixed using chemical anchors only. 25W connected load at maximum output.

Urbis Lighting Playback Controller, Urbis DMX Splitter, and Urbis Cellular Router to be installed close to the consumer unit within the building.

Contractor will be required to find appropriate routing for cables within the building.

Ducts and cables to be laid in accordance with Waterford City & County Council specifications and I. S. 10101: Latest version.

Be advised that other services may exist that are not shown on this drawing. This drawing should not be taken as definitive or an indication that it is safe to dig.

Drawing title:
As Built Illumination Layout ~ East Elevation

Project title:
Fáilte Ireland Urban Animation ~ Central Library

Client:
Waterford City & County Council

Project number: 22006	Date: 04/06/2025	Hard copy approved:
Drawing number: 22006 - 5A	Revision: 0	Drawn by: Patrick Redmond

Read in conjunction with associated lighting calculations


Do not scale from drawing	All dimensions in metres
Document control: TD 09	Version: 1.0

Redmond Analytical Management Services Ltd.
Rosewood House, Mount Seaton, Camolin, Enniscorthy, Co. Wexford. Y21 K8P3
086 2356356 | info@redmondams.ie | www.redmondams.ie

REDMOND
ANALYTICAL MANAGEMENT SERVICES
LIGHTING | ENERGY | DESIGN | SUPPORT

MSLL ~ Society of Light and Lighting

MILP ~ Institution of Lighting Professionals

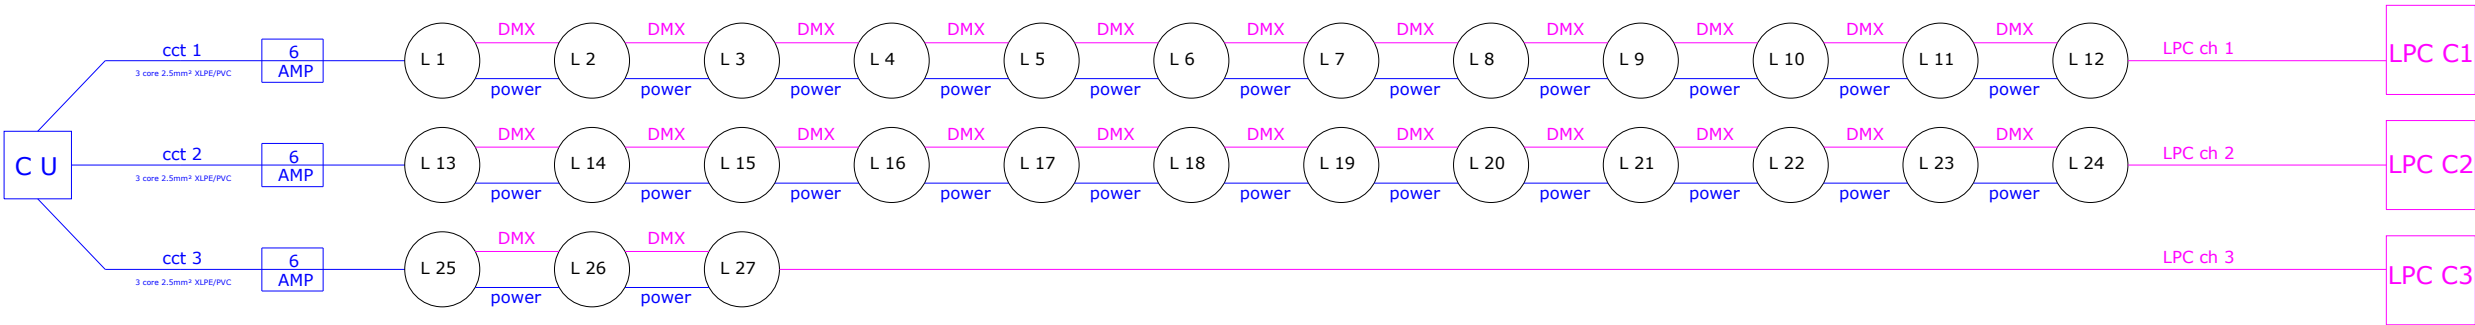

- © COPYRIGHT RESERVED (Redmond AMS Ltd.)
- Urbis Sculptline S100 6291 RGBW Diffuser P25 striated 40 Oslon SSL 150 350mA 346982, complete with mounting kit and embellishment plate. Mounted on adjustable brackets, below lower cornice, aimed downwards. To be fixed using chemical anchors only. 50W connected load at maximum output.
- Urbis Sculptline S50 6291 RGBW Diffuser P25 Striated 20 Oslon SSL 150 350mA 346982, complete with mounting kit and embellishment plate. Mounted on adjustable brackets, above lower cornice, aimed upward. To be fixed using chemical anchors only. 25W connected load at maximum output.
- Urbis Sculptline S50 6291 RGBW Diffuser P25 Striated 20 Oslon SSL 150 350mA 346982, complete with mounting kit and embellishment plate. Mounted on adjustable brackets, above upper cornice, aimed upward. To be fixed using chemical anchors only. 25W connected load at maximum output.
- Urbis Lighting Playback Controller, Urbis DMX Splitter, and Urbis Cellular Router to be installed close to the consumer unit within the building.
- Contractor will be required to find appropriate routing for cables within the building.
- Ducts and cables to be laid in accordance with Waterford City & County Council specifications and I. S. 10101: Latest version.

Be advised that other services may exist that are not shown on this drawing. This drawing should not be taken as definitive or an indication that it is safe to dig.

Drawing title: Electrical Schematic		
Project title: Fáilte Ireland Urban Animation ~ Central Library		
Client: Waterford City & County Council		
Project number: 22006	Date: 04/06/2025	Hard copy approved:
Drawing number: 22006 - 6A	Revision: 0	Drawn by: Patrick Redmond
Read in conjunction with associated lighting calculations		
Do not scale from drawing	All dimensions in metres	
Document control: TD 09	Version: 1.0	
Redmond Analytical Management Services Ltd. Rosewood House, Mount Seaton, Camolin, Enniscorthy, Co. Wexford. Y21 K8P3		
086 2356356	info@redmondams.ie	www.redmondams.ie



ANALYTICAL MANAGEMENT SERVICES
LIGHTING | ENERGY | DESIGN | SUPPORT

MSLL ~ Society of Light and Lighting

MILP ~ Institution of Lighting Professionals

