


GENERAL NOTES

- THIS DRAWING SHALL BE READ IN CONJUNCTION WITH THE SPECIFICATION AND ALL OTHER RELEVANT DRAWINGS.
- THIS DRAWING MUST NOT BE SCALED FOR INSTALLATION PURPOSES. WORK TO FIGURED AND SITE OBTAINED DIMENSION ONLY.
- THE ELECTRICAL SERVICES CONTRACTOR IS FULLY RESPONSIBLE FOR ALL ON-SITE CO-ORDINATION OF HIS AND ALL OTHER SERVICES.

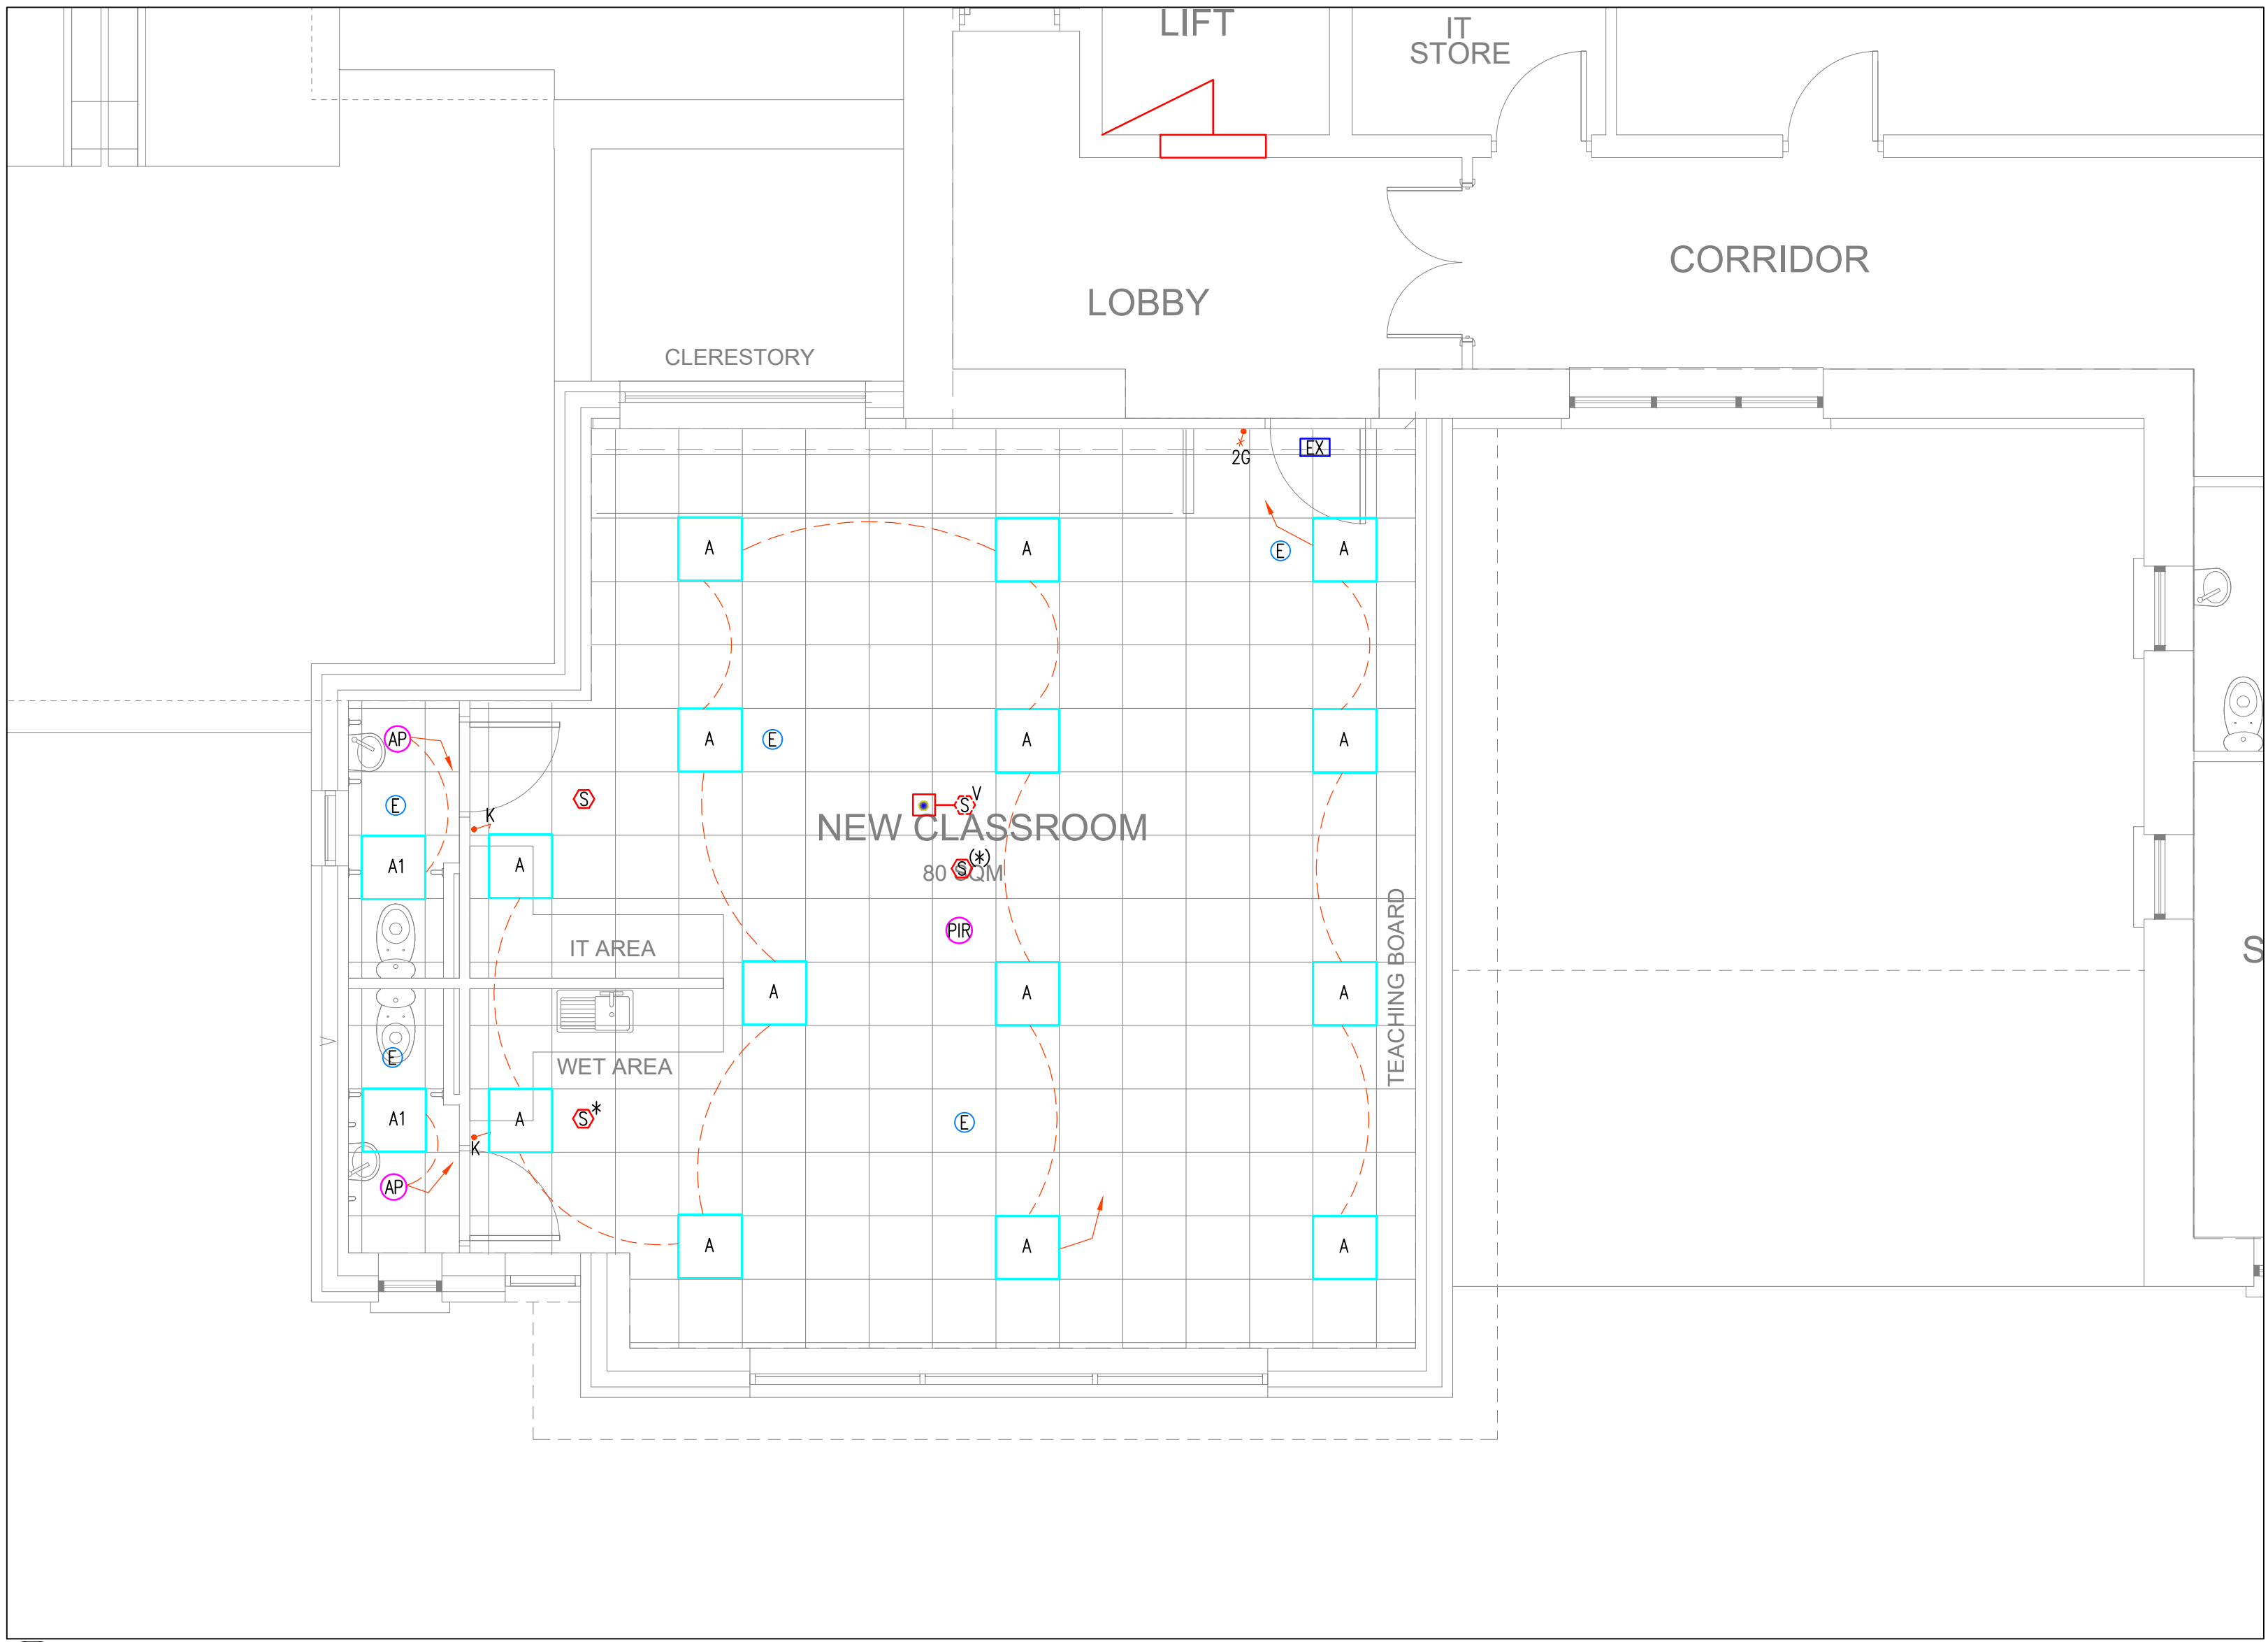

(E101)
01 LIGHTING, EMERGENCY LIGHTING & FIRE ALARM LAYOUT – FIRST FLOOR
SCALE 1:50 @ A1 1:100 @ A3

LEGEND OF SYMBOLS

	FISH KEY LIGHT SWITCH
	LIGHT SWITCH (2-WAY)
	LIGHT SWITCH (1 WAY)
	RETRACTIVE DIMMER LIGHT SWITCH
	600mm x 600mm 3000lm, 4000K, 19W DALI DIMMABLE CRI>80
	600mm x 600mm 3000lm, 4000K, 19W FIXED OUTPUT CRI>80
	600mm x 600mm 2000lm, 4000K, 13W DALI DIMMABLE CRI>80
	600mm x 600mm 2000lm, 4000K, 13W FIXED OUTPUT CRI>80
	600mm x 600mm 2000lm, 4000K, 13W FIXED OUTPUT CRI>80 C/W SURFACE MOUNTING KIT AND FRAME
	IP66 IK10 ASYMMETRIC OPTIC 19W 4000K 2800LM DARK SKY APPROVED WITH EMERGENCY

LEGEND OF SYMBOLS

	200lm, 6500K, 2W, – OPEN AREAS OPTIC – BEAM ANGLE 150DEGREES RECESSED
	EXIT SIGN
	DIRECTIONAL EXIT SIGN
	DAY LIGHT SENSOR WITH ABSENCE & PRESENCE DETECTOR
	AUTOMATIC PRESENCE & ABSENCE DETECTOR
	SMOKE DETECTOR
	SMOKE DETECTOR WITH SOUNDER
	SMOKE DETECTOR WITH SOUND BASE / STROBE
	SMOKE DETECTOR IN VOID WITH INDICATOR
	HEAT DETECTOR WITH SOUND BASE / STROBE
	BREAK GLASS UNIT
	FIRE ALARM SOUNDER / STROBE
	EXTERNAL FIRE ALARM SOUNDER/STROBE



TO	ISSUE FOR TENDER	19.08.26	CR
Revisions		Date	Checked
 COLMAN REYNOLDS ASSOCIATES Building Services Engineers and Project Managers Unit 9 Southern Cross Business Park, Boghall Rd, Bray, Co Wicklow. [t] +353-1-2768700 [f] +353-1-6865522 [e] info@cra.ie			
Project COLLOONEY NS, SLIGO			
Drawing Title LIGHTING, EMERGENCY LTG & FIRE ALARM FIRST FLOOR			
Date 07.07.26	Drawn PH	Checked CR	Scale 1:50 @ A1 1:100 @ A3
Project No. A1172		Drawing No. E101	
		Rev. TO	