

GENERAL NOTES

- THIS DRAWING SHALL BE READ IN CONJUNCTION WITH THE SPECIFICATION AND ALL OTHER RELEVANT DRAWINGS.
- THIS DRAWING MUST NOT BE SCALED FOR INSTALLATION PURPOSES. WORK TO FIGURED AND SITE OBTAINED DIMENSION ONLY.
- THE ELECTRICAL SERVICES CONTRACTOR IS FULLY RESPONSIBLE FOR ALL ON-SITE CO-ORDINATION OF HIS AND ALL OTHER SERVICES.


LEGEND OF SYMBOLS

	SMOKE DETECTOR
	SMOKE DETECTOR WITH SOUNDER
	SMOKE DETECTOR WITH SOUND BASE / STROBE
	SMOKE DETECTOR IN VOID WITH INDICATOR
	HEAT DETECTOR WITH SOUNDER
	HEAT DETECTOR WITH SOUND BASE / STROBE
	BREAK GLASS UNIT
	FIRE ALARM
	SOUNDER / STROBE
	EXTERNAL FIRE ALARM
	FIRE ALARM PANEL
	INPUT / OUTPUT DEVICE UNIT
	FIRE DOOR HOLDER

EXISTING LEGEND OF SYMBOLS


	SMOKE DETECTOR
	SMOKE DETECTOR WITH SOUNDER
	SMOKE DETECTOR WITH SOUND BASE / STROBE
	HEAT DETECTOR
	HEAT DETECTOR WITH SOUNDER
	HEAT DETECTOR WITH SOUND BASE / STROBE
	SMOKE DETECTOR IN VOID
	SMOKE DETECTOR IN VOID WITH INDICATOR
	FIRE DOOR HOLDER
	FIRE ALARM
	SOUNDER / STROBE
	EXTERNAL FIRE ALARM
	SOUNDER/STROBE
	BREAK GLASS UNIT
	FIRE ALARM PANEL
	INPUT / OUTPUT DEVICE UNIT
	AIR SAMPLING PANEL
	AIR SAMPLING TUBE
	POINT/TEST POINT

TO	ISSUE FOR TENDER	25.08.26	CR
Revisions		Date	Checked

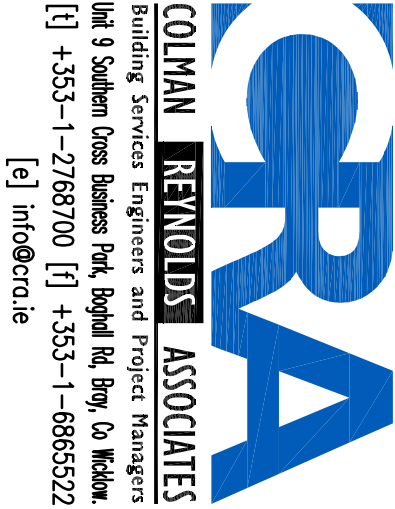


Project COLLOONEY NS, SLIGO

Drawing Title			
FIRE ALARM LAYOUT			
GROUND & FIRST FLOOR			
Date	Drawn	Checked	Scale
07.07.26	PH	CR	1:100 @ A1 1:200 @ A3
Project No.	A1172	Drawing No.	E102
			Rev.
			TO

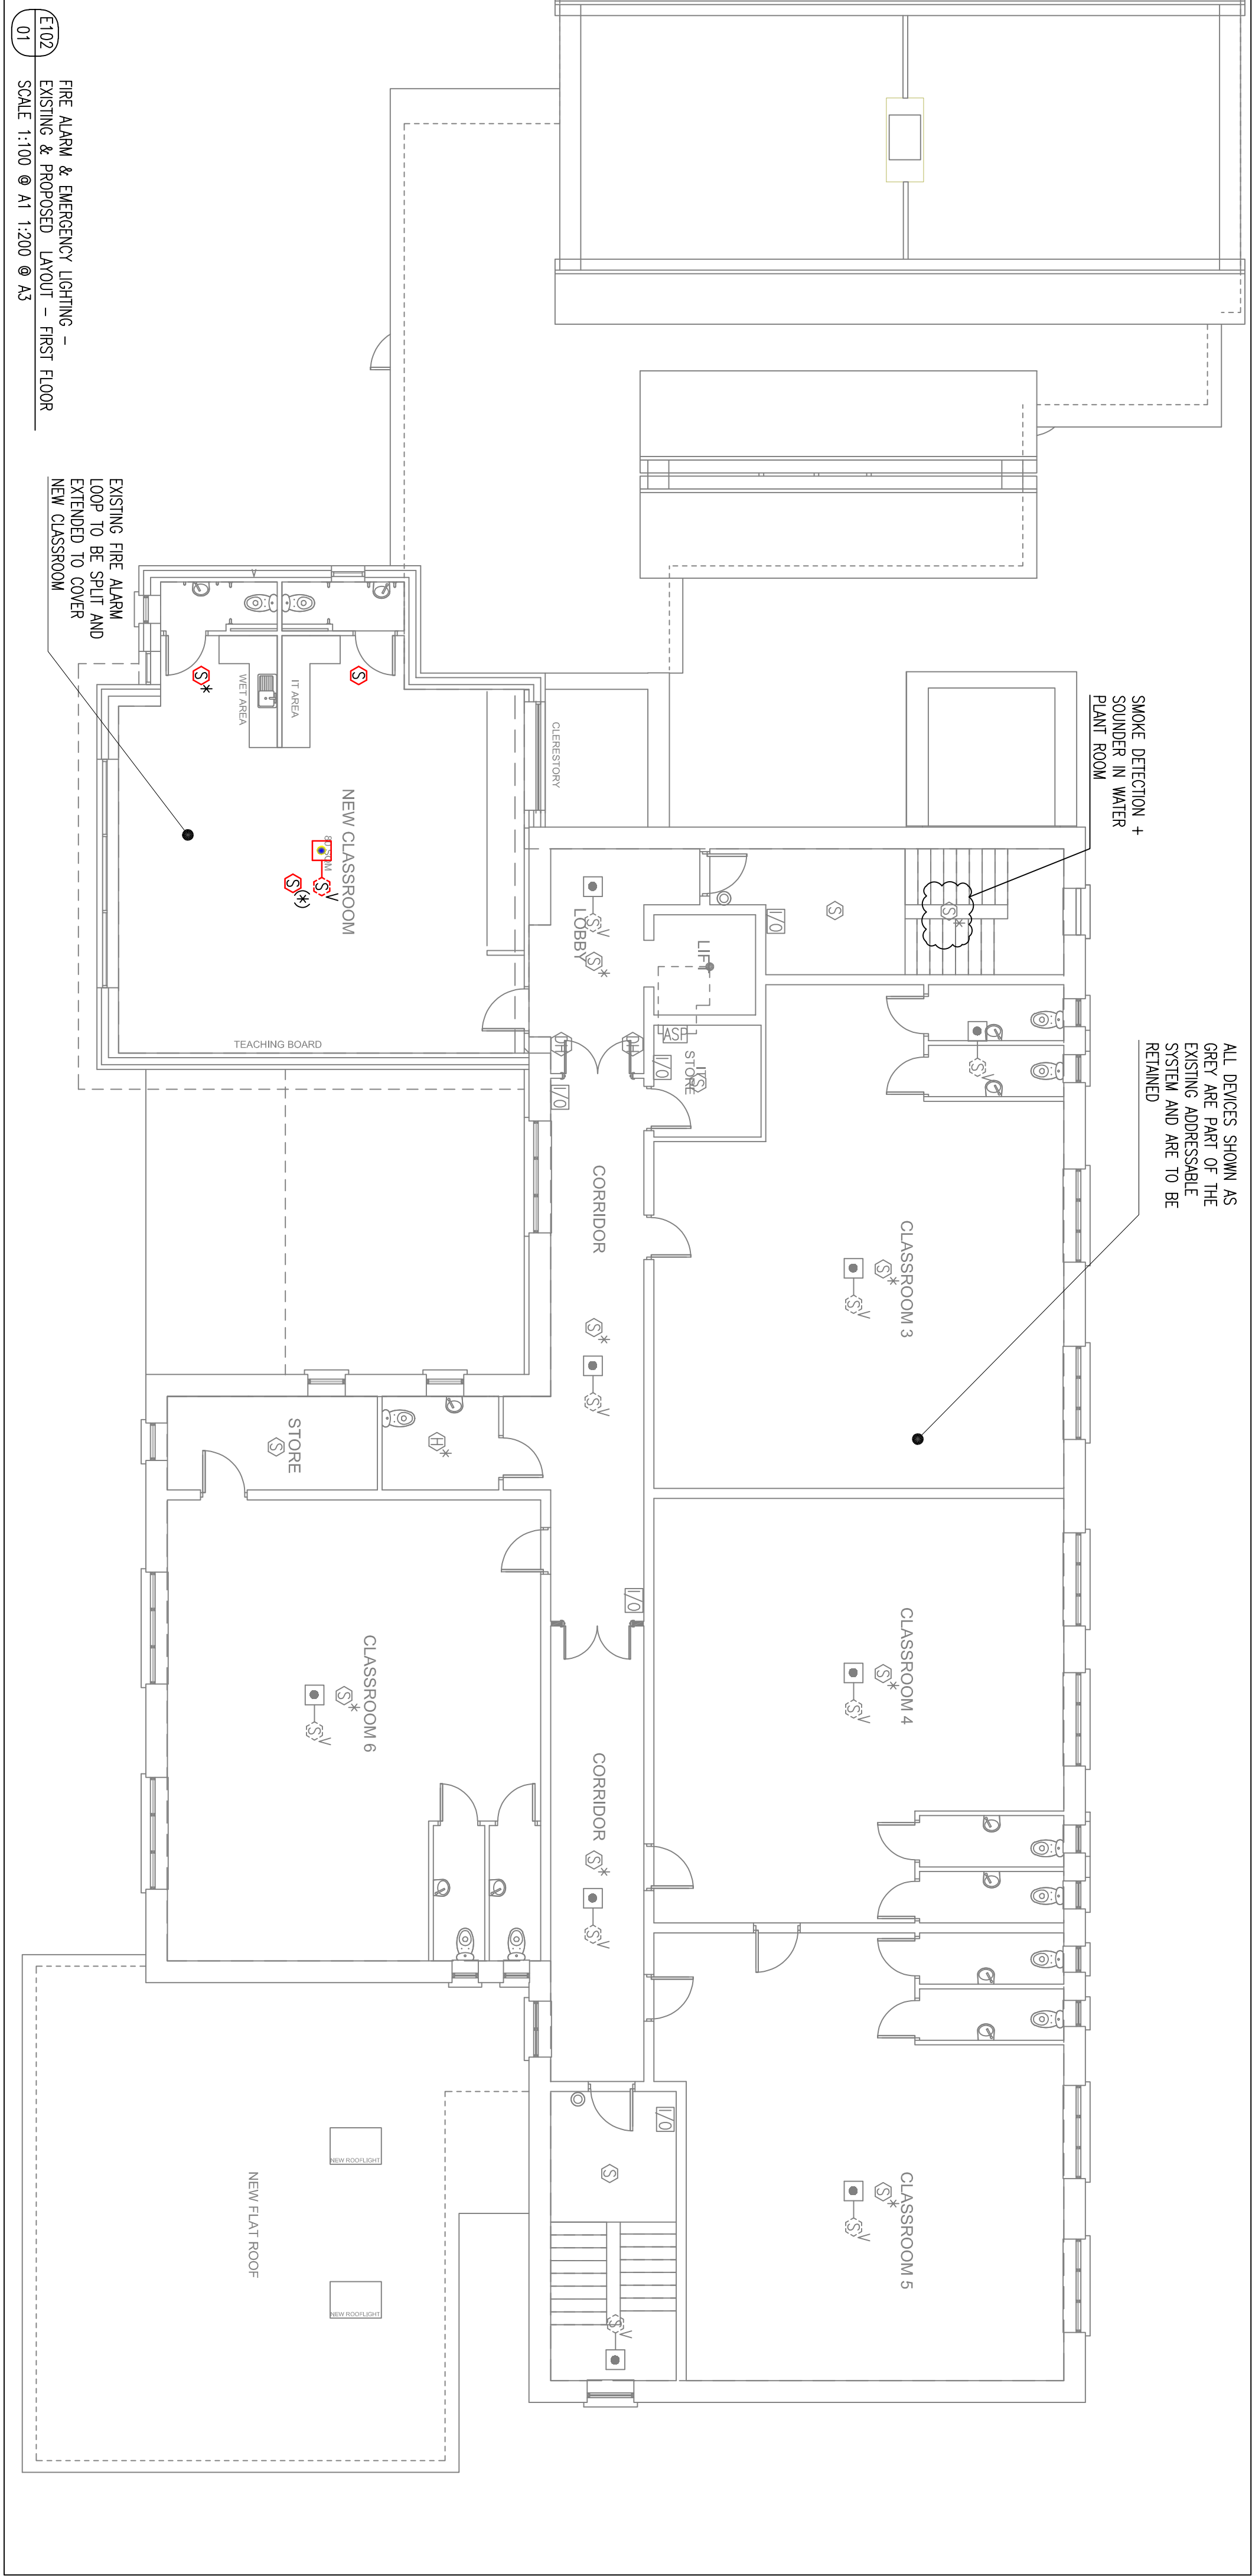

E102 FIRE ALARM & EMERGENCY LIGHTING – EXISTING & PROPOSED LAYOUT – FIRST FLOOR
01 SCALE 1:100 @ A1 1:200 @ A3

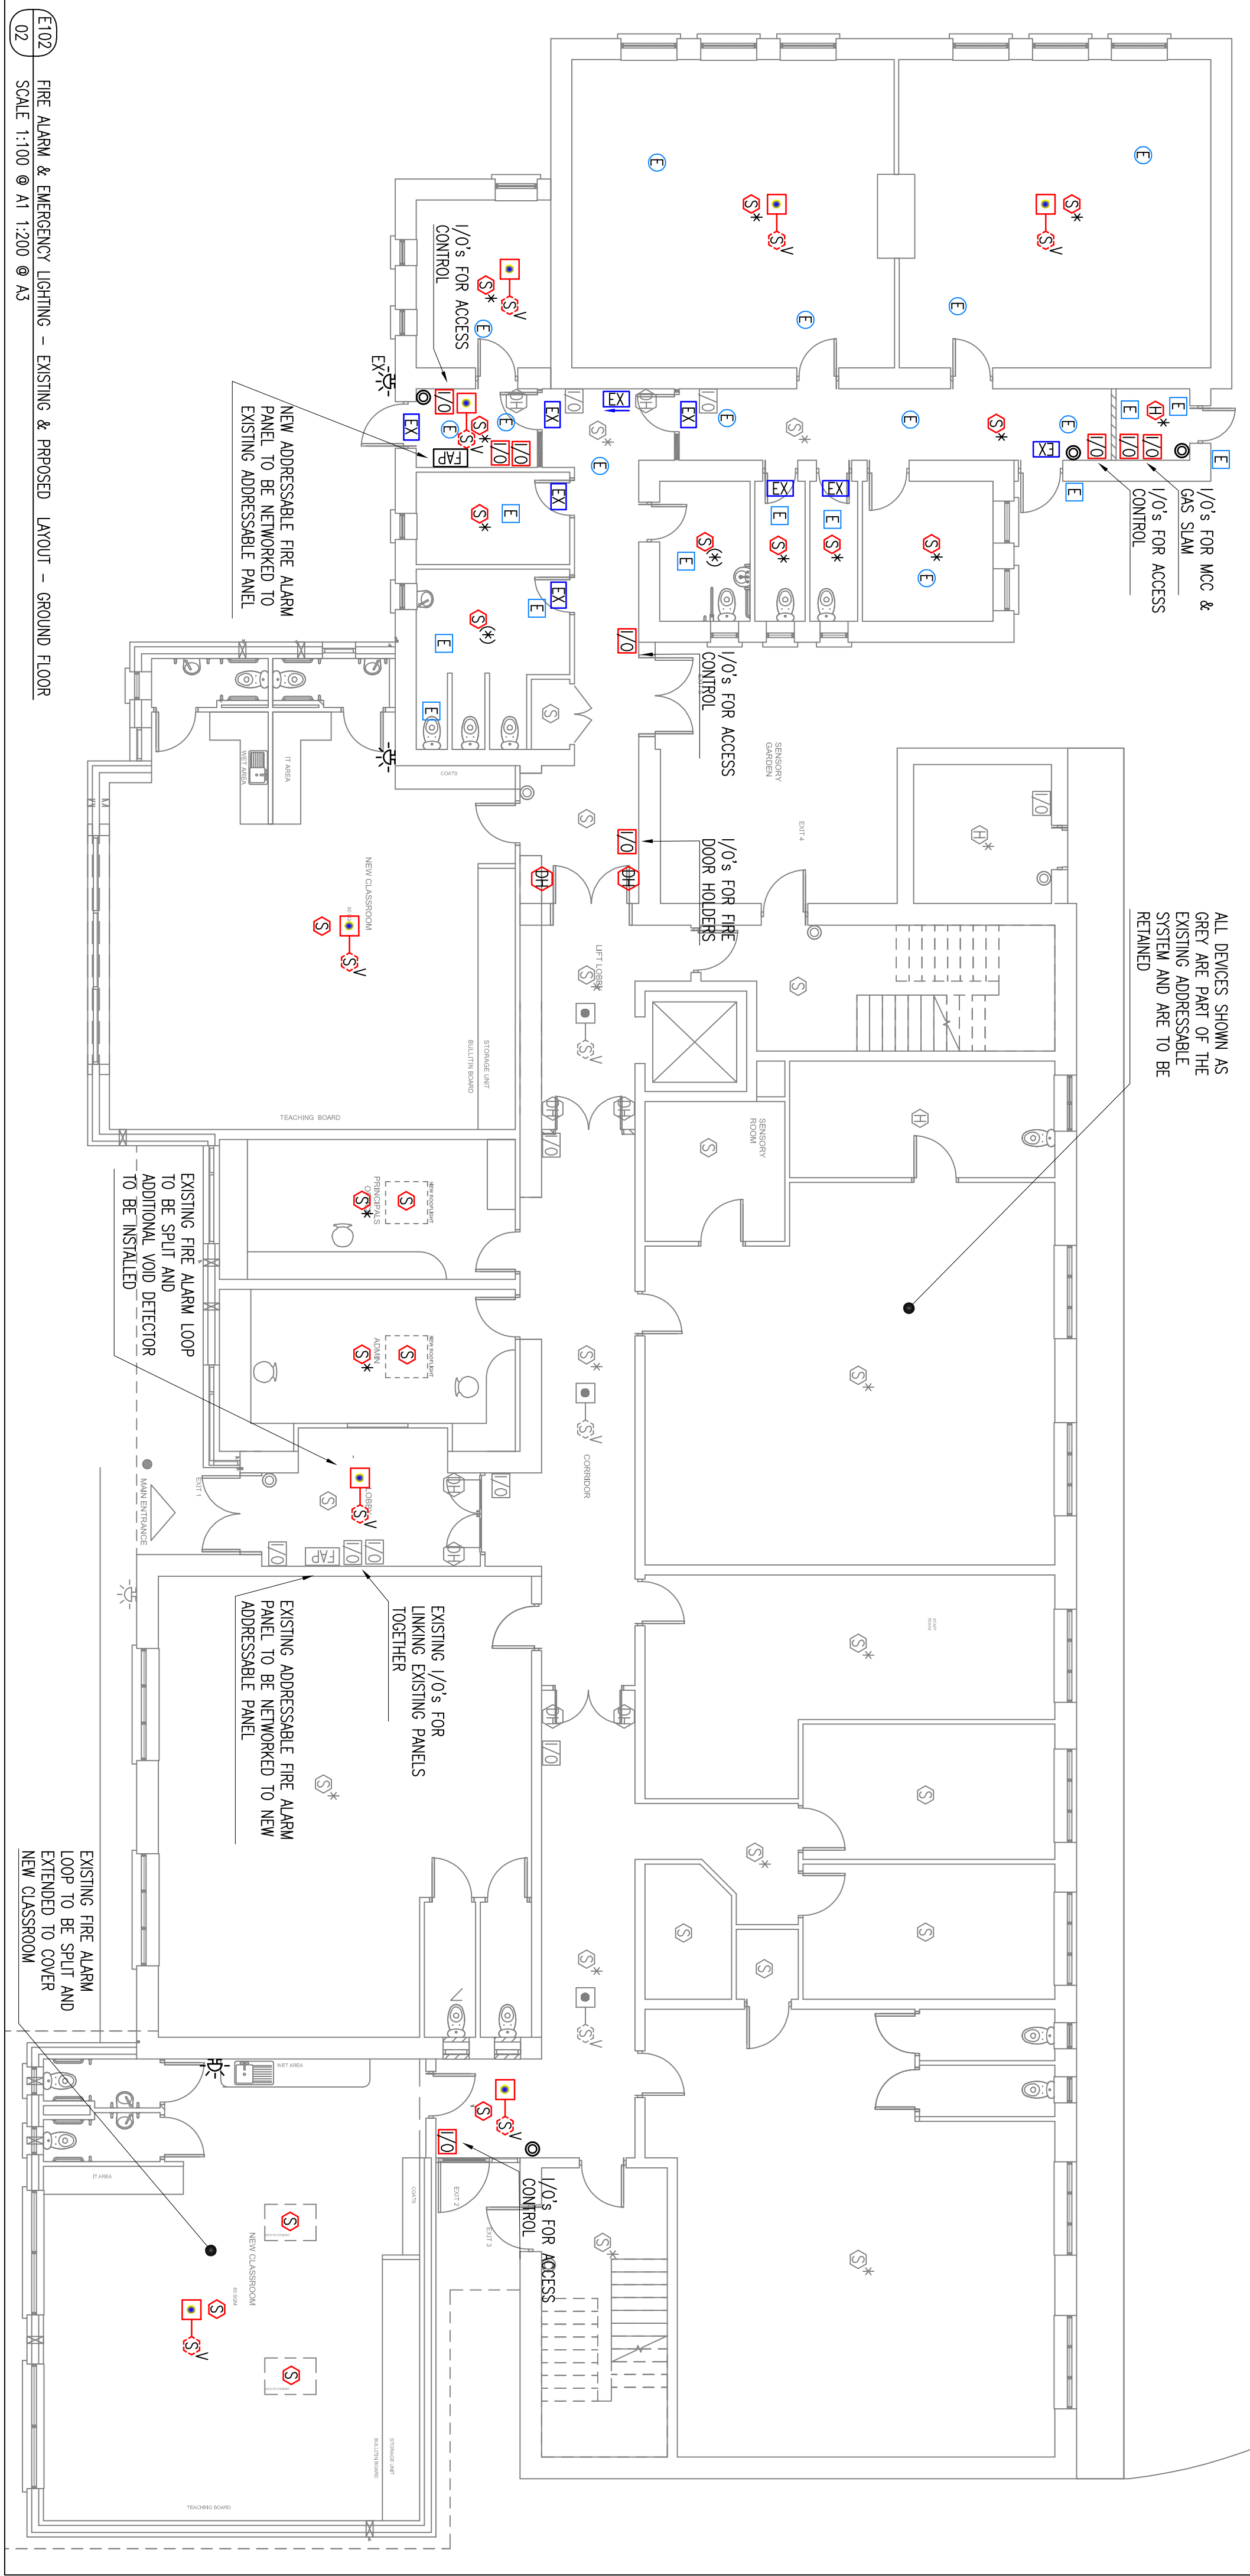

E102 FIRE ALARM & EMERGENCY LIGHTING – EXISTING & PROPOSED LAYOUT – GROUND FLOOR
02 SCALE 1:100 @ A1 1:200 @ A3

