
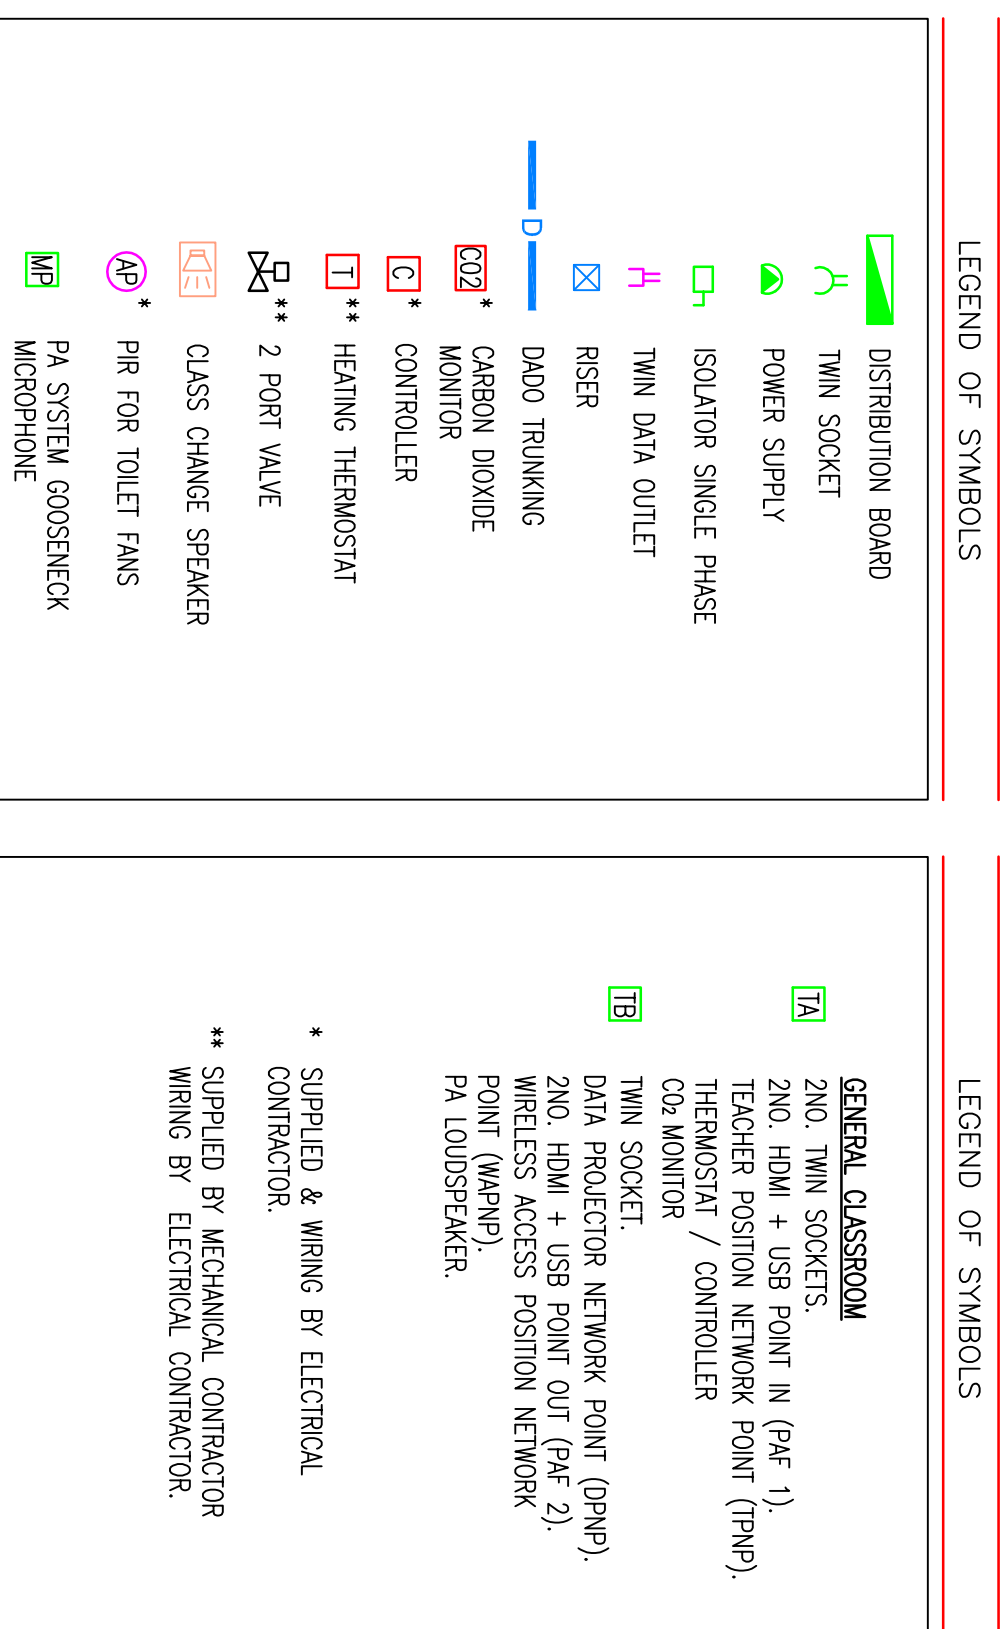
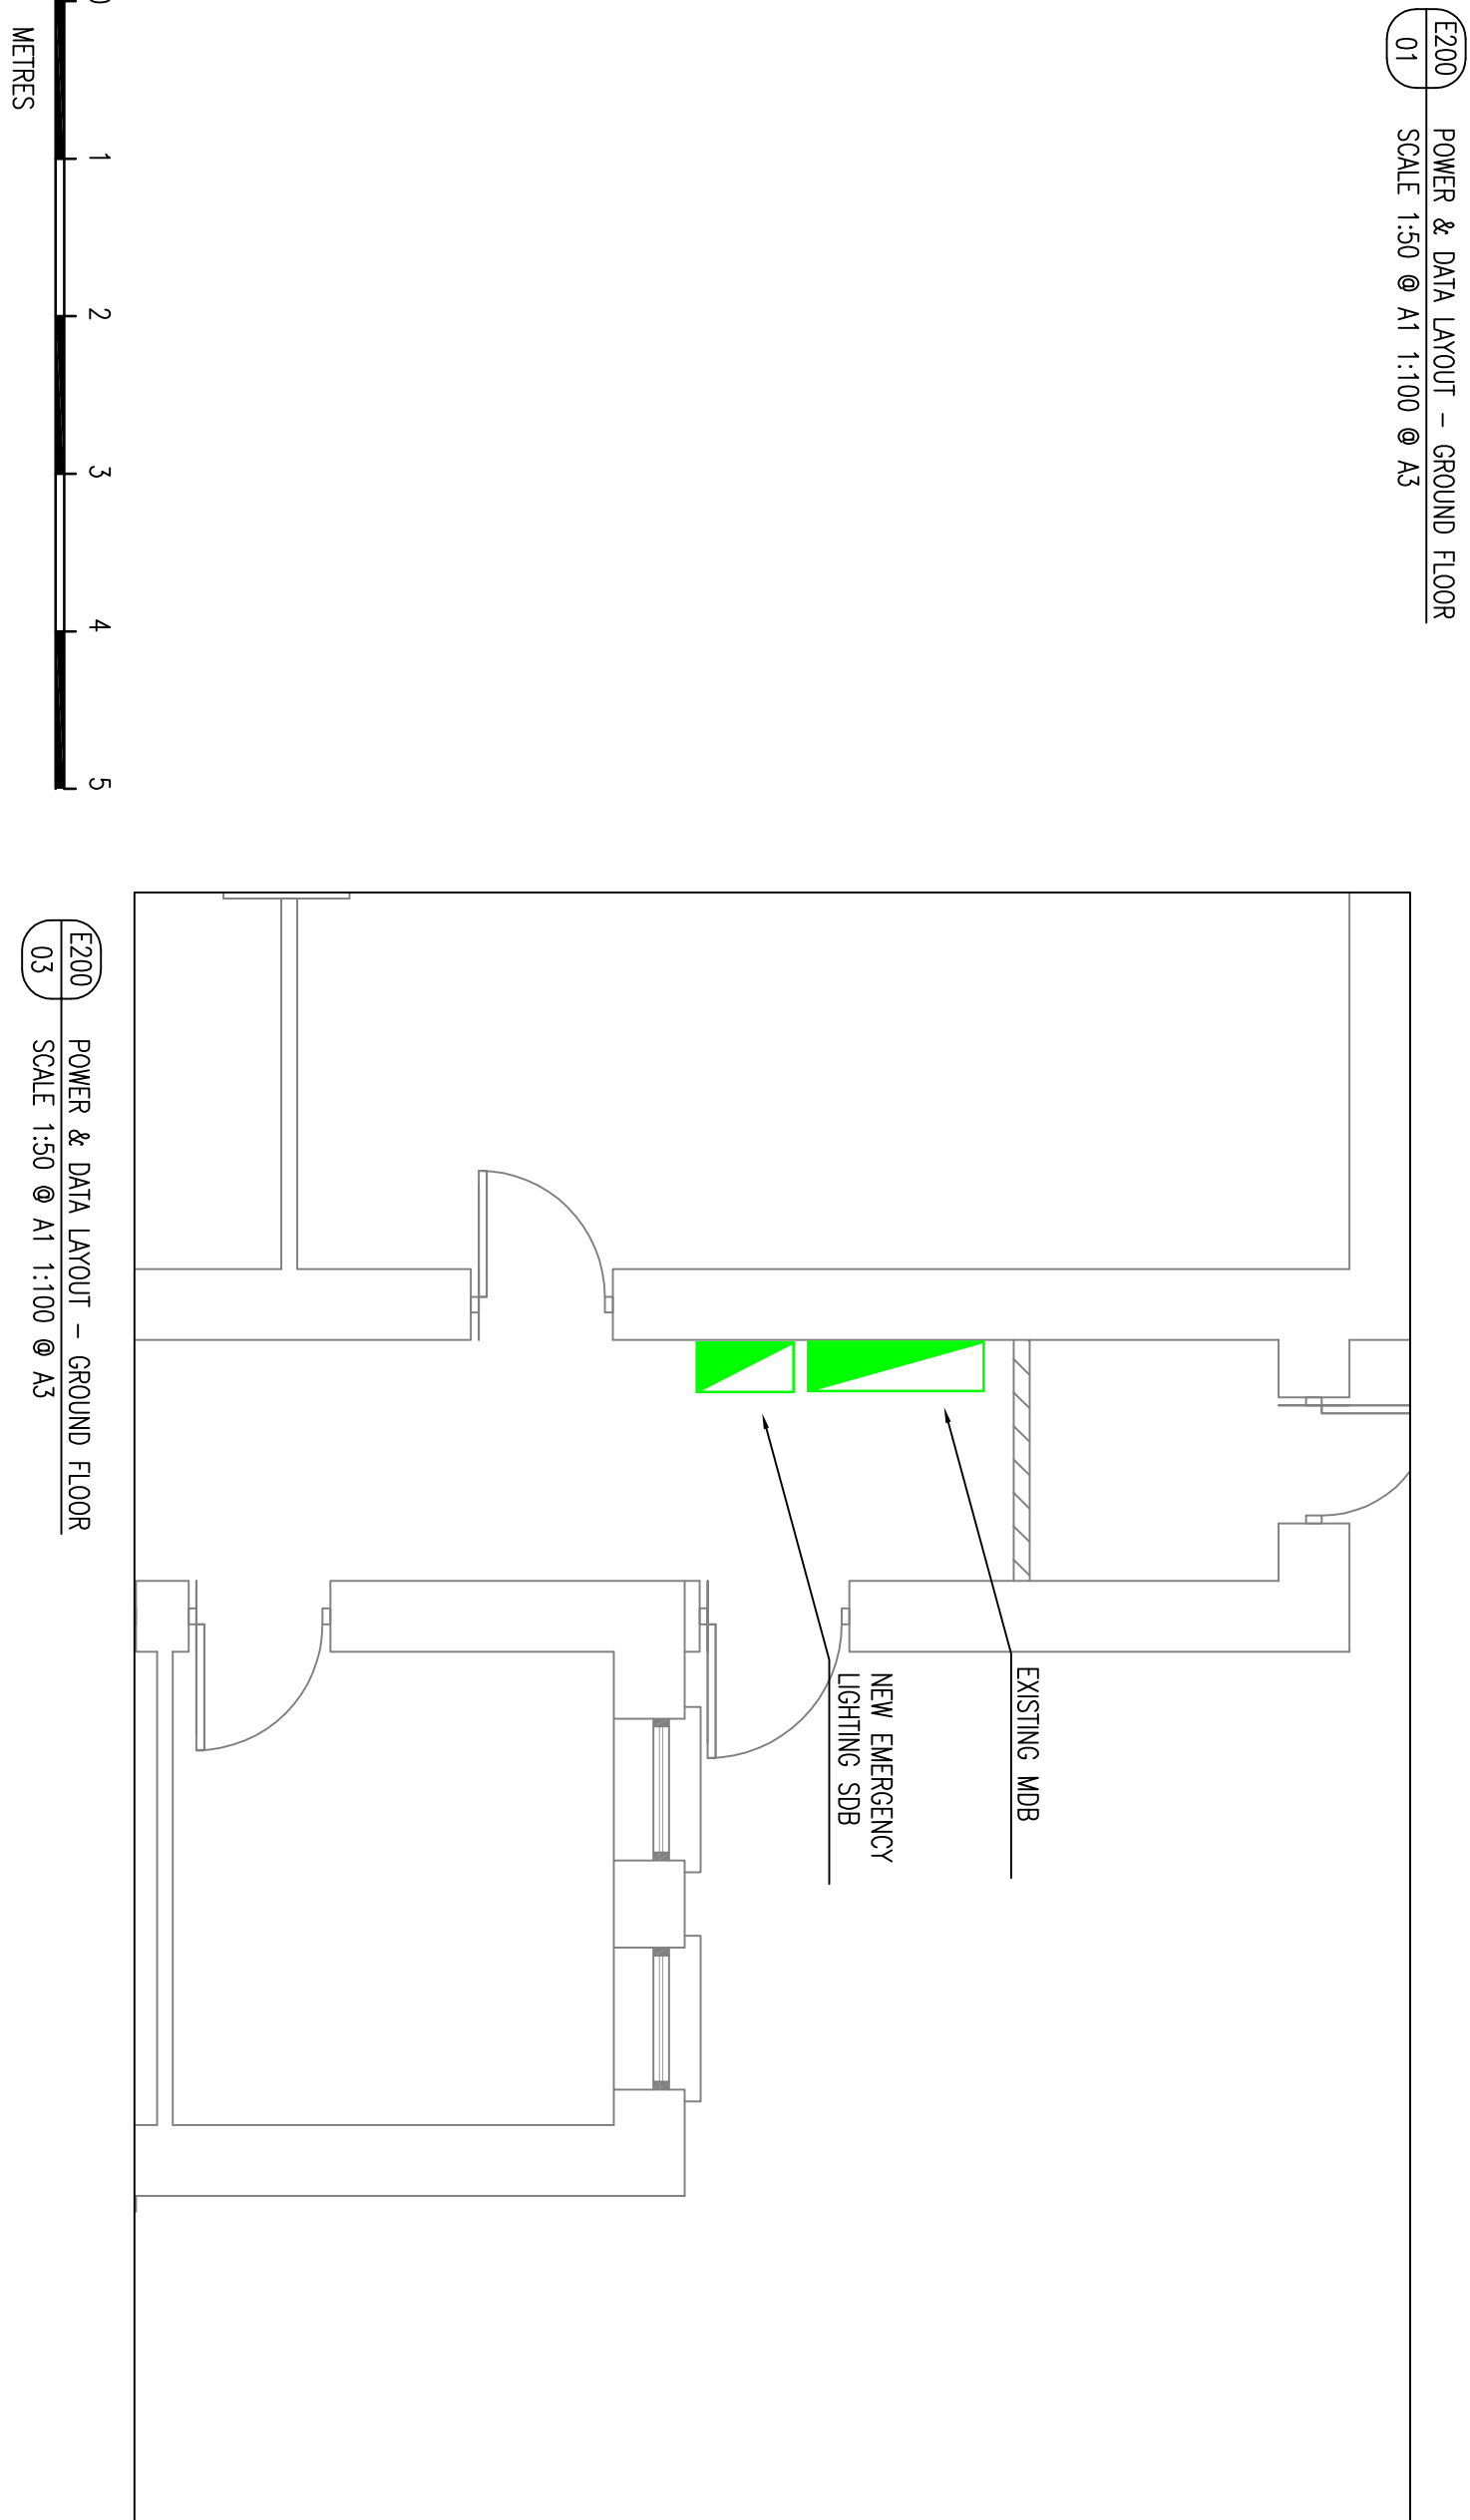
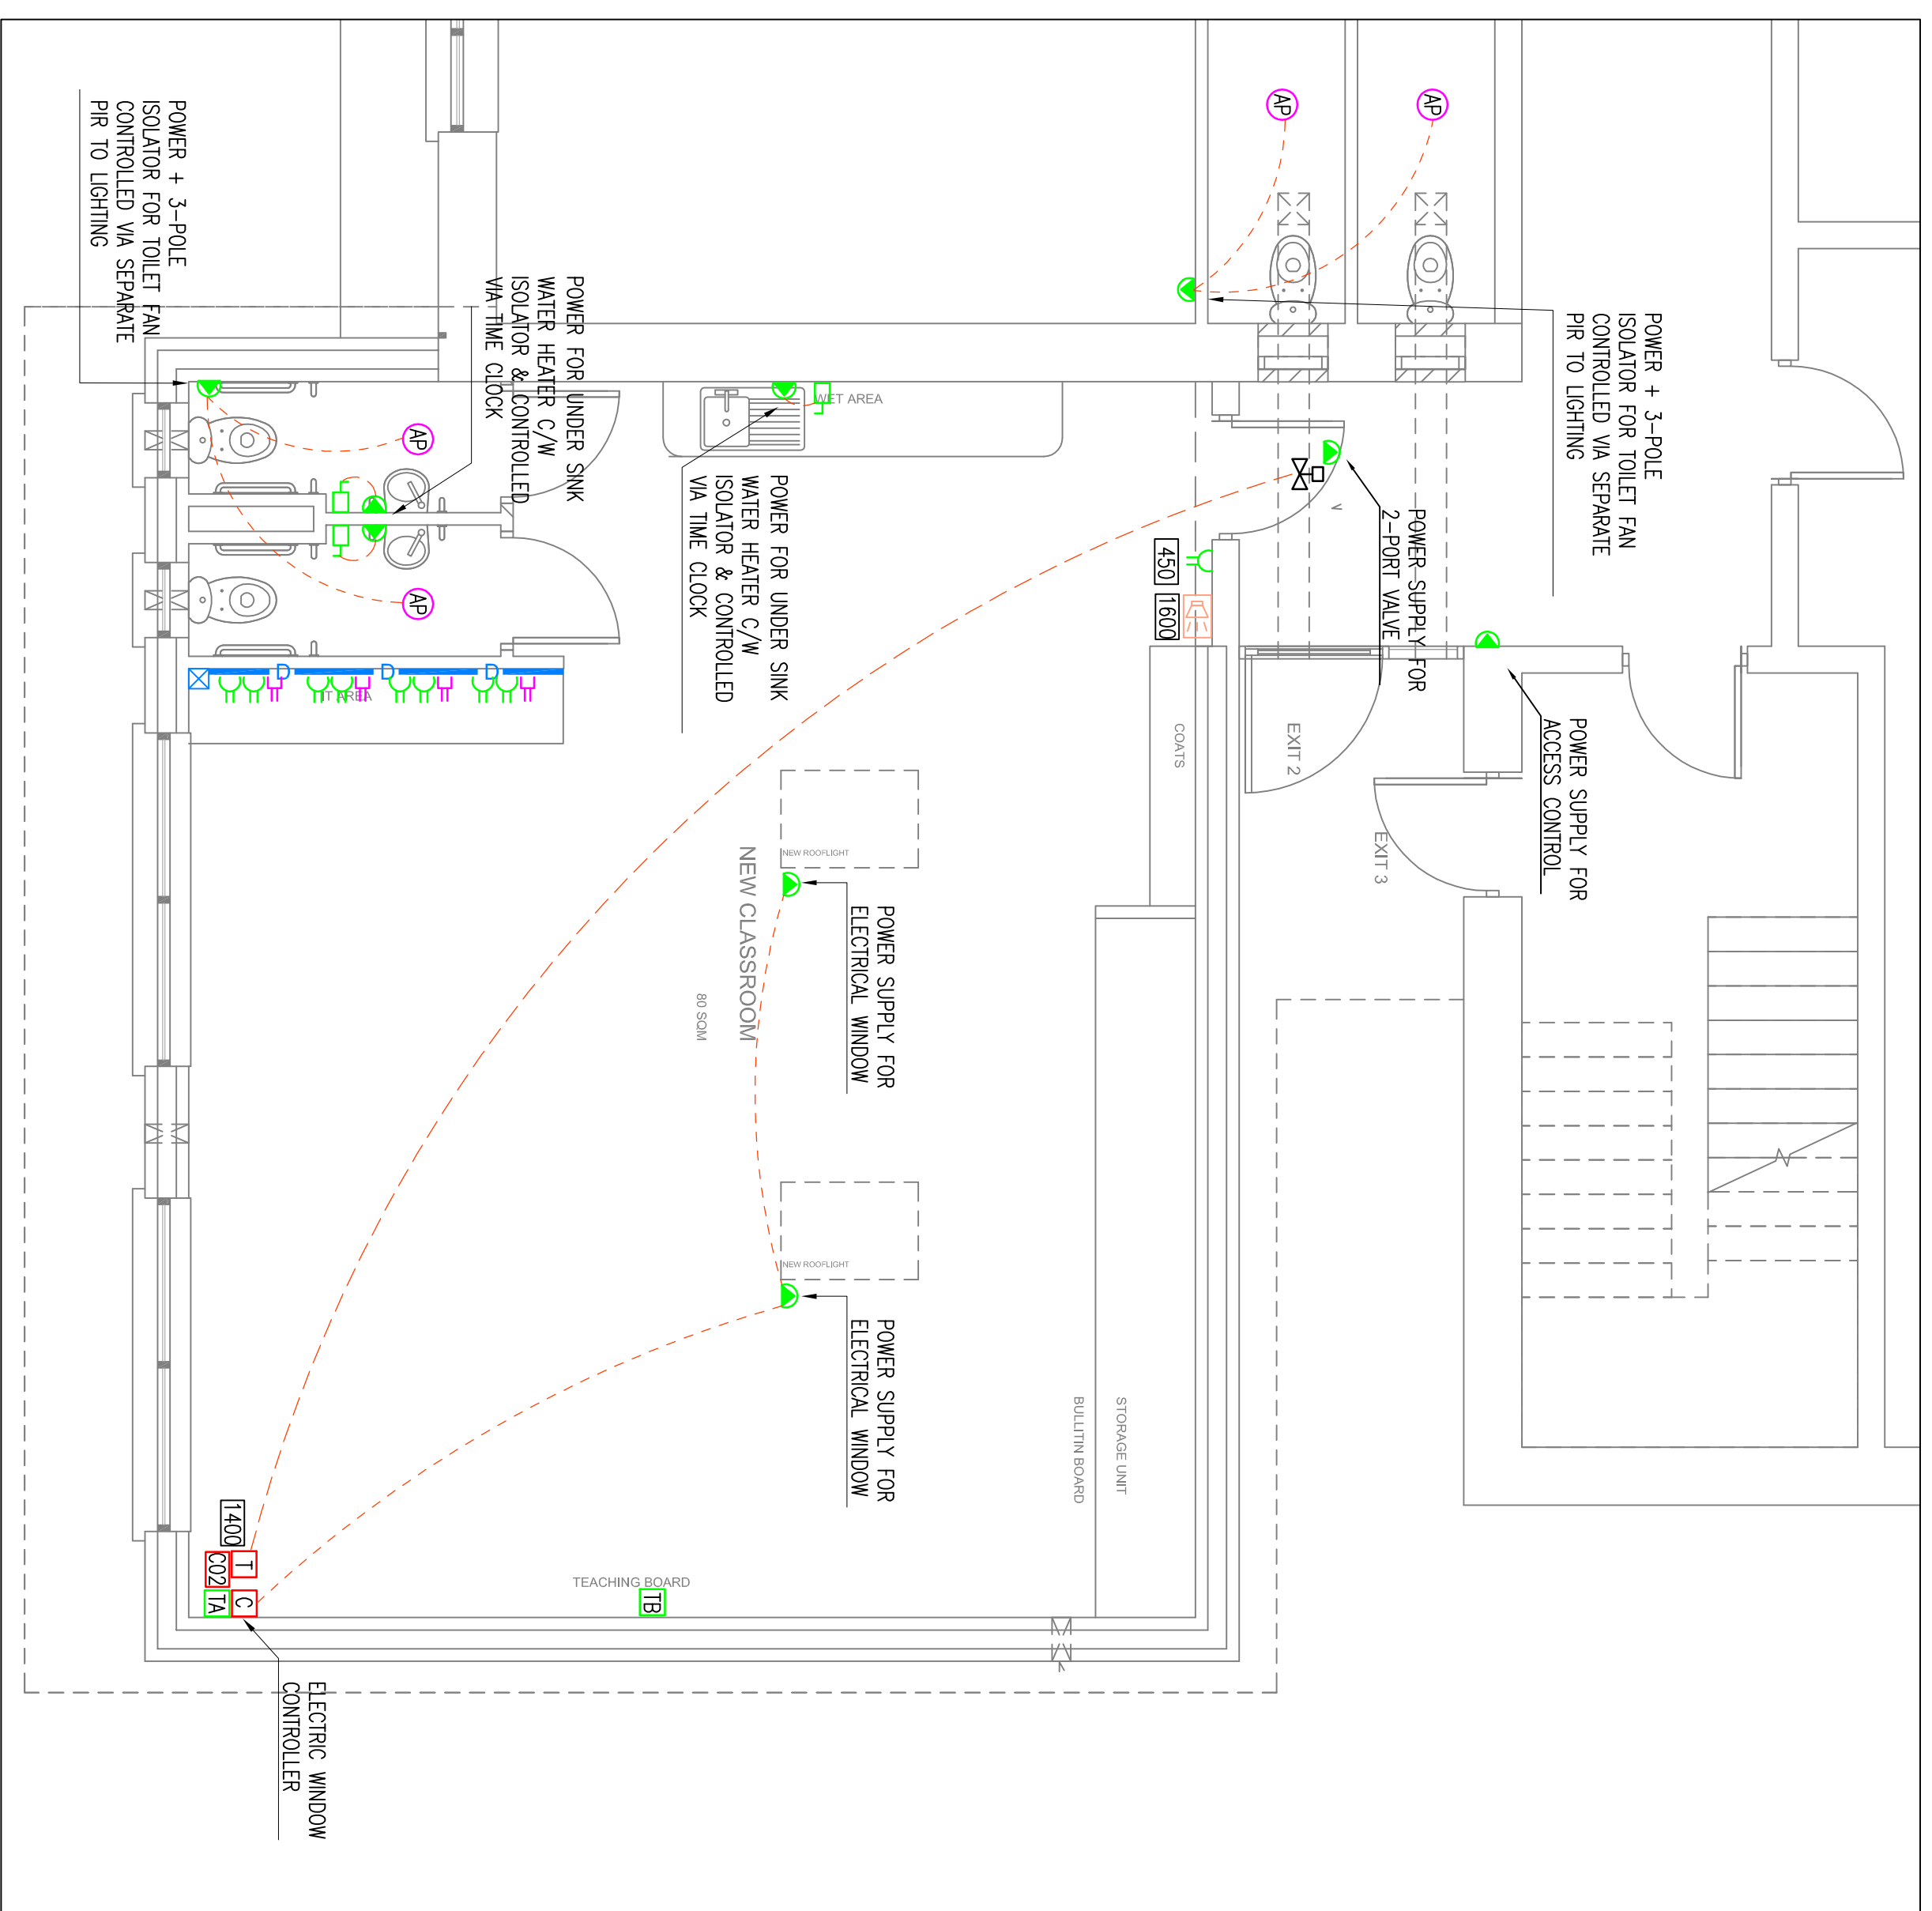


1. THIS DRAWING SHALL BE READ IN CONJUNCTION WITH THE SPECIFICATION AND ALL OTHER RELEVANT DRAWINGS.
2. THIS DRAWING MUST NOT BE SEALED FOR INSTALLATION PURPOSES, WORK TO FOURED AND SITE OBTAINED DIMENSION ONLY.
3. THE ELECTRICAL SERVICES CONTRACTOR IS FULLY RESPONSIBLE FOR ALL ON-SITE CO-ORDINATION OF HIS AND ALL OTHER SERVICES.

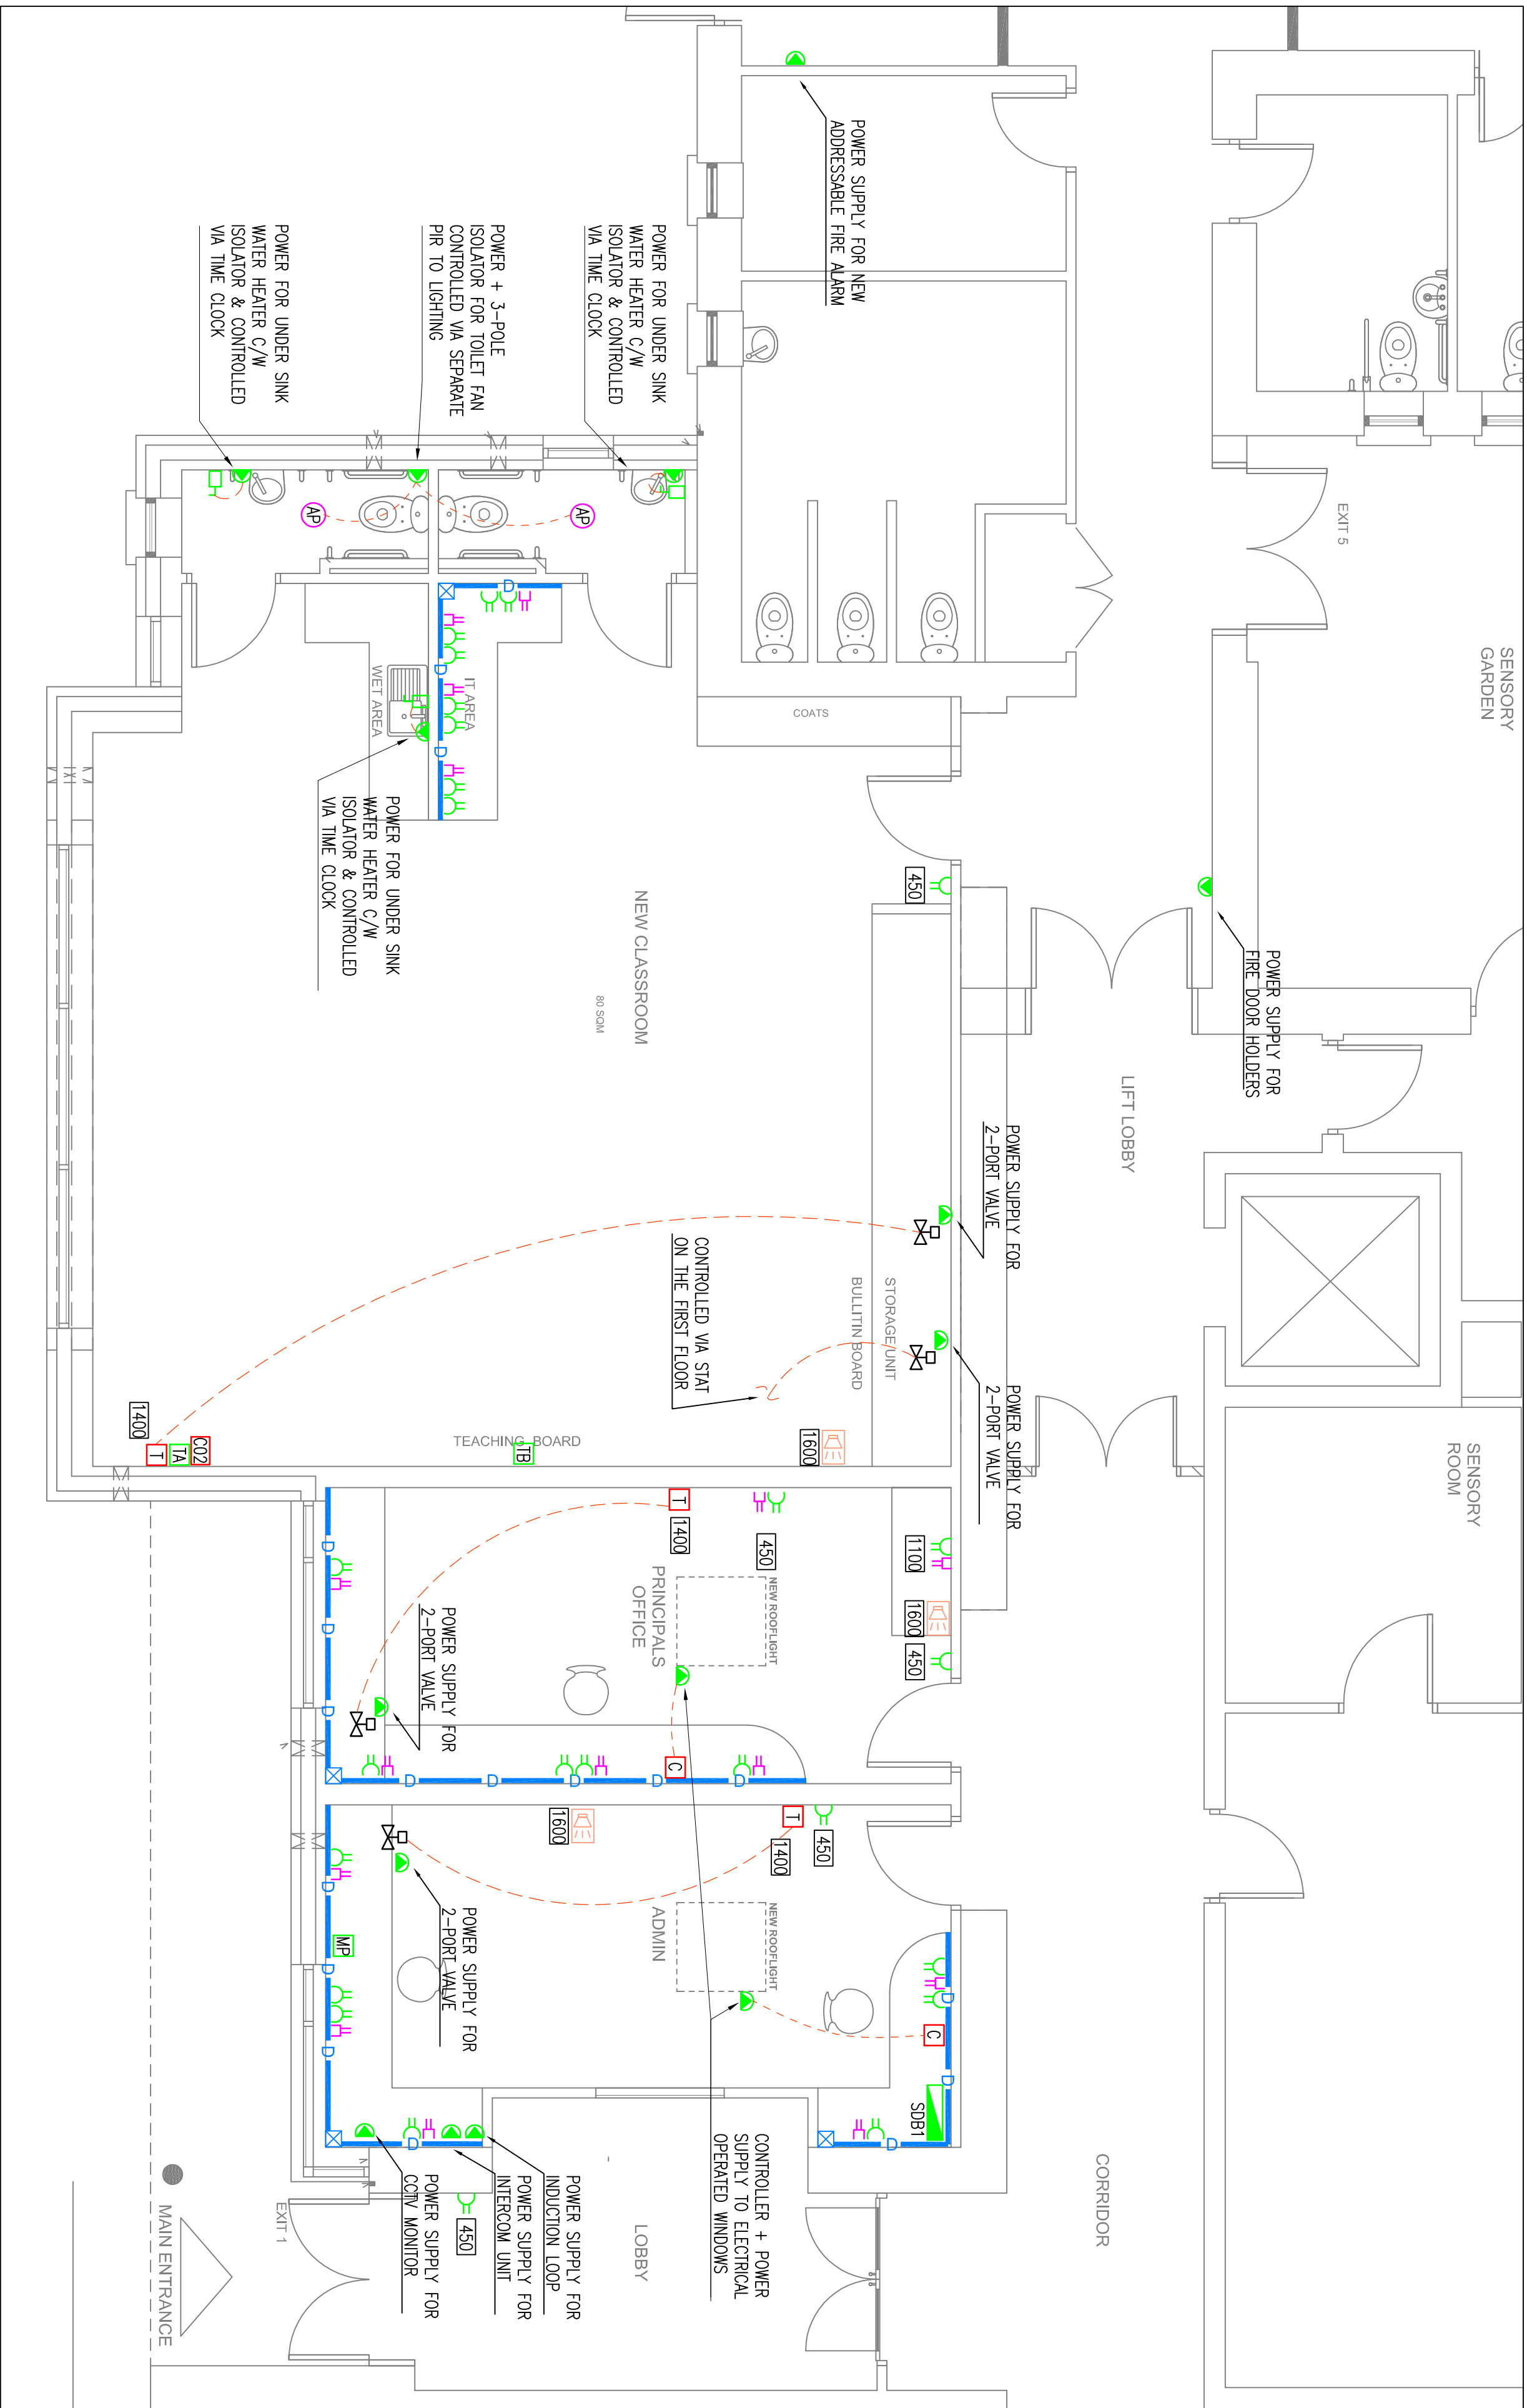

TO	ISSUE FOR TENDER	19.08.26	CR
Revisions		Date	Checked
 COLMAN RENOLDS ASSOCIATES Building Services Engineers and Project Managers Unit 9, Colburn Cross Business Park, Dogpaddell Way, Leighton Buzzard, Luton, Bedfordshire, LU3 1JH Tel: 01525 335311 Fax: 01525 335312 Email: info@cra.co.uk			
Project	COLLOONEY NS, SLIGO		
Drawing Title	POWER & DATA LAYOUT GROUND FLOOR		
Date	Drawn	Checked	Scale
07.07.26	PH	CR	1:50 @ A1 1:100 @ A3
Project No.	Drawing No.		Rev.
A1172	E200		TO