


GENERAL NOTES

1. THIS DRAWING SHALL BE READ IN CONJUNCTION WITH THE SPECIFICATION AND ALL OTHER RELEVANT DRAWINGS.
2. THIS DRAWING MUST NOT BE SCALED FOR INSTALLATION PURPOSES. WORK TO FIGURED AND SITE OBTAINED DIMENSION ONLY.
3. THE ELECTRICAL SERVICES CONTRACTOR IS FULLY RESPONSIBLE FOR ALL ON-SITE CO-ORDINATION OF HIS AND ALL OTHER SERVICES.

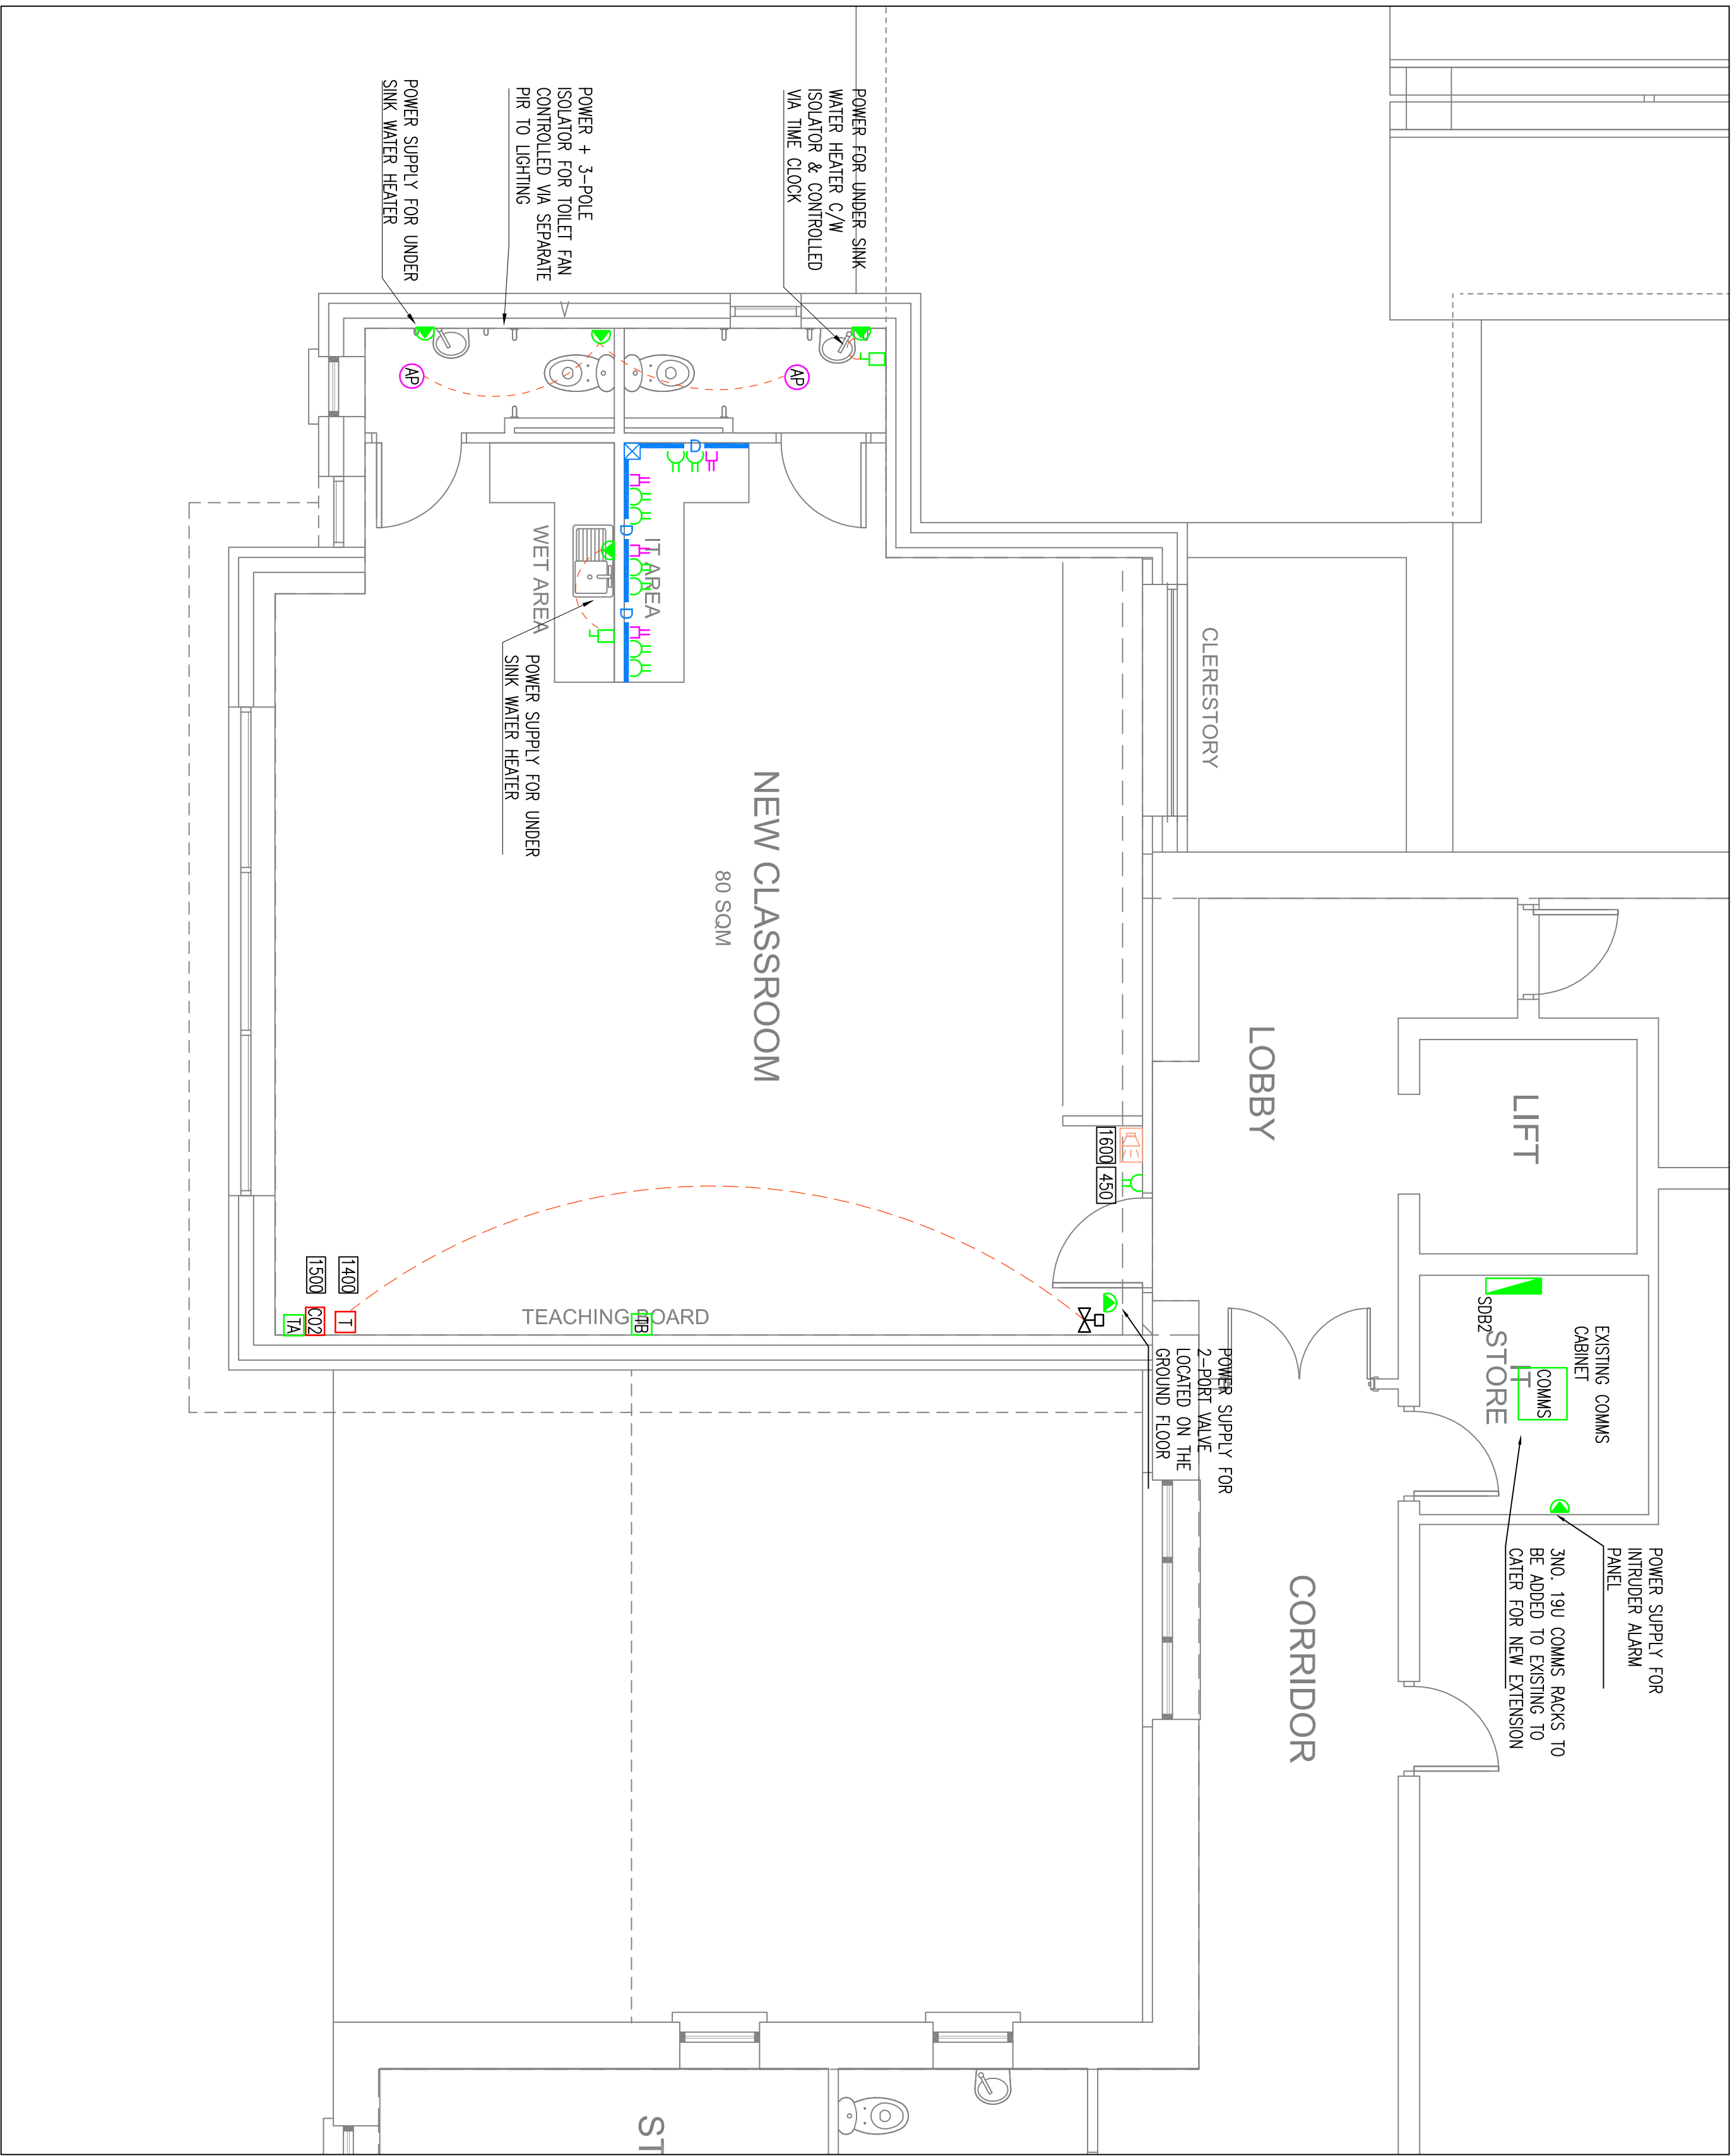

E201 POWER & DATA LAYOUT - FIRST FLOOR
01 SCALE 1:50 @ A1 1:100 @ A3


LEGEND OF SYMBOLS

- DISTRIBUTION BOARD
- TWIN SOCKET
- POWER SUPPLY
- ISOLATOR SINGLE PHASE
- TWIN DATA OUTLET
- RISER
- DATA TRUNKING
- CARBON DIOXIDE MONITOR
- CONTROL
- HEATING THERMOSTAT
- 2 PORT VALVE
- CLASS CHANGE SPEAKER
- PIR FOR TOILET FANS

LEGEND OF SYMBOLS

- GENERAL CLASSROOM
2NO. TWIN SOCKETS.
2NO. HDMI + USB POINT IN (PAF 1).
TEACHER POSITION NETWORK POINT (TPNP).
THERMOSTAT / CONTROLLER
CCTV MONITOR.
- TWIN SOCKET.
DATA PROJECTOR NETWORK POINT (DPNP).
2NO. HDMI + USB POINT OUT (PAF 2).
WIRELESS ACCESS POSITION NETWORK POINT (WPNP).
PA LOUDSPEAKER.

* SUPPLIED & WIRING BY ELECTRICAL CONTRACTOR.
** SUPPLIED BY MECHANICAL CONTRACTOR.
WIRING BY ELECTRICAL CONTRACTOR.

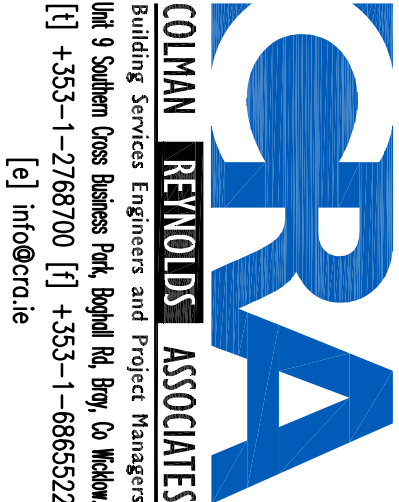

Project COLLOONEY NS, SLIGO

Drawing Title
POWER & DATA LAYOUT
FIRST FLOOR

Date	Drawn	PH	Checked	CR	Scale
07/07/26					1:50 @ A1 1:100 @ A3
Project No.	A1172		Drawing No.	E201	Rev.
					A

A	ISSUE FOR INFORMATION	??	CR
Revisions	Date	Checked	

