



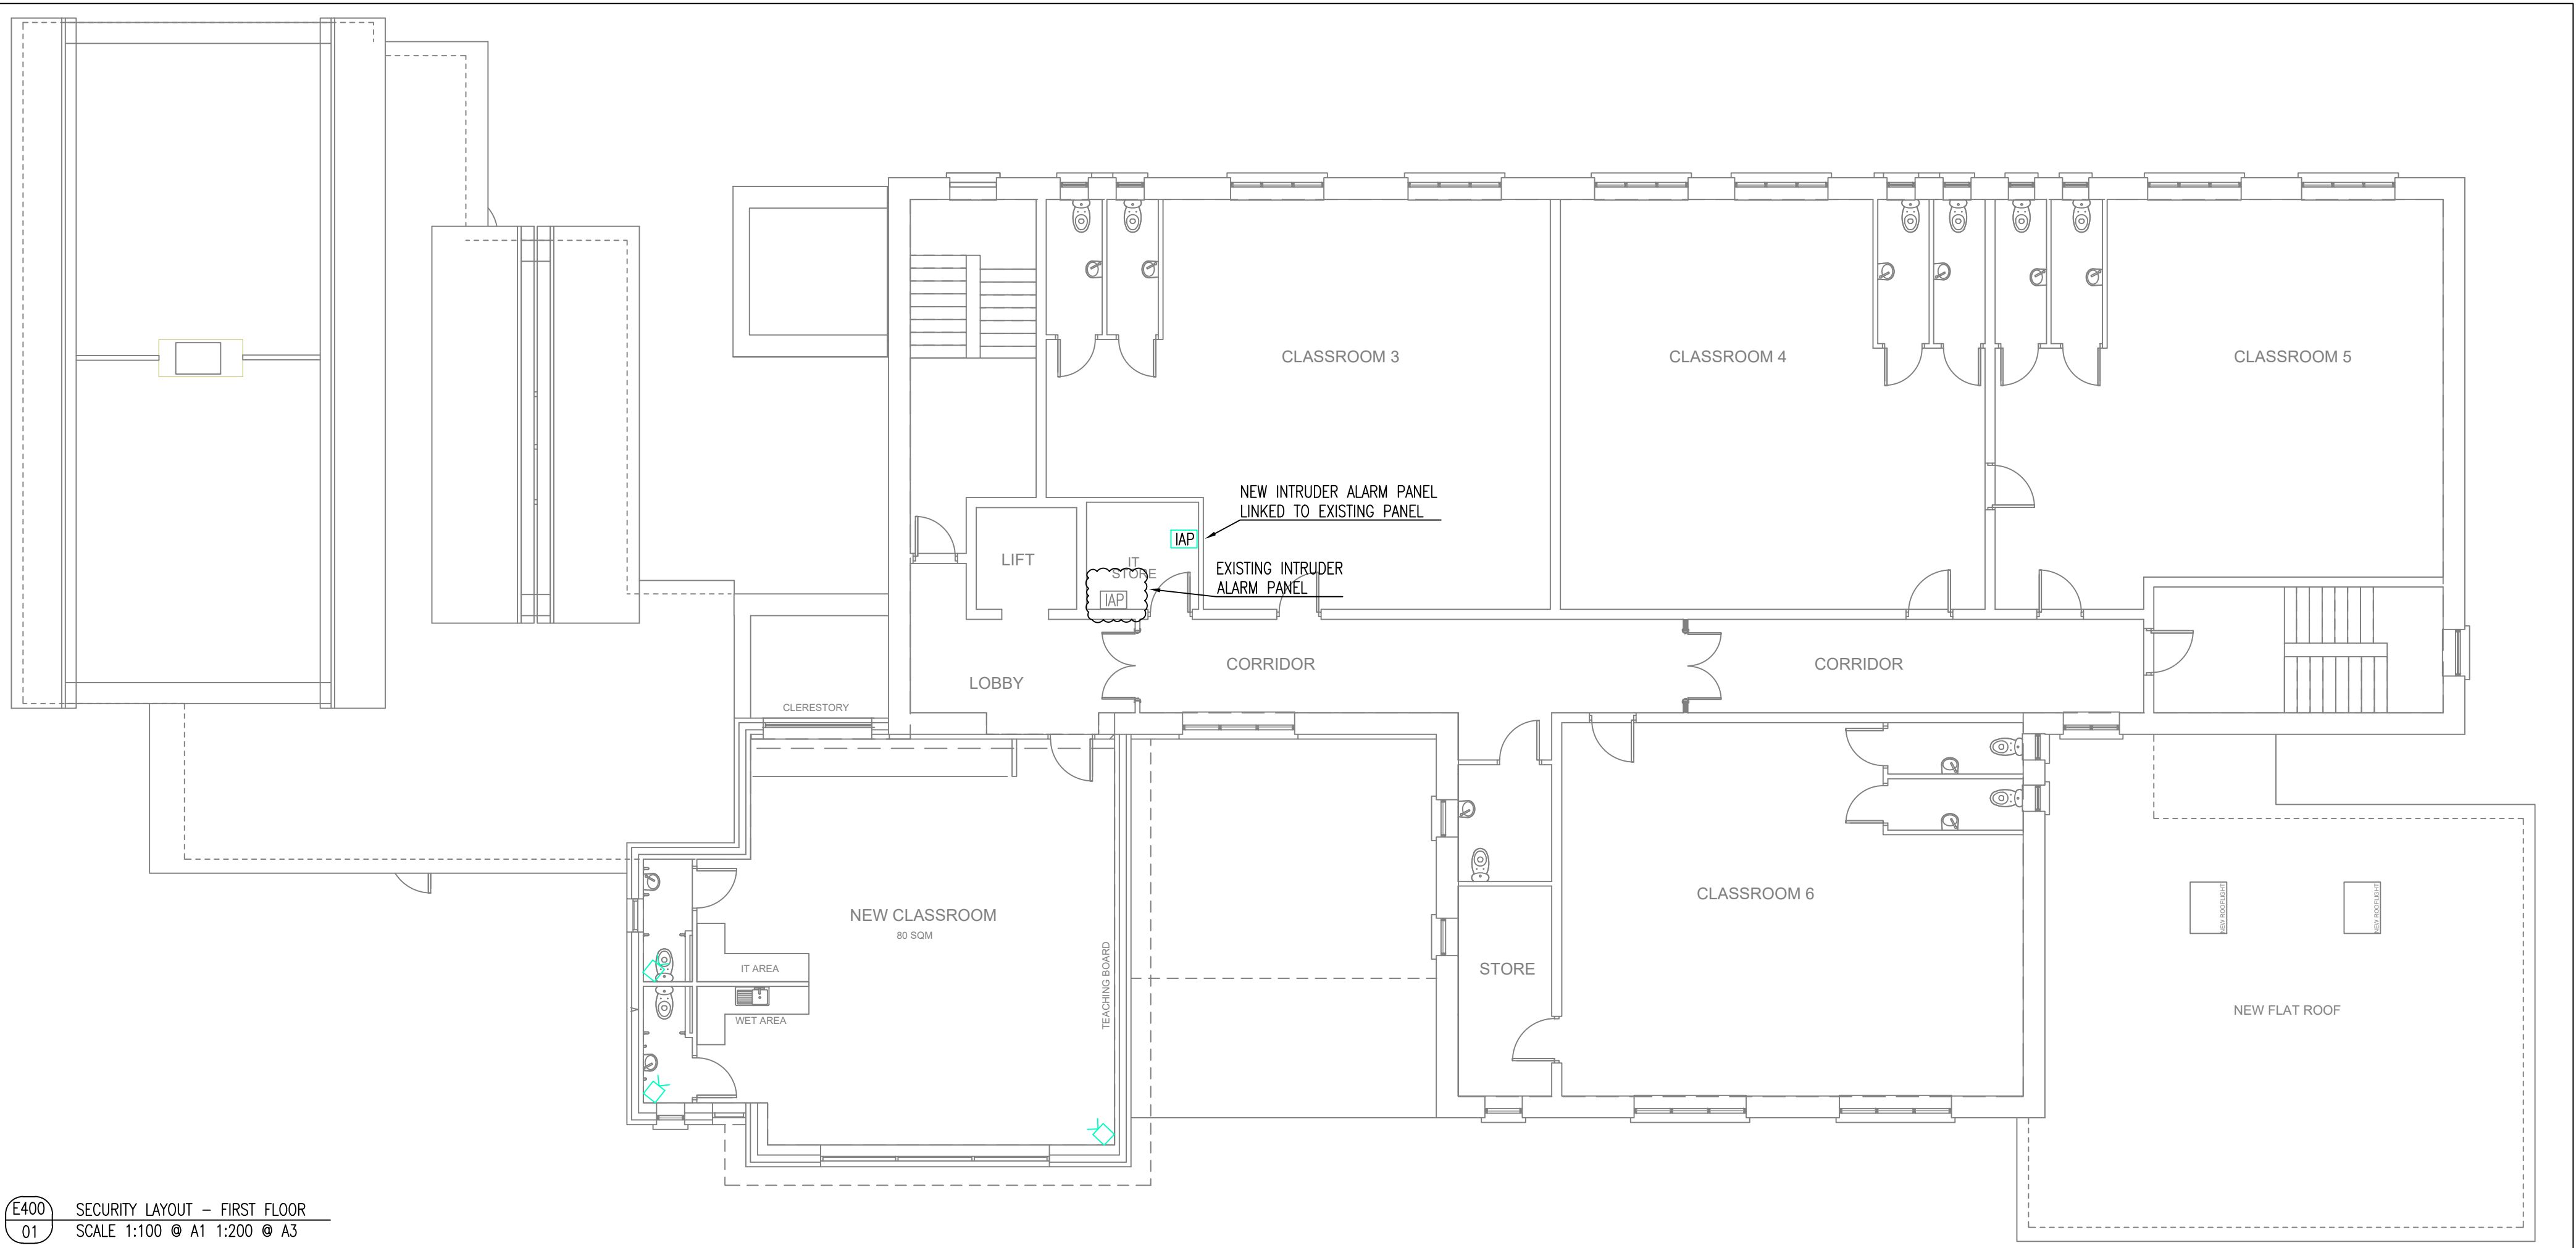

E400 SECURITY LAYOUT – FIRST FLOOR
01 SCALE 1:100 @ A1 1:200 @ A3

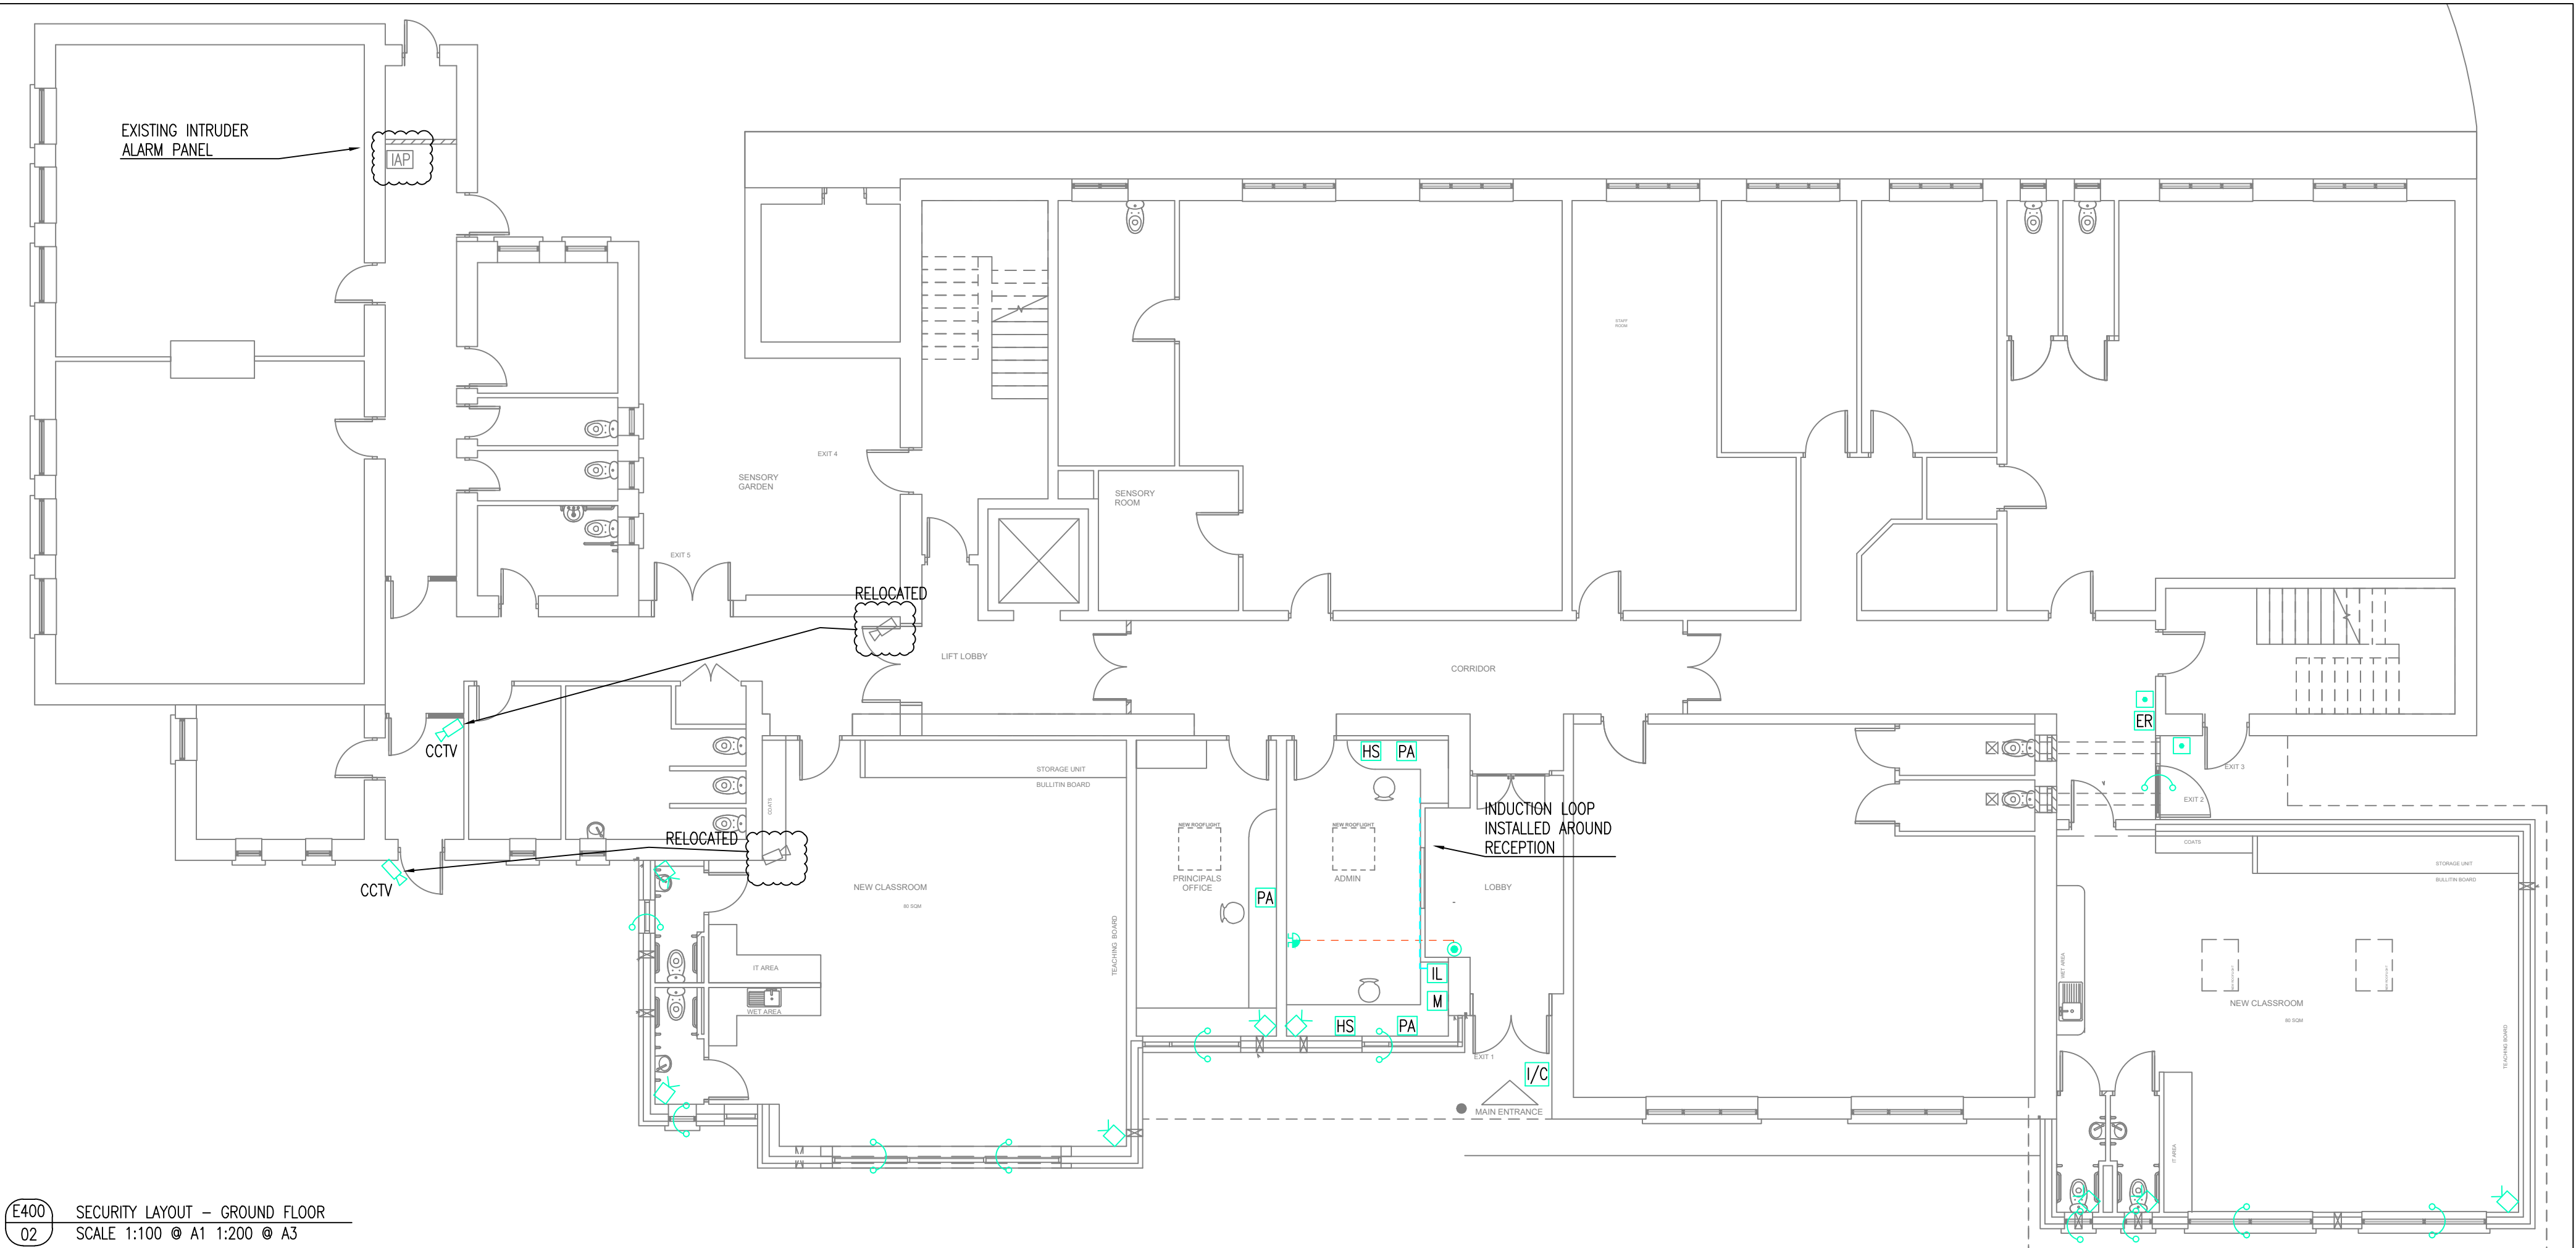

E400 SECURITY LAYOUT – GROUND FLOOR
02 SCALE 1:100 @ A1 1:200 @ A3

GENERAL NOTES	
1.	THIS DRAWING SHALL BE READ IN CONJUNCTION WITH THE SPECIFICATION AND ALL OTHER RELEVANT DRAWINGS.
2.	THIS DRAWING MUST NOT BE SCALED FOR INSTALLATION PURPOSES. WORK TO FIGURED AND SITE OBTAINED DIMENSION ONLY.
3.	THE ELECTRICAL SERVICES CONTRACTOR IS FULLY RESPONSIBLE FOR ALL ON-SITE CO-ORDINATION OF HIS AND ALL OTHER SERVICES.
LEGEND OF SYMBOLS	
	INTRUDER ALARM PIR
	ALARM CONTACT
	EXISTING CCTV CAMERA RELOCATED
	EXISTING INTRUDER ALARM PANEL
	ELECTROMAGNETIC LOCK
	EMERGENCY RELEASE BUTTON
	REQUEST RELEASE BUTTON
	FOB READER
	INDUCTION LOOP COUNTER TOP TYPE
	DOOR CALL SOUNDER
	BELL PUSH BUTTON
	UNDER DESK PANIC ALARM BUTTON
	2 WAY EXTERNAL INTERCOM UNIT
	INTERCOM HANDSET WITH DOOR RELEASE
	MONITOR

TO ISSUE FOR TENDER		19.08.26	CR
Revisions		Date	Checked
Project COLLOONEY NS, SLIGO			
Drawing Title SECURITY LAYOUT GROUND & FIRST FLOOR			
Date 07.07.26	Drawn PH	Checked CR	Scale 1:100 @ A1 1:200 @ A3
Project No. A1172		Drawing No. E400	Rev. TO