



- GENERAL NOTES
- THIS DRAWING SHALL BE READ IN CONJUNCTION WITH THE SPECIFICATION AND ALL OTHER RELEVANT DRAWINGS.
 - THIS DRAWING MUST NOT BE SCALED FOR INSTALLATION PURPOSES. WORK TO FIGURED AND SITE OBTAINED DIMENSION ONLY.
 - THE ELECTRICAL SERVICES CONTRACTOR IS FULLY RESPONSIBLE FOR ALL ON-SITE CO-ORDINATION OF HIS AND ALL OTHER SERVICES.
 - PIR'S FOR FANS SUPPLIED BY ELECTRICAL CONTRACTOR

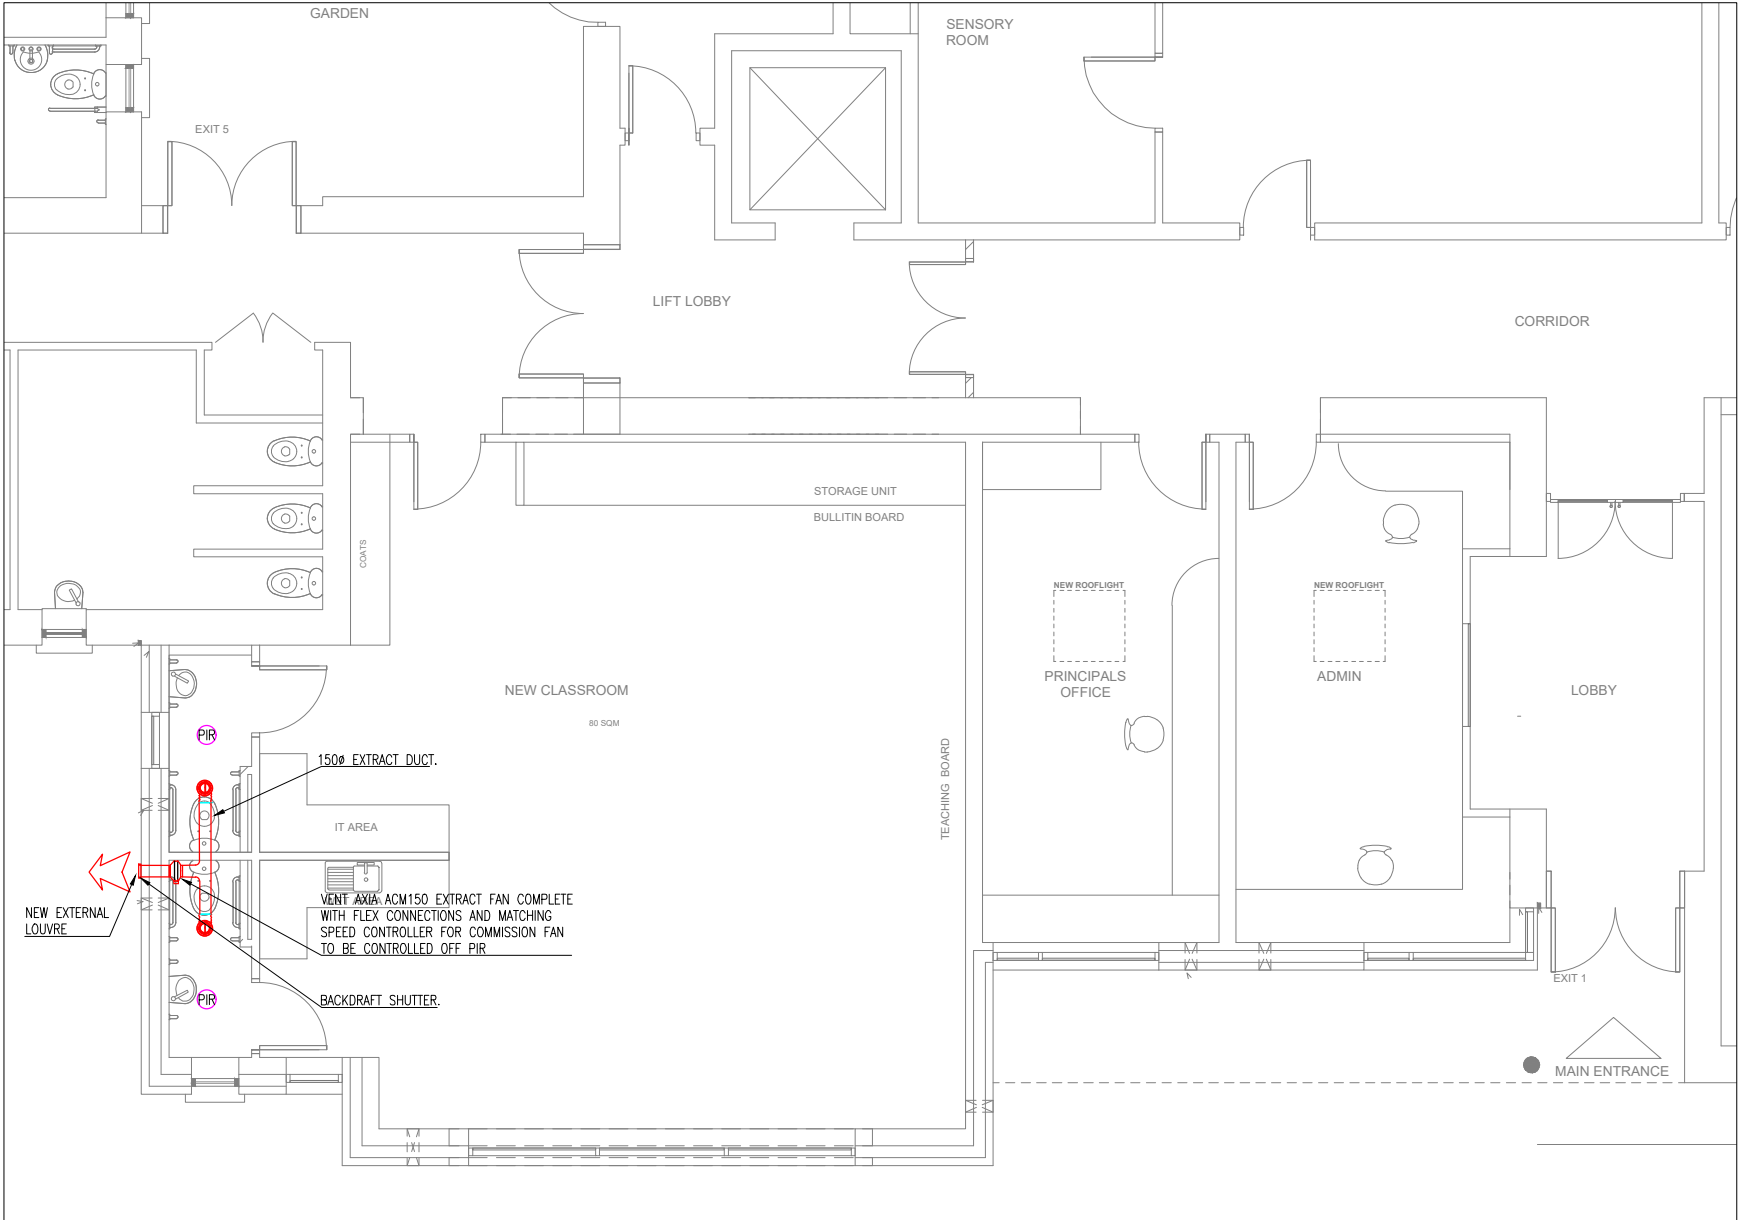

M200
01 VENTILATION LAYOUT – GROUND FLOOR
SCALE 1:50 @ A1 1:100 @ A3

REF	FLOW (L/s)	MODEL	NOTES
EF	15	QUIET EXTRACT FAN	1,2 & 3
1. LINKED TO LIGHT SWITCH			
2. WITH RUN-ON TIMER			
3. MAX SPECIFIC FAN POWER = 0.3 W/l/s			

M200
03 FAN SCHEDULE

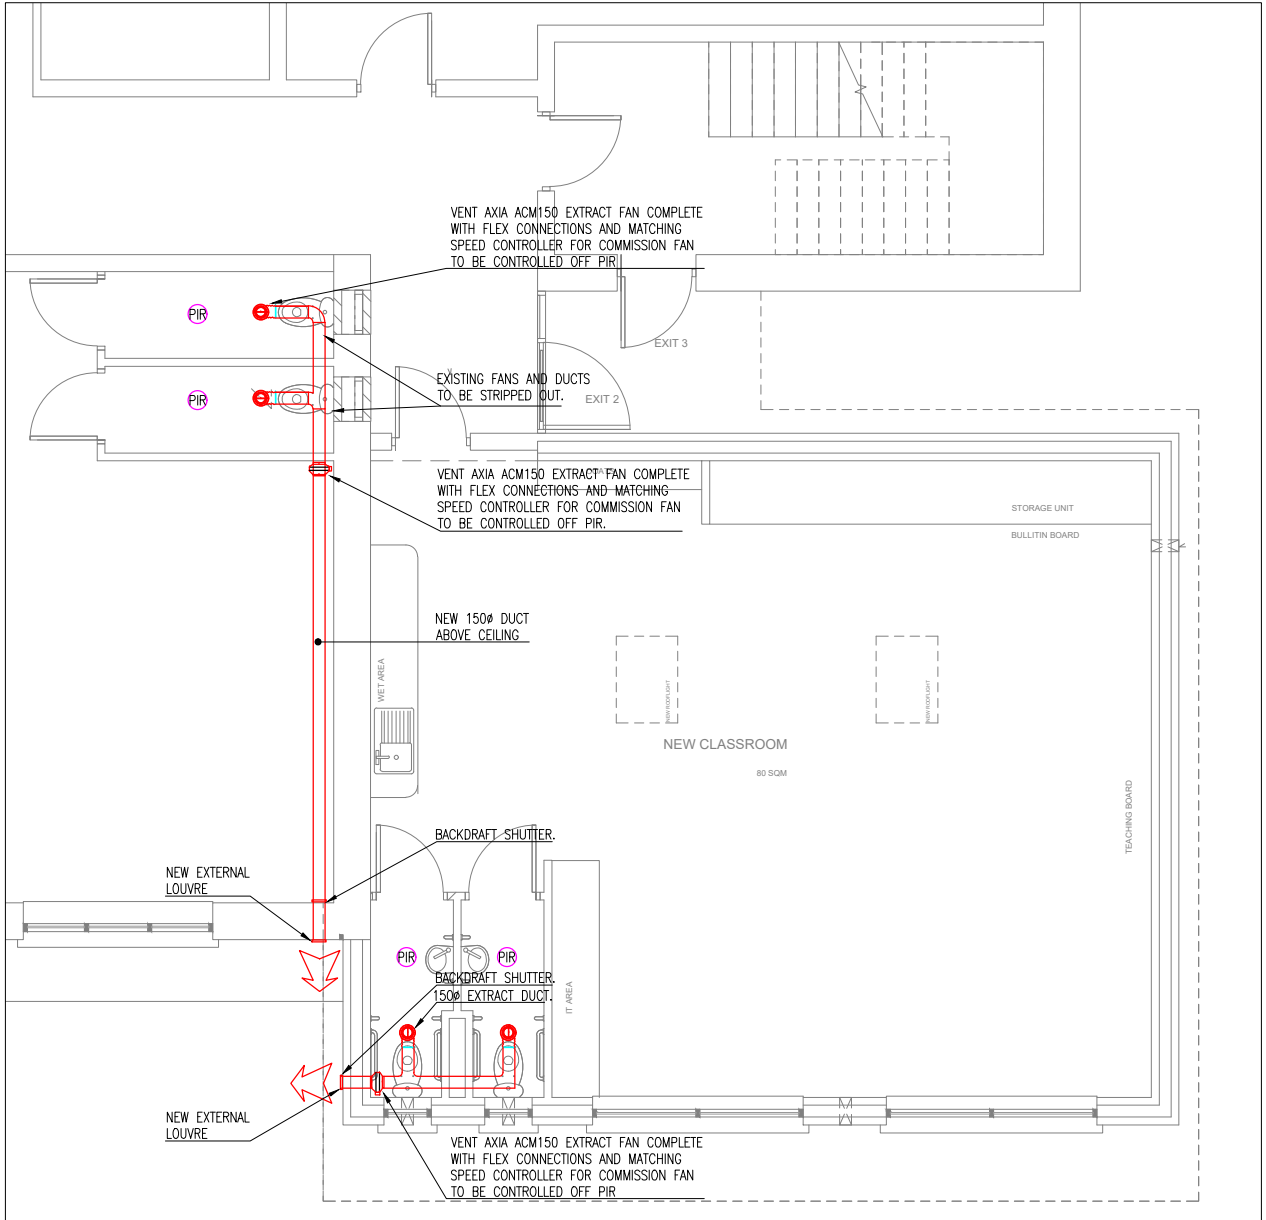

M200
02 VENTILATION LAYOUT – GROUND FLOOR
SCALE 1:50 @ A1 1:100 @ A3

TO	ISSUE FOR TENDER	18.08.26	CR
Revisions	Date	Checked	
 COLMAN REYNOLDS ASSOCIATES Building Services Engineers and Project Managers Unit 9 Southern Cross Business Park, Boghall Rd, Bray, Co Wicklow. [t] +353-1-2768700 [f] +353-1-6865522 [e] info@cra.ie			
Project			
COLLOONEY NS, SLIGO			
Drawing Title			
VENTILATION LAYOUT GROUND FLOOR			
Date	Drawn	Checked	Scale
07.07.26	PH	CR	1:50 @ A1 1:100 @ A3
Project No.		Drawing No.	Rev.
A1172		M200	TO

