


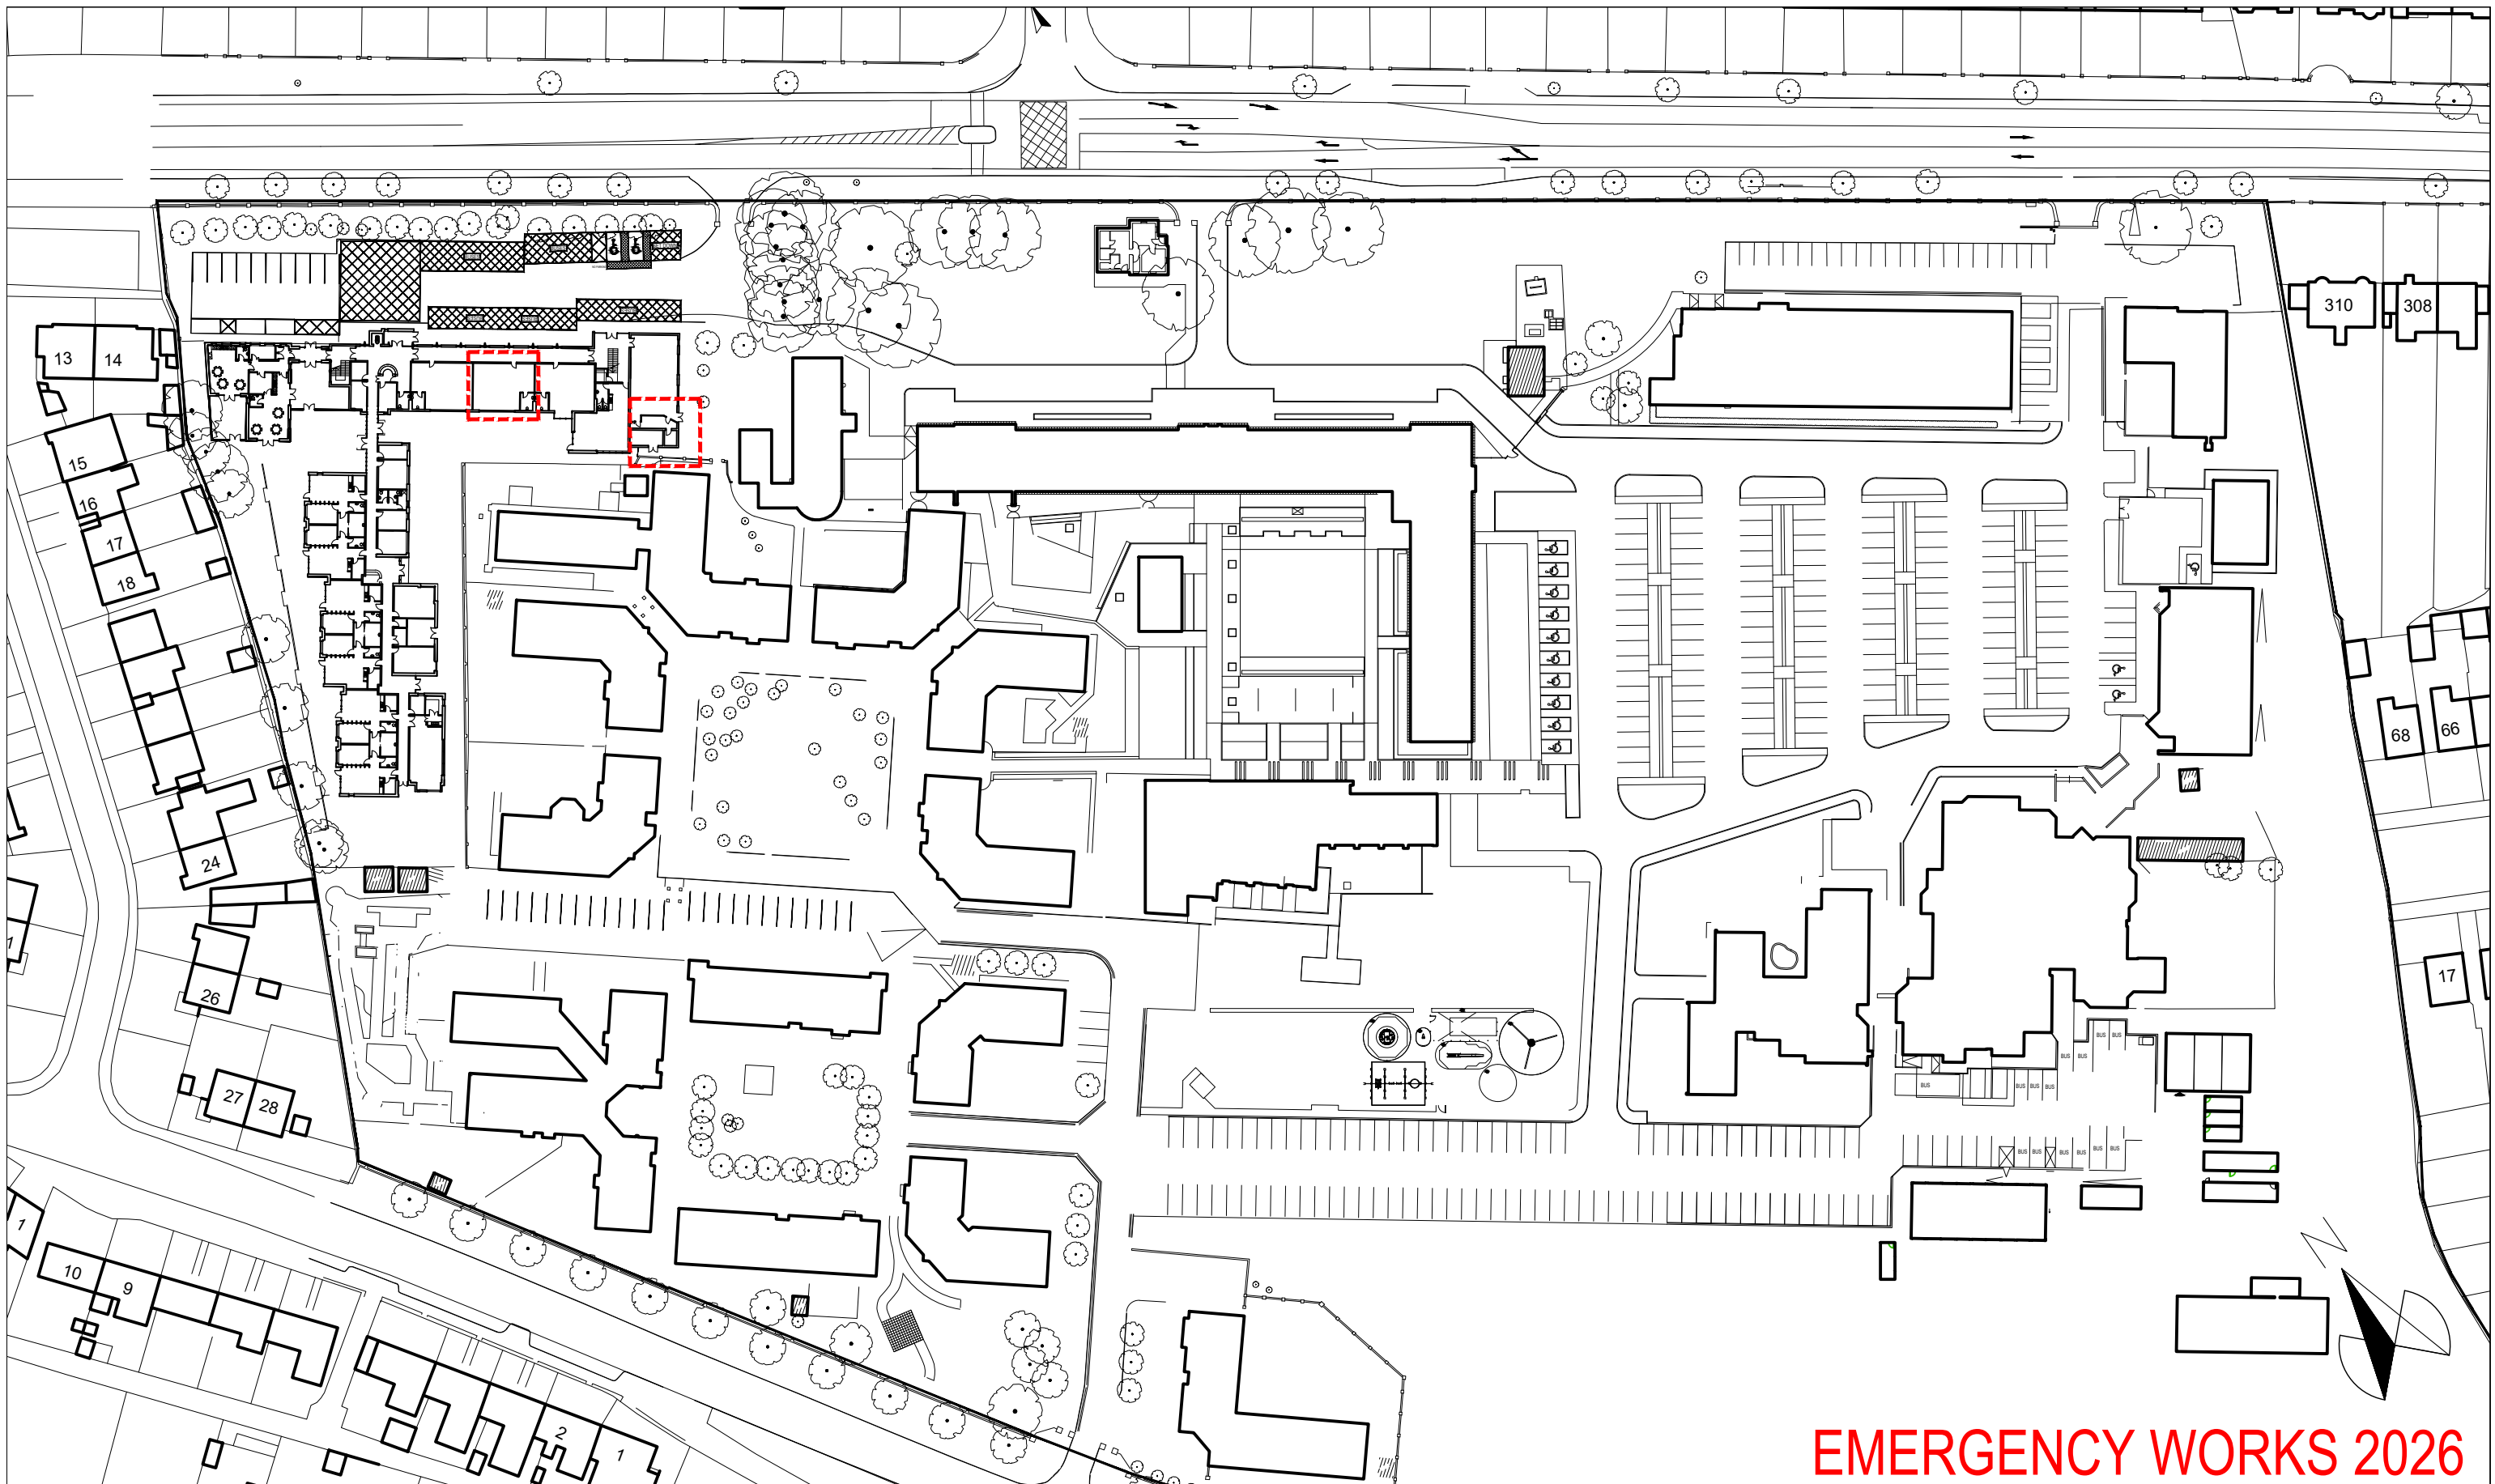

EMERGENCY WORKS 2026

Notes

1. Copyright Reserved
2. Work to figured dimensions only. Do not scale drawing.
3. The contractor is responsible for checking all levels and dimensions on site and shall refer all discrepancies to the Architect
4. Where appropriate, for details of r.c. structure, or mechanical and electrical details, see Engineers drawings
5. Proprietary items shall be fixed in strict accordance with manufacturers instructions.
6. Sizes of proprietary items shall be checked with manufacturer.
7. The contractor shall be responsible for the coordination of structure, finishes and services.

Project

**EMERGENCY / ACCESSIBLE WORK AT
ST VINCENTS SPECIAL SCHOOL, DUBLIN 7**

Drawing Title

EXISTING CAMPUS LAYOUT PLAN

Drawing No

25-04-1 - EW001

Scale

1:1000@A3

Rev

-

Drawn

CQ

Date

NOV 2025



DOMA Architecture

Architecture & Project Management

www.doma.ie



79 Merrion Square South, Dublin 2,
D02 TN27 tel. 01 507 9990

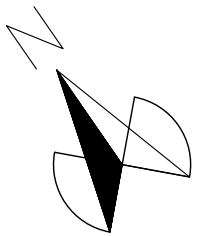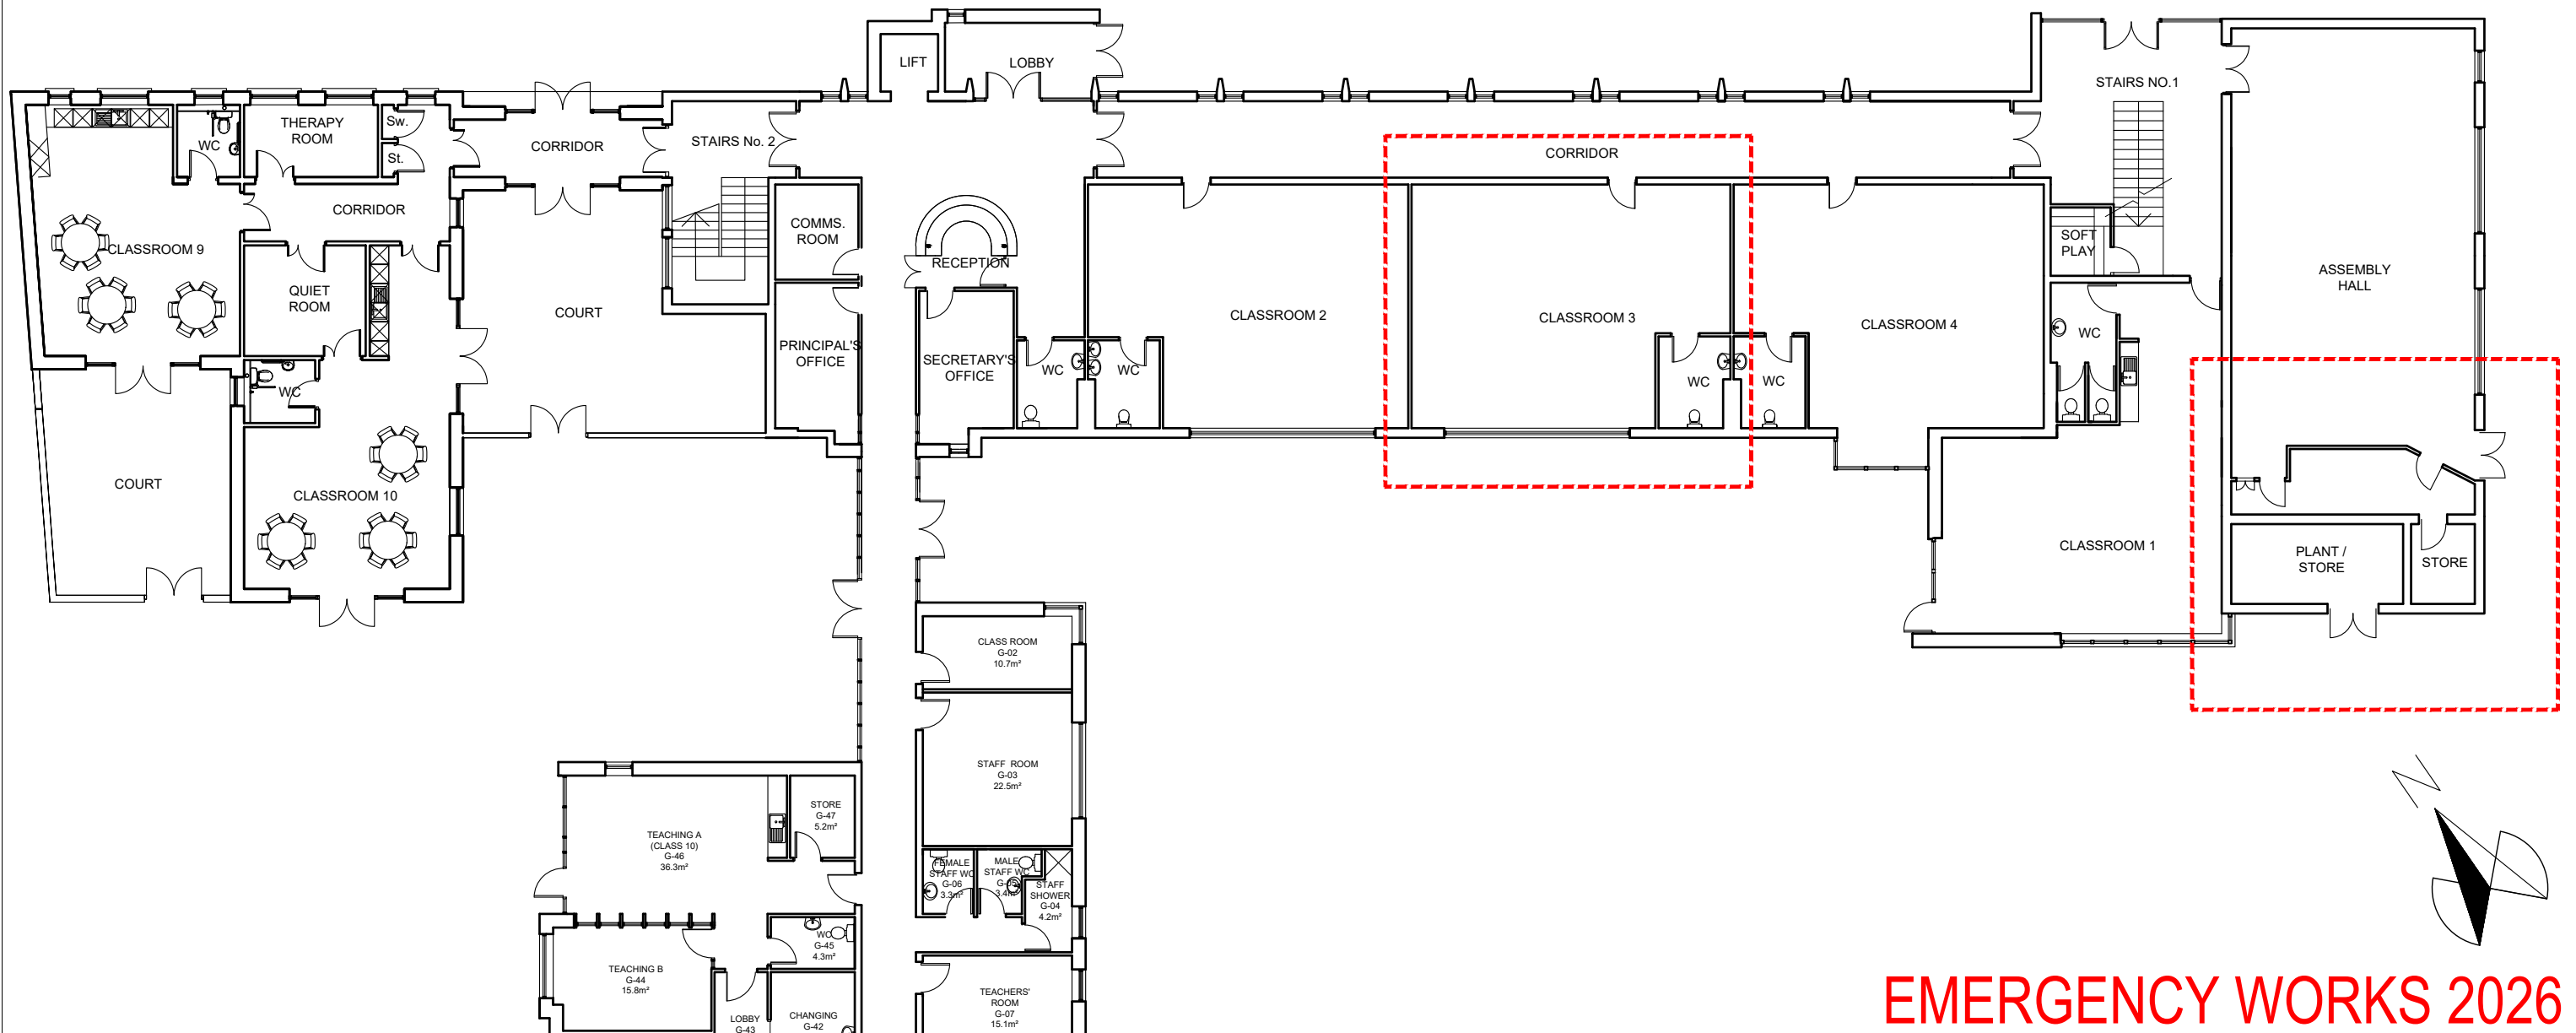

EMERGENCY WORKS 2026

Notes

1. Copyright Reserved
2. Work to figured dimensions only. Do not scale drawing.
3. The contractor is responsible for checking all levels and dimensions on site and shall refer all discrepancies to the Architect
4. Where appropriate, for details of r.c. structure, or mechanical and electrical details, see Engineers drawings
5. Proprietary items shall be fixed in strict accordance with manufacturers instructions.
6. Sizes of proprietary items shall be checked with manufacturer.
7. The contractor shall be responsible for the coordination of structure, finishes and services.

Project

**EMERGENCY / ACCESSIBLE WORK AT
ST VINCENTS SPECIAL SCHOOL, DUBLIN 7**

Drawing Title

EXISTING GROUND FLOOR PLAN

Drawing No

25-04-1 - EW002

Scale

1:200@A3

Rev

-

Drawn

CQ

Date



NOV 2025

DOMA Architecture
Architecture & Project Management



www.doma.ie

79 Merrion Square South, Dublin 2,
D02 TN27 tel. 01 507 9990

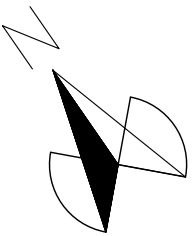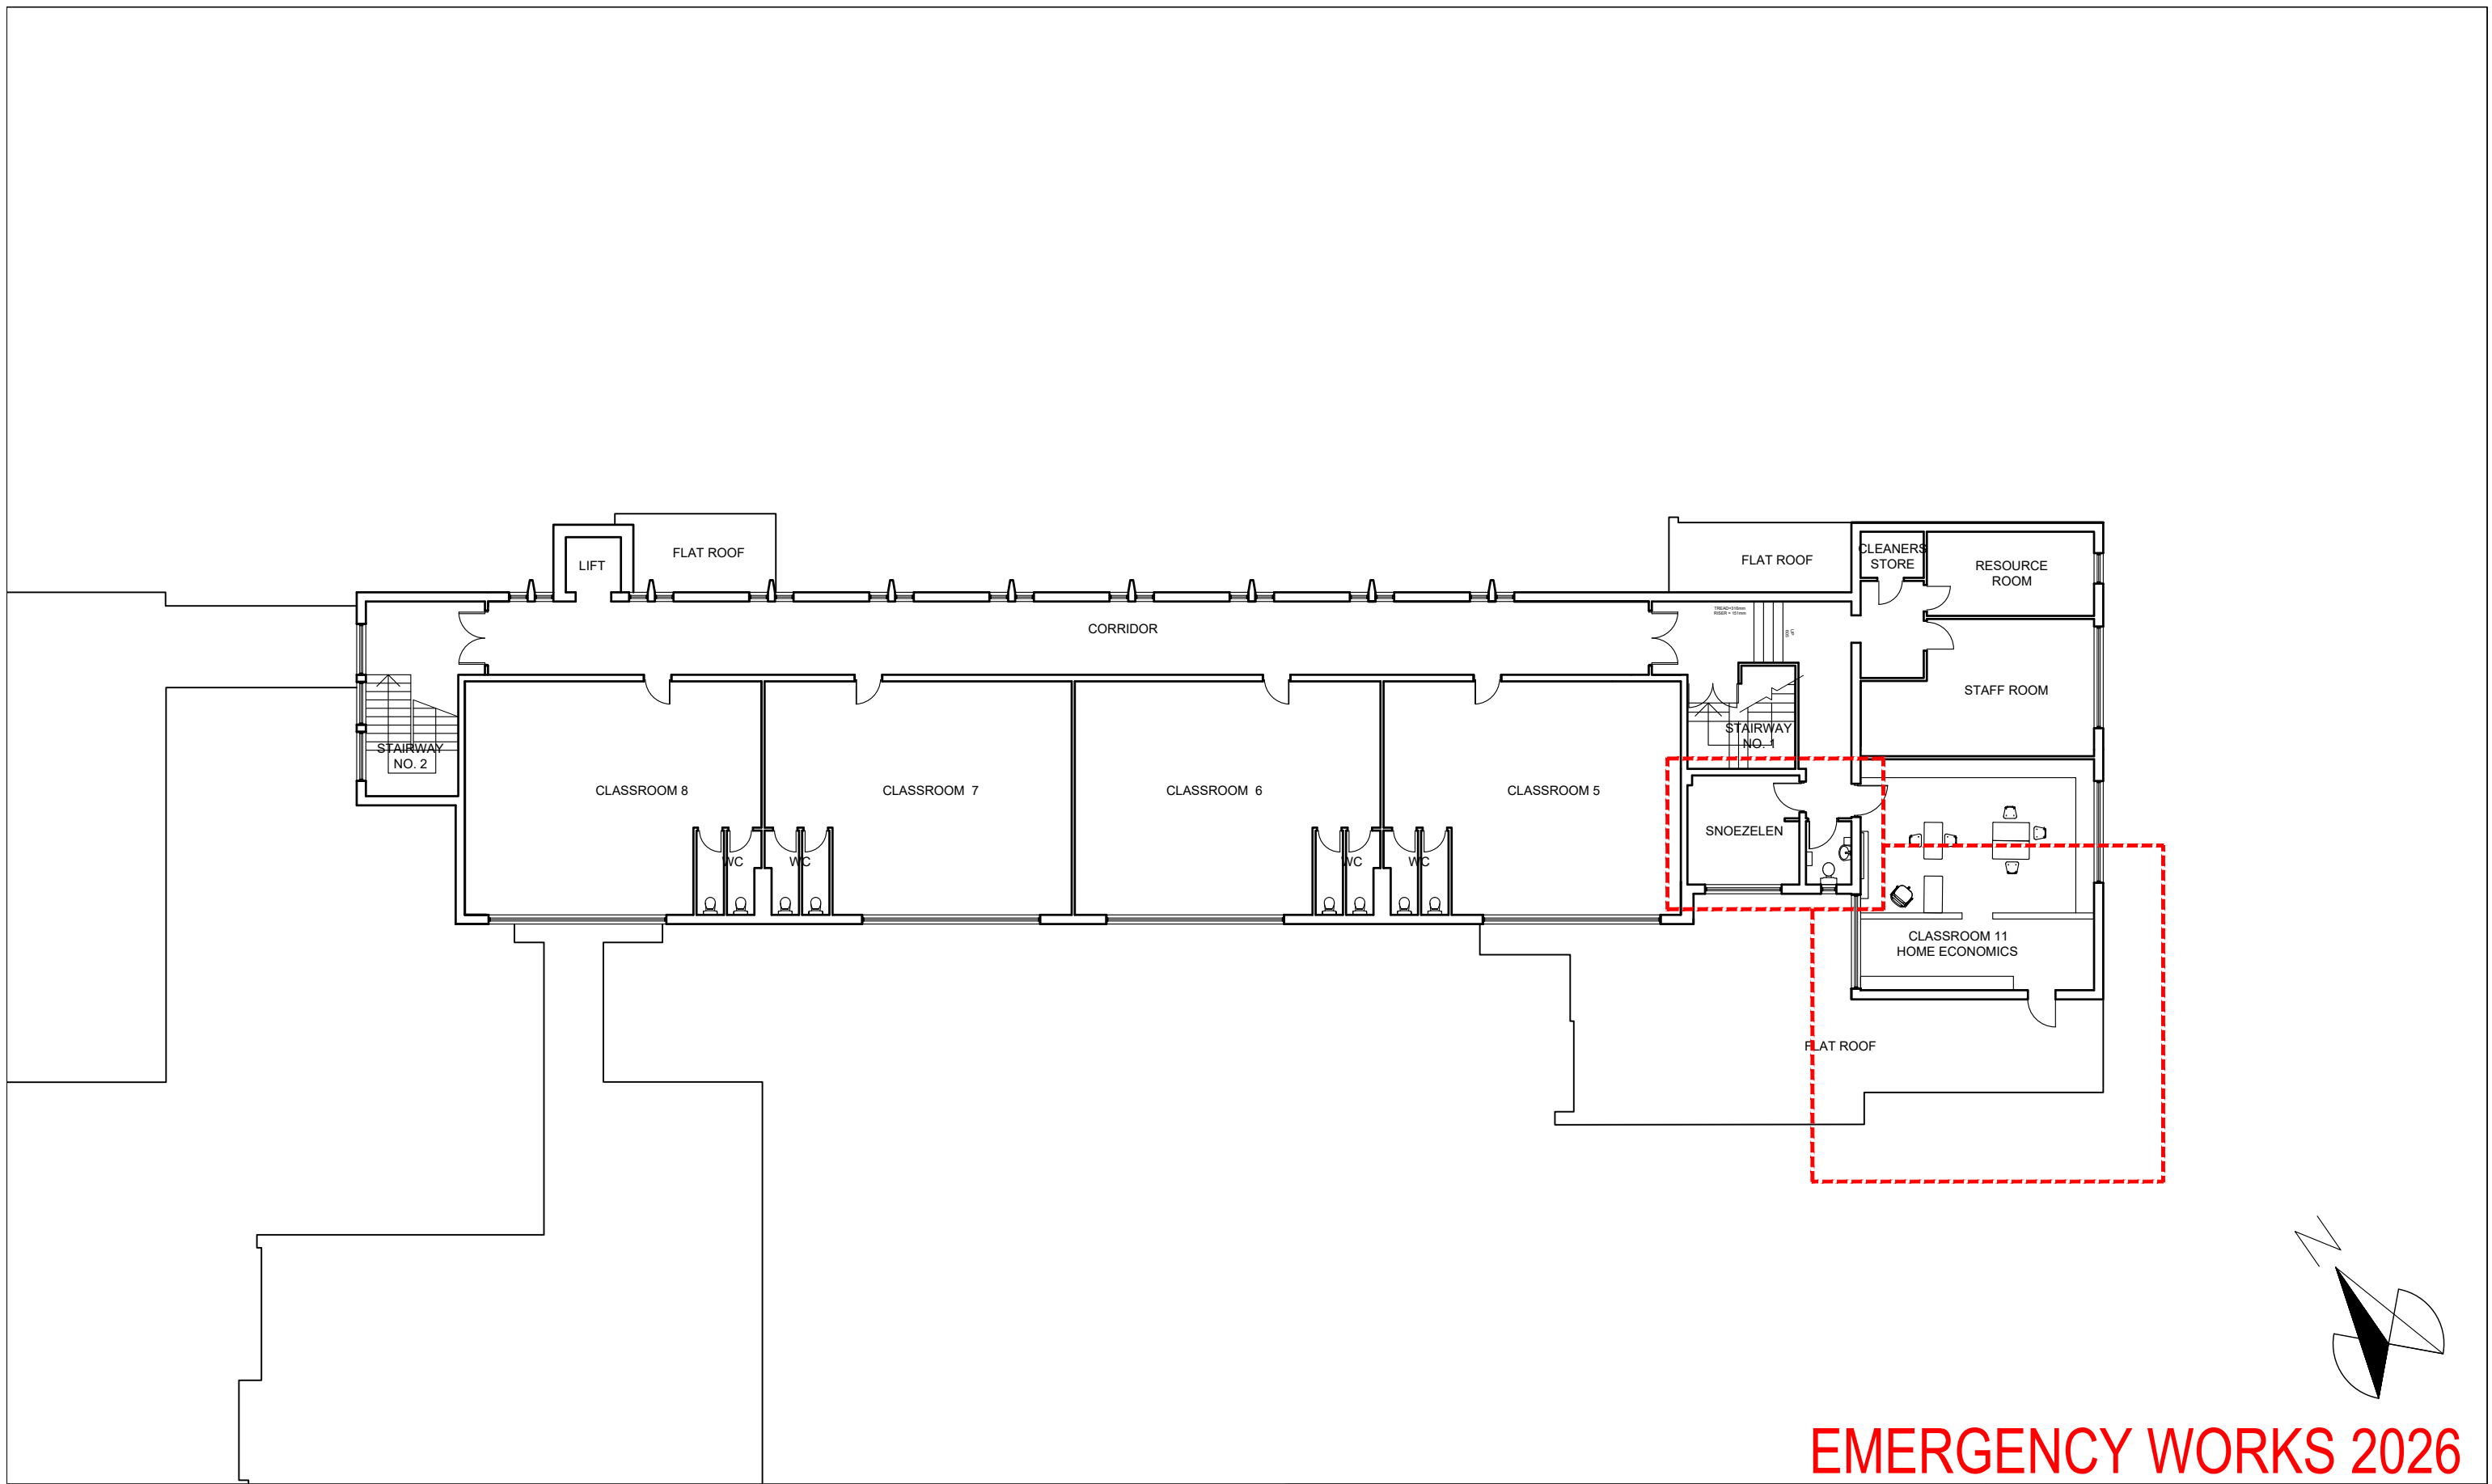

EMERGENCY WORKS 2026

Notes


- 1. Copyright Reserved
- 2. Work to figured dimensions only. Do not scale drawing.
- 3. The contractor is responsible for checking all levels and dimensions on site and shall refer all discrepancies to the Architect
- 4. Where appropriate, for details of r.c. structure, or mechanical and electrical details, see Engineers drawings
- 5. Proprietary items shall be fixed in strict accordance with manufacturers instructions.
- 6. Sizes of proprietary items shall be checked with manufacturer.
- 7. The contractor shall be responsible for the coordination of structure, finishes and services.

Project	EMERGENCY / ACCESSIBLE WORK AT ST VINCENTS SPECIAL SCHOOL, DUBLIN 7		
Drawing Title	EXISTING FIRST FLOOR PLAN		
Drawing No	25-04-1 - EW003		
Scale	1:200@A3	Rev	-
Drawn	CQ	Date	NOV 2025


DOMA Architecture
Architecture & Project Management



www.doma.ie
79 Merrion Square South, Dublin 2,
D02 TN27 tel. 01 507 9990

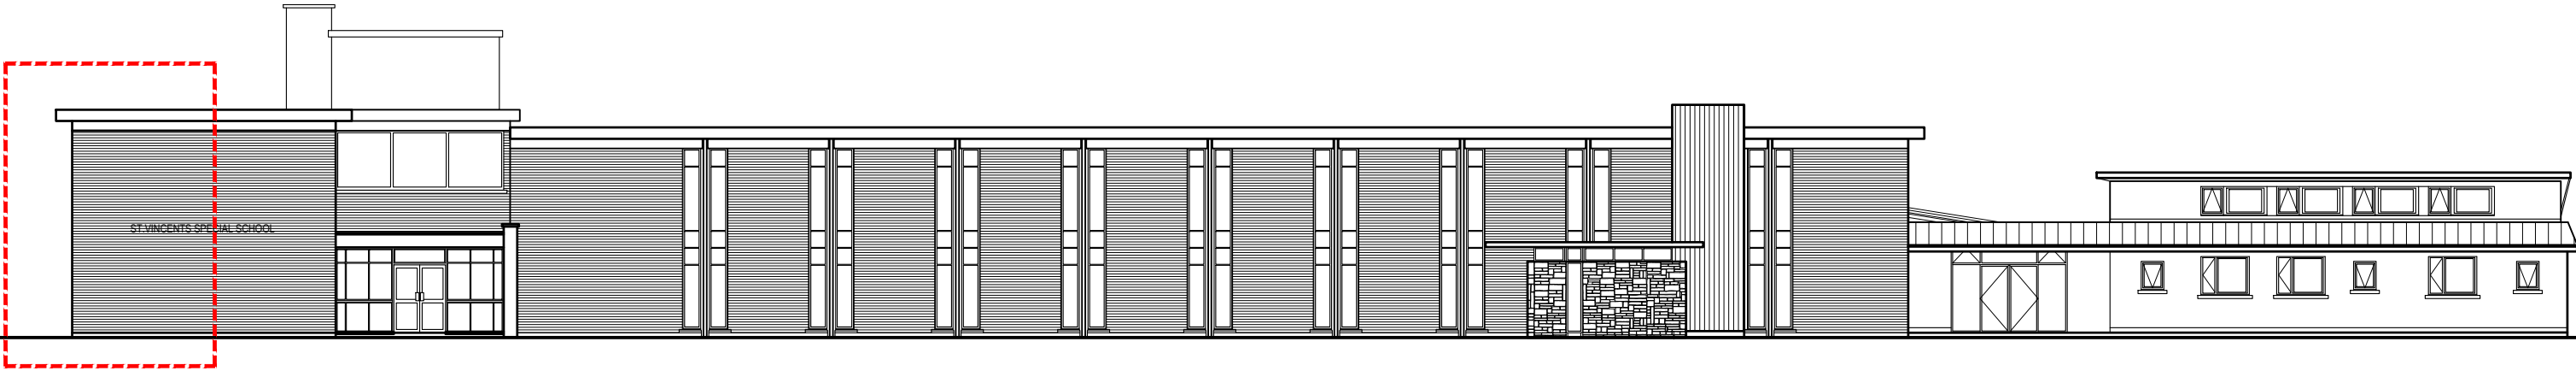

EXISTING NORTH ELEVATION

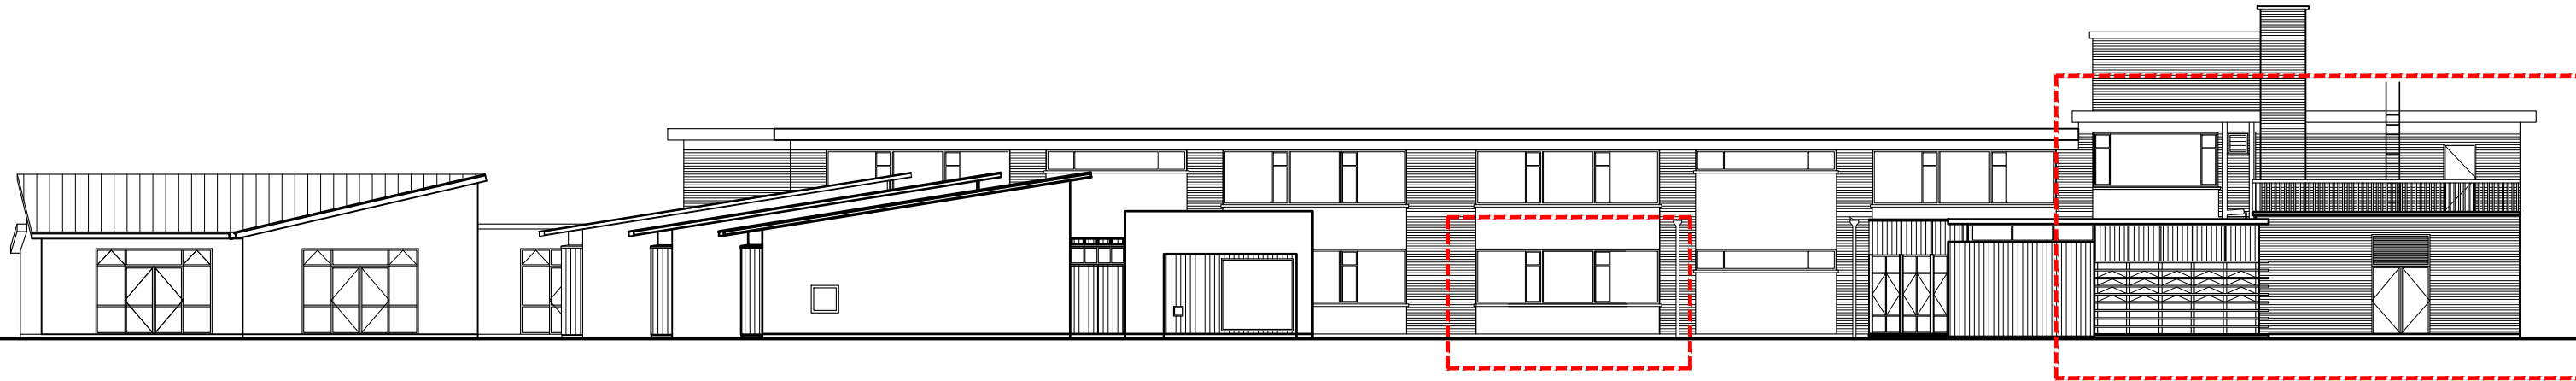

EXISTING SOUTH ELEVATION

EMERGENCY WORKS 2026

Notes

- 1. Copyright Reserved
- 2. Work to figured dimensions only. Do not scale drawing.
- 3. The contractor is responsible for checking all levels and dimensions on site and shall refer all discrepancies to the Architect
- 4. Where appropriate, for details of r.c. structure, or mechanical and electrical details, see Engineers drawings
- 5. Proprietary items shall be fixed in strict accordance with manufacturers instructions.
- 6. Sizes of proprietary items shall be checked with manufacturer.
- 7. The contractor shall be responsible for the coordination of structure, finishes and services.

Project	EMERGENCY / ACCESSIBLE WORK AT ST VINCENTS SPECIAL SCHOOL, DUBLIN 7		
Drawing Title	EXISTING ELEVATIONS (NORTH&SOUTH)		
Drawing No	25-04-1 - EW004		
Scale	1:200@A3	Rev	-
Drawn	CQ	Date	NOV 2025

DOMA Architecture
Architecture & Project Management


www.doma.ie

79 Merrion Square South, Dublin 2,
D02 TN27 tel. 01 507 9990





EXISTING EAST ELEVATION

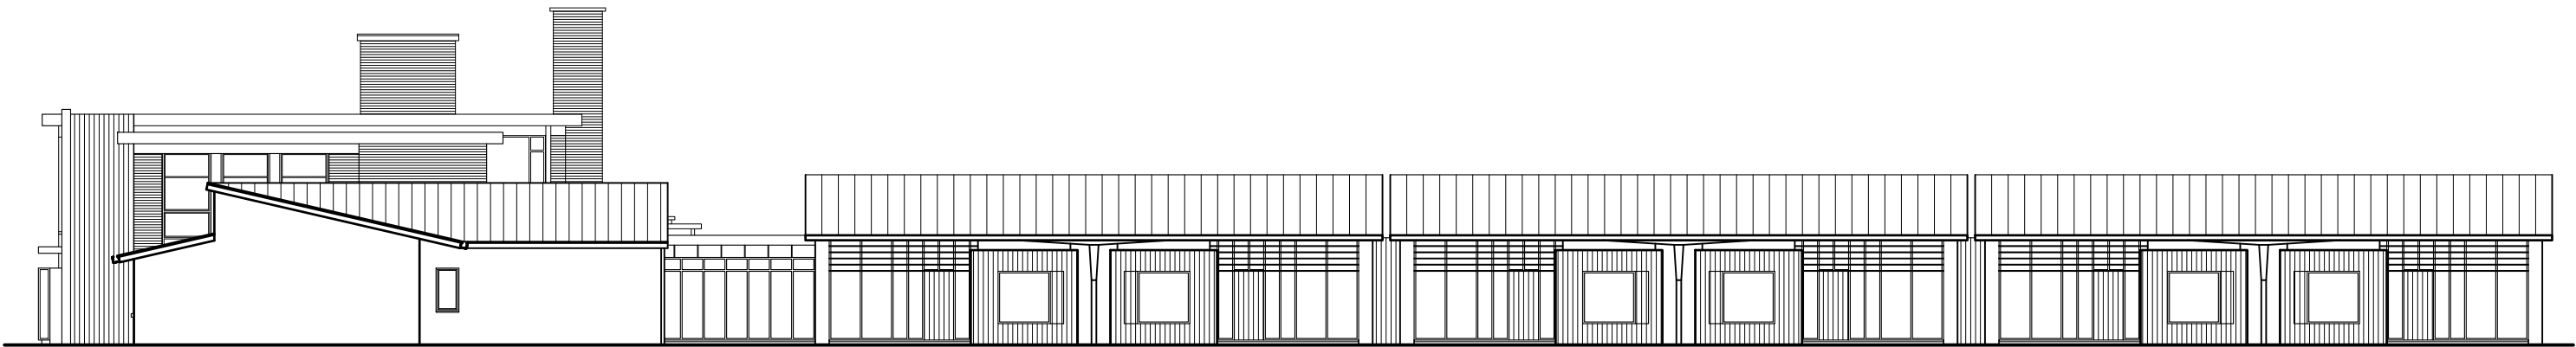

EXISTING WEST ELEVATION

EMERGENCY WORKS 2026

Notes

- 1. Copyright Reserved
- 2. Work to figured dimensions only. Do not scale drawing.
- 3. The contractor is responsible for checking all levels and dimensions on site and shall refer all discrepancies to the Architect
- 4. Where appropriate, for details of r.c. structure, or mechanical and electrical details, see Engineers drawings
- 5. Proprietary items shall be fixed in strict accordance with manufacturers instructions.
- 6. Sizes of proprietary items shall be checked with manufacturer.
- 7. The contractor shall be responsible for the coordination of structure, finishes and services.

Project		EMERGENCY / ACCESSIBLE WORK AT ST VINCENTS SPECIAL SCHOOL, DUBLIN 7			
Drawing Title		EXISTING ELEVATIONS (EAST & WEST)			
Drawing No		25-04-1 - EW005			
Scale	1:200@A3	Rev	-	Drawn	CQ
		Date	NOV 2025		

DOMA Architecture

Architecture & Project Management

www.doma.ie

79 Merrion Square South, Dublin 2,
D02 TN27 tel. 01 507 9990




Form a new external door opening, within the existing window frame structure, for direct access to the yard. Provide new double glazed aluminium doors and windows to classroom to suit.

Classroom 3 to be fully fit out to Department of Education standards for a Home Economics Room complete with kitchen appliances extract, new ceilings, new Marmoleum floor finishes, new joinery, new wall finishes, white board, etc.

Reconfigure electrical switches and light fittings, as necessary.

Reconfigure existing services, including relocation of existing radiators and new radiators, as necessary.

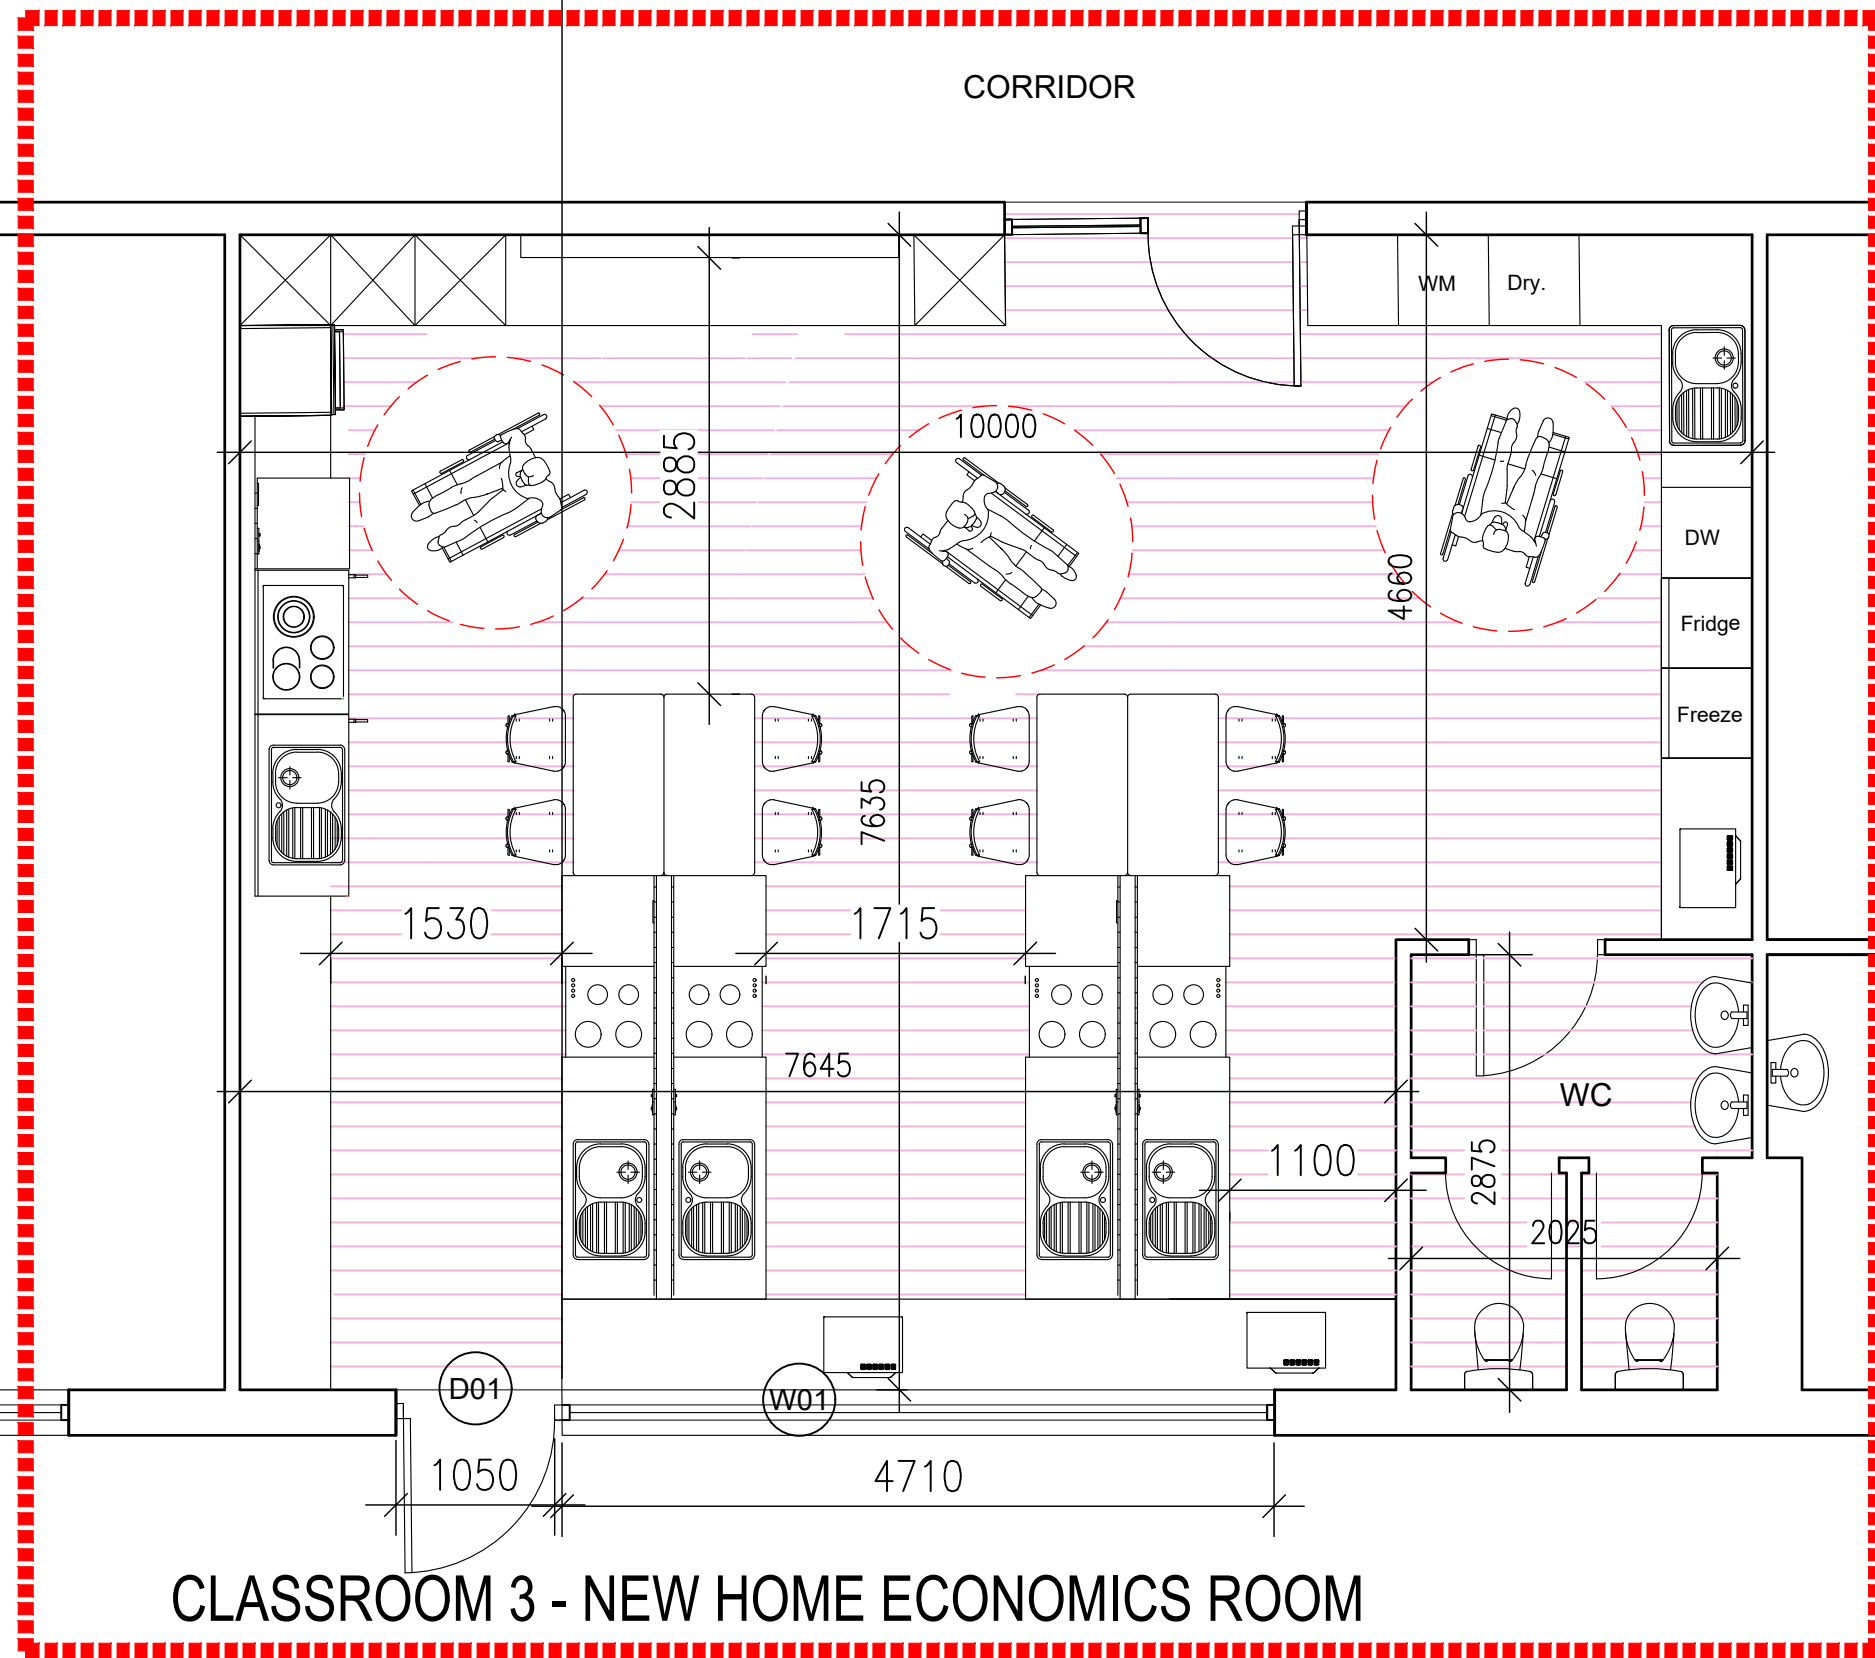

CLASSROOM 3 - NEW HOME ECONOMICS ROOM

EMERGENCY WORKS 2026

Notes

1. Copyright Reserved
2. Work to figured dimensions only. Do not scale drawing.
3. The contractor is responsible for checking all levels and dimensions on site and shall refer all discrepancies to the Architect
4. Where appropriate, for details of r.c. structure, or mechanical and electrical details, see Engineers drawings
5. Proprietary items shall be fixed in strict accordance with manufacturers instructions.
6. Sizes of proprietary items shall be checked with manufacturer.
7. The contractor shall be responsible for the coordination of structure, finishes and services.

Project

EMERGENCY / ACCESSIBLE WORK AT
ST VINCENTS SPECIAL SCHOOL, DUBLIN 7

Drawing Title

PROPOSED GROUND FLOOR PLAN - HOME ECONOMICS ROOM

Drawing No

25-04-1 - EW006

Scale

1:50@A3

Rev

-

Drawn

CQ

Date

NOV 2025


DOMA Architecture

Architecture & Project Management



www.doma.ie

79 Merrion Square South, Dublin 2,
D02 TN27 tel. 01 507 9990

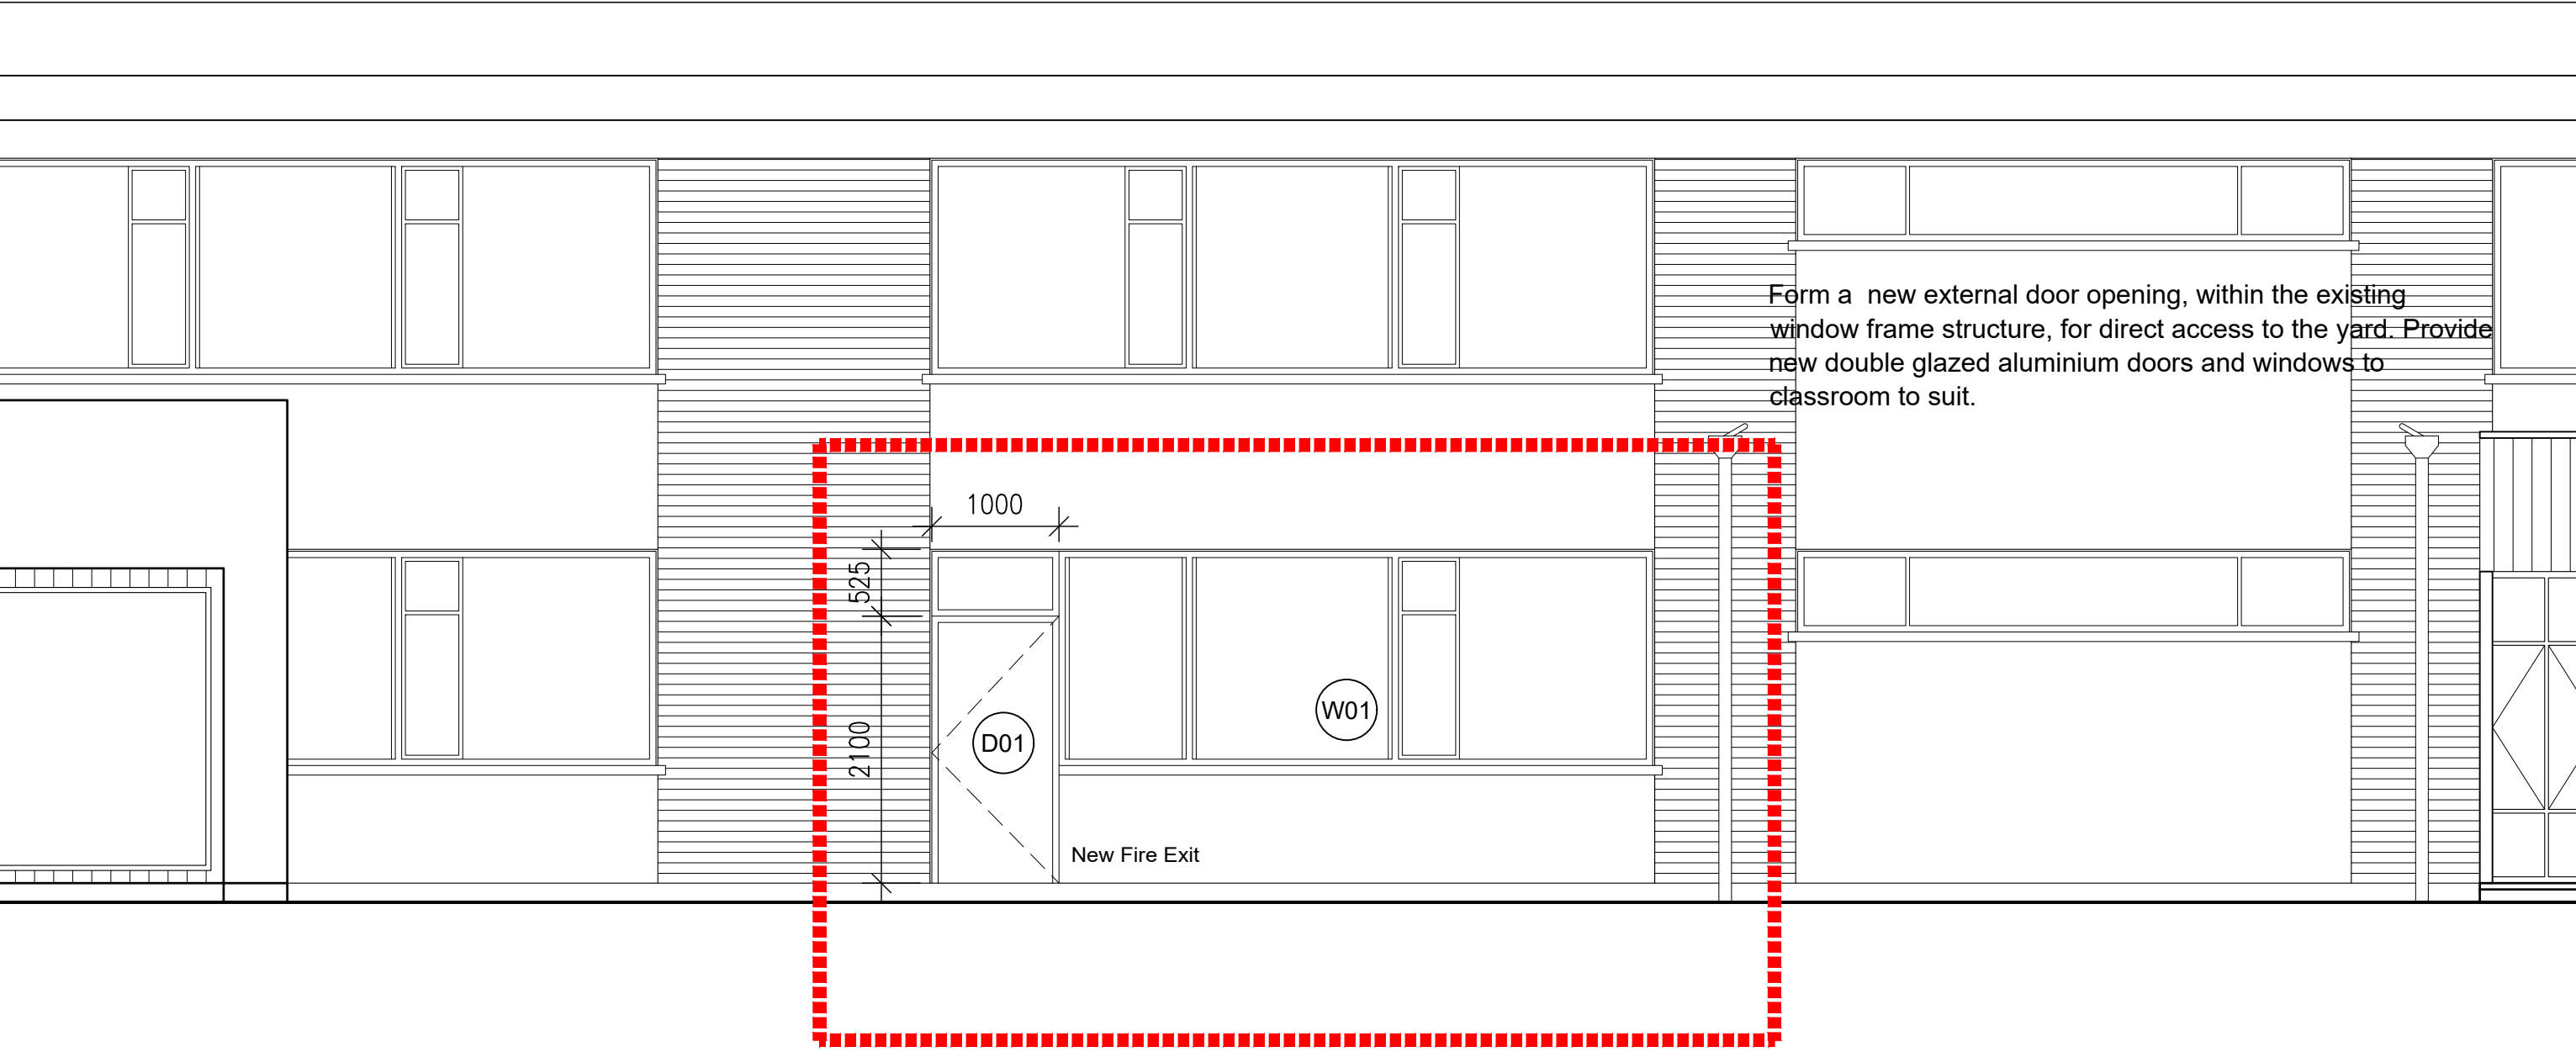

CLASSROOM 3 - NEW HOME ECONOMICS ROOM ELEVATION

EMERGENCY WORKS 2026

Notes

1. Copyright Reserved

2. Work to figured dimensions only. Do not scale drawing.

3. The contractor is responsible for checking all levels and dimensions on site and shall refer all discrepancies to the Architect

4. Where appropriate, for details of r.c. structure, or mechanical and electrical details, see Engineers drawings

5. Proprietary items shall be fixed in strict accordance with manufacturers instructions.

6. Sizes of proprietary items shall be checked with manufacturer.

7. The contractor shall be responsible for the coordination of structure, finishes and services.

Project

EMERGENCY / ACCESSIBLE WORK AT
ST VINCENTS SPECIAL SCHOOL, DUBLIN 7

Drawing Title

PROPOSED GROUND FLOOR PLAN - HOME ECONOMICS ROOM

Drawing No

25-04-1 - EW007

Scale

1:50@A3

Rev

-

Drawn

CQ

Date

NOV 2025


DOMA Architecture

Architecture & Project Management



www.doma.ie

79 Merrion Square South, Dublin 2,
D02 TN27 tel. 01 507 9990

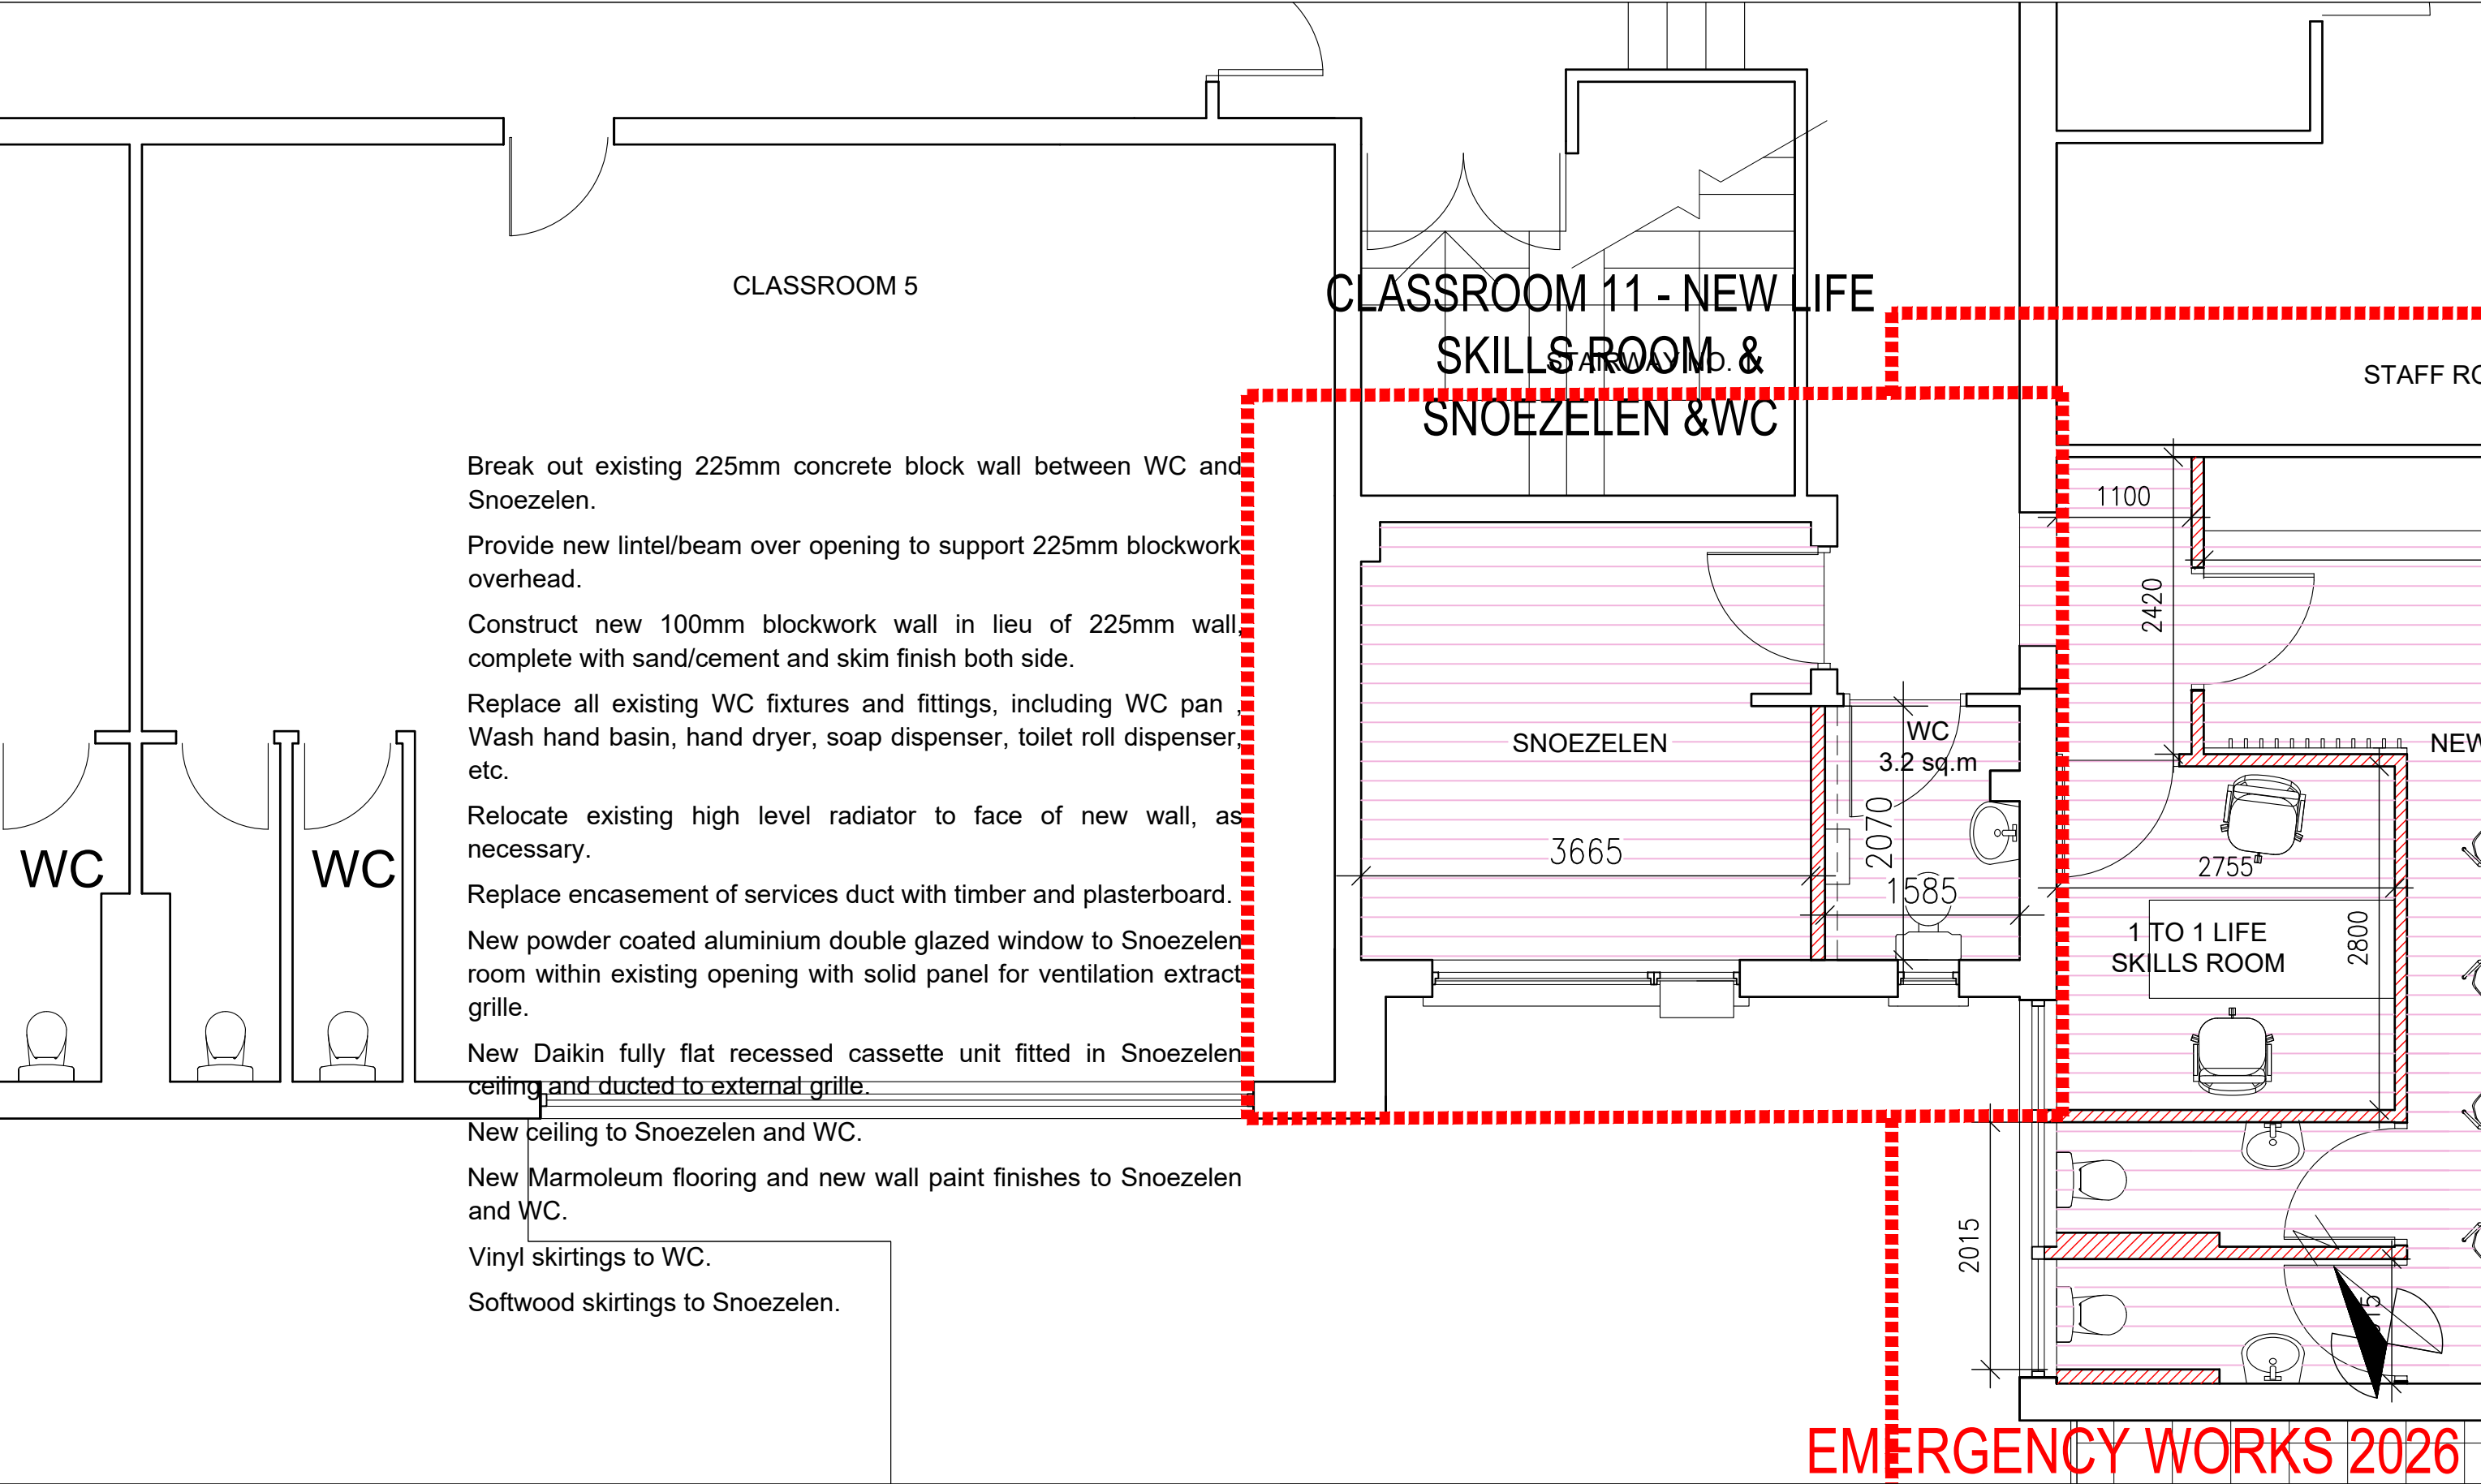

Notes

1. Copyright Reserved
2. Work to figured dimensions only. Do not scale drawing.
3. The contractor is responsible for checking all levels and dimensions on site and shall refer all discrepancies to the Architect
4. Where appropriate, for details of r.c. structure, or mechanical and electrical details, see Engineers drawings
5. Proprietary items shall be fixed in strict accordance with manufacturers instructions.
6. Sizes of proprietary items shall be checked with manufacturer.
7. The contractor shall be responsible for the coordination of structure, finishes and services.

Project

**EMERGENCY / ACCESSIBLE WORK AT
ST VINCENTS SPECIAL SCHOOL, DUBLIN 7**

Drawing Title

PROPOSED FIRST FLOOR- FIRE ESCAPE& NEW LIFE SKILLS ROOM

Drawing No

25-04-1 - EW008

Scale

1:50@A3

Rev

-

Drawn

CQ

Date

NOV 2025


DOMA Architecture

Architecture & Project Management



www.doma.ie

79 Merrion Square South, Dublin 2,
D02 TN27 tel. 01 507 9990

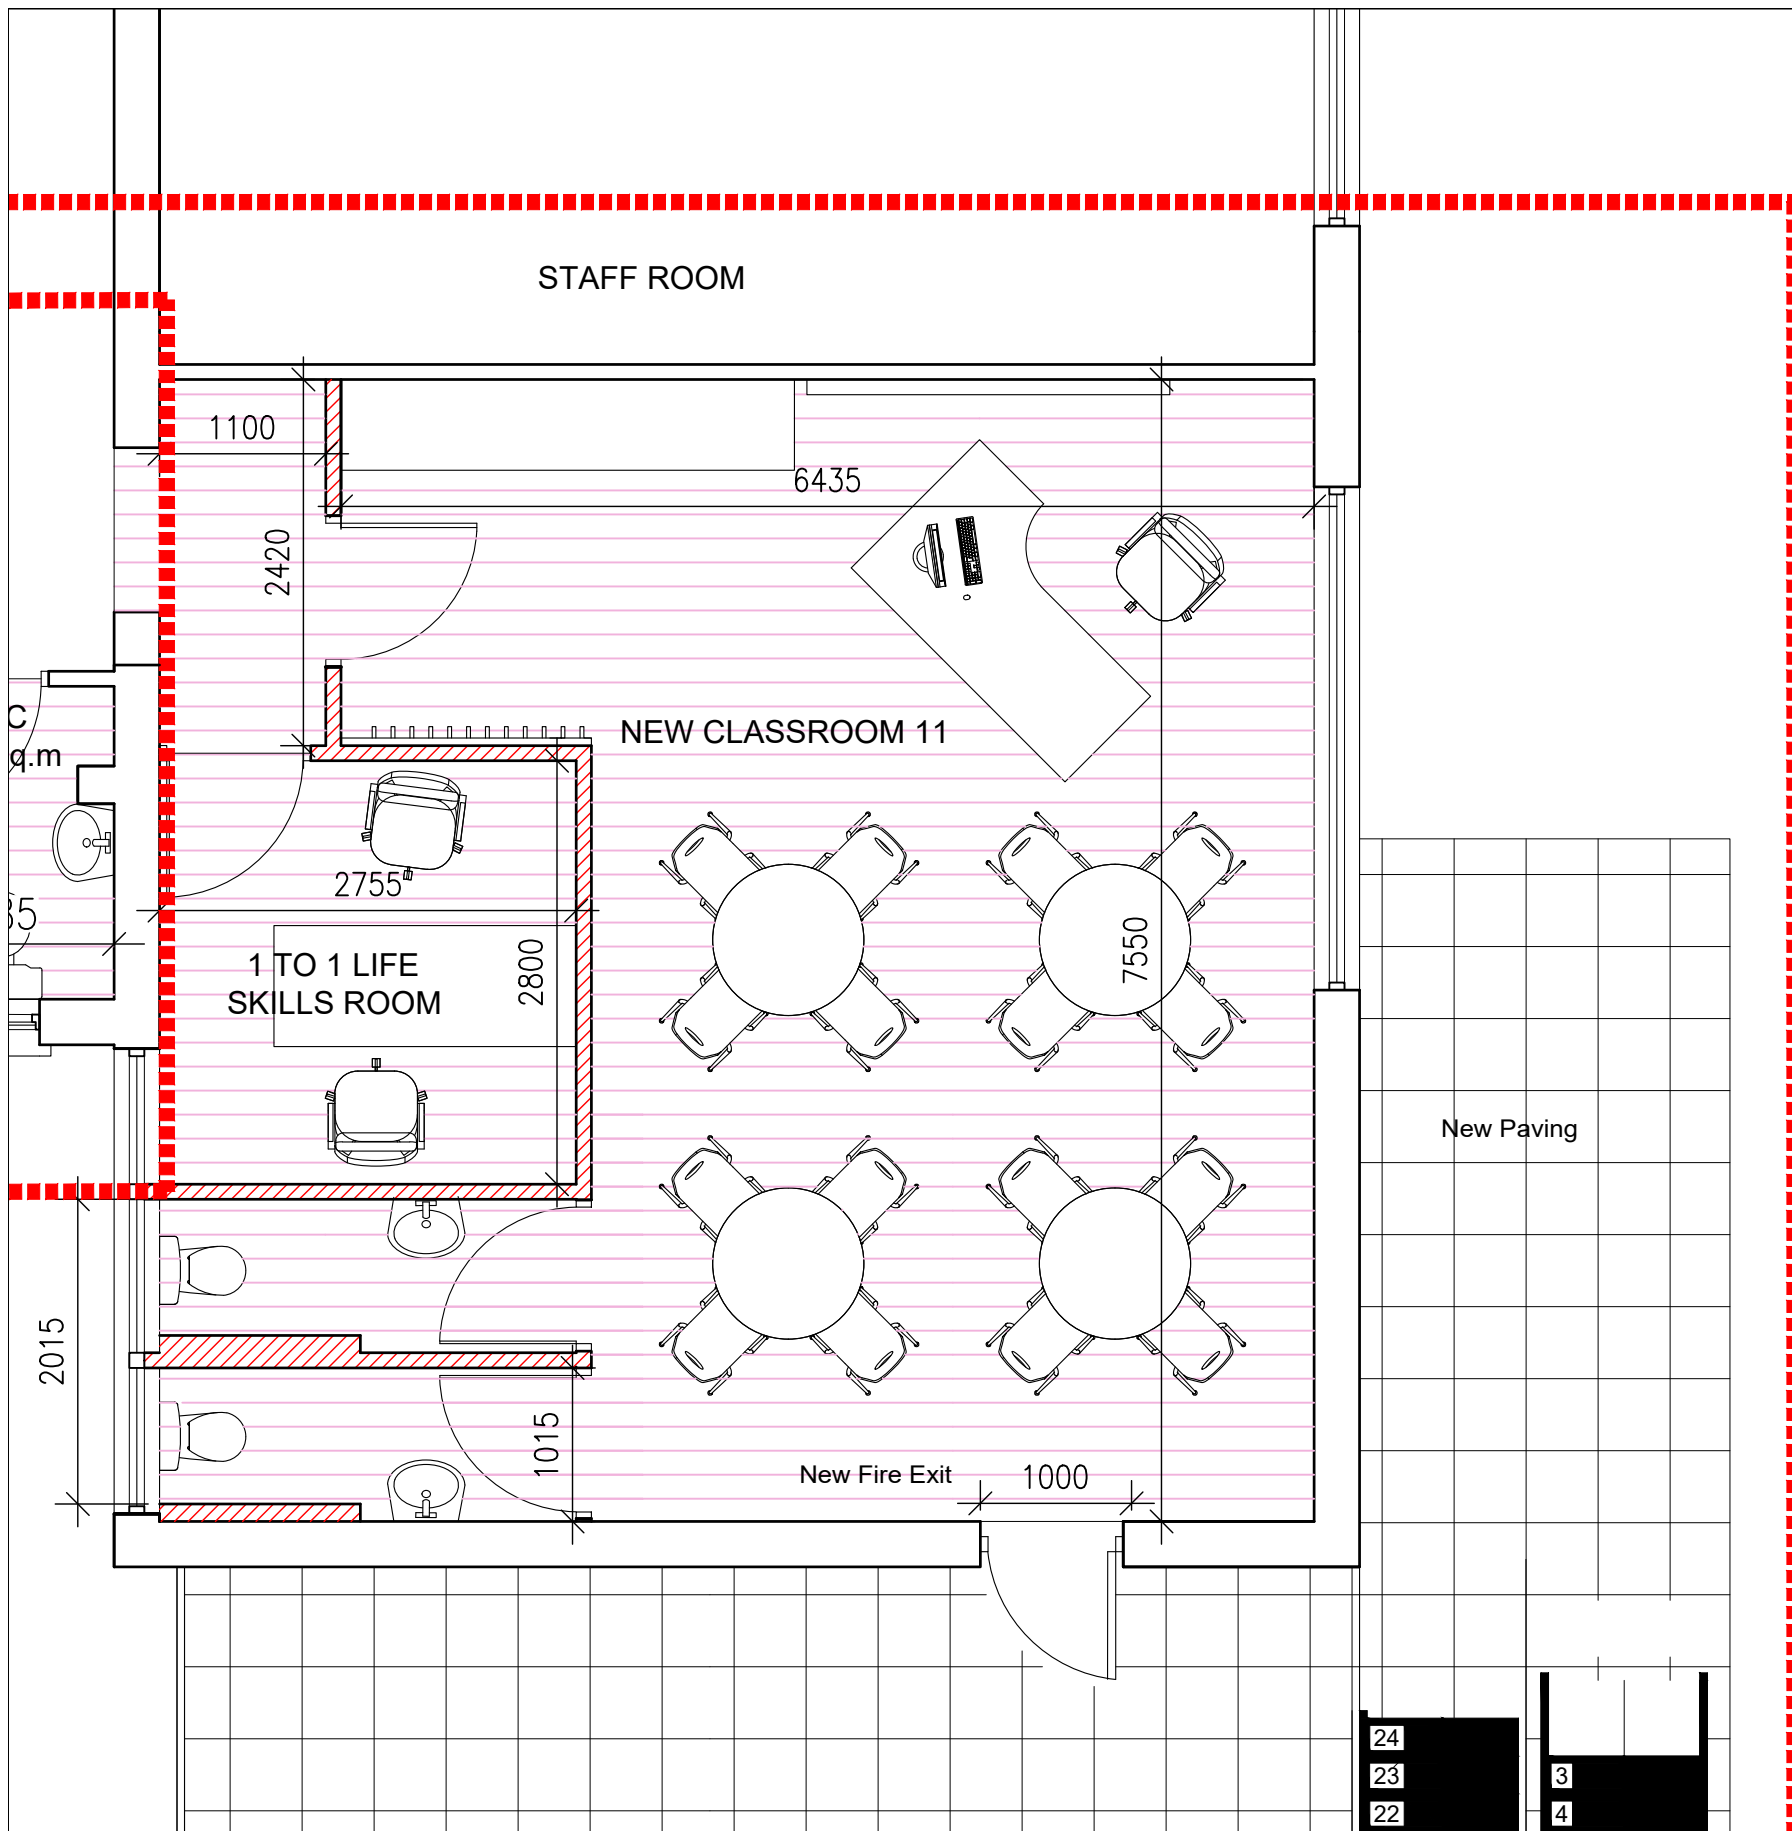

Construct new metal stud partition walls to form one-one tuition room and WC cubicles.


Provide new steel faced fire escape door, with panic bolt and secure locking system to access balcony escape.D01

Provide new double glazed aluminium windows to classroom to suit.W01

Classroom, WC cubicles and one-to-one room to be fully fit out to Department of Education standards, complete with new ceilings, new Marmoleum floor finishes, new doors, new joinery, new wall finishes, white board, etc.

Reconfigure electrical switches and light fittings, as necessary.

Reconfigure existing services, including relocation of existing Classroom 11 radiator and new radiators to new rooms.

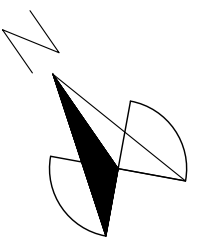

EMERGENCY WORKS 2026

Notes

1. Copyright Reserved
2. Work to figured dimensions only. Do not scale drawing.
3. The contractor is responsible for checking all levels and dimensions on site and shall refer all discrepancies to the Architect
4. Where appropriate, for details of r.c. structure, or mechanical and electrical details, see Engineers drawings
5. Proprietary items shall be fixed in strict accordance with manufacturers instructions.
6. Sizes of proprietary items shall be checked with manufacturer.
7. The contractor shall be responsible for the coordination of structure, finishes and services.

Project

**EMERGENCY / ACCESSIBLE WORK AT
ST VINCENTS SPECIAL SCHOOL, DUBLIN 7**

Drawing Title

PROPOSED FIRST FLOOR- CLASSROOM & NEW LIFE SKILLS ROOM

Drawing No

25-04-1 - EW009

Scale

1:50@A3

Rev

-

Drawn

CQ

Date


NOV 2025

DOMA Architecture
Architecture & Project Management



www.doma.ie

79 Merrion Square South, Dublin 2,
D02 TN27 tel. 01 507 9990

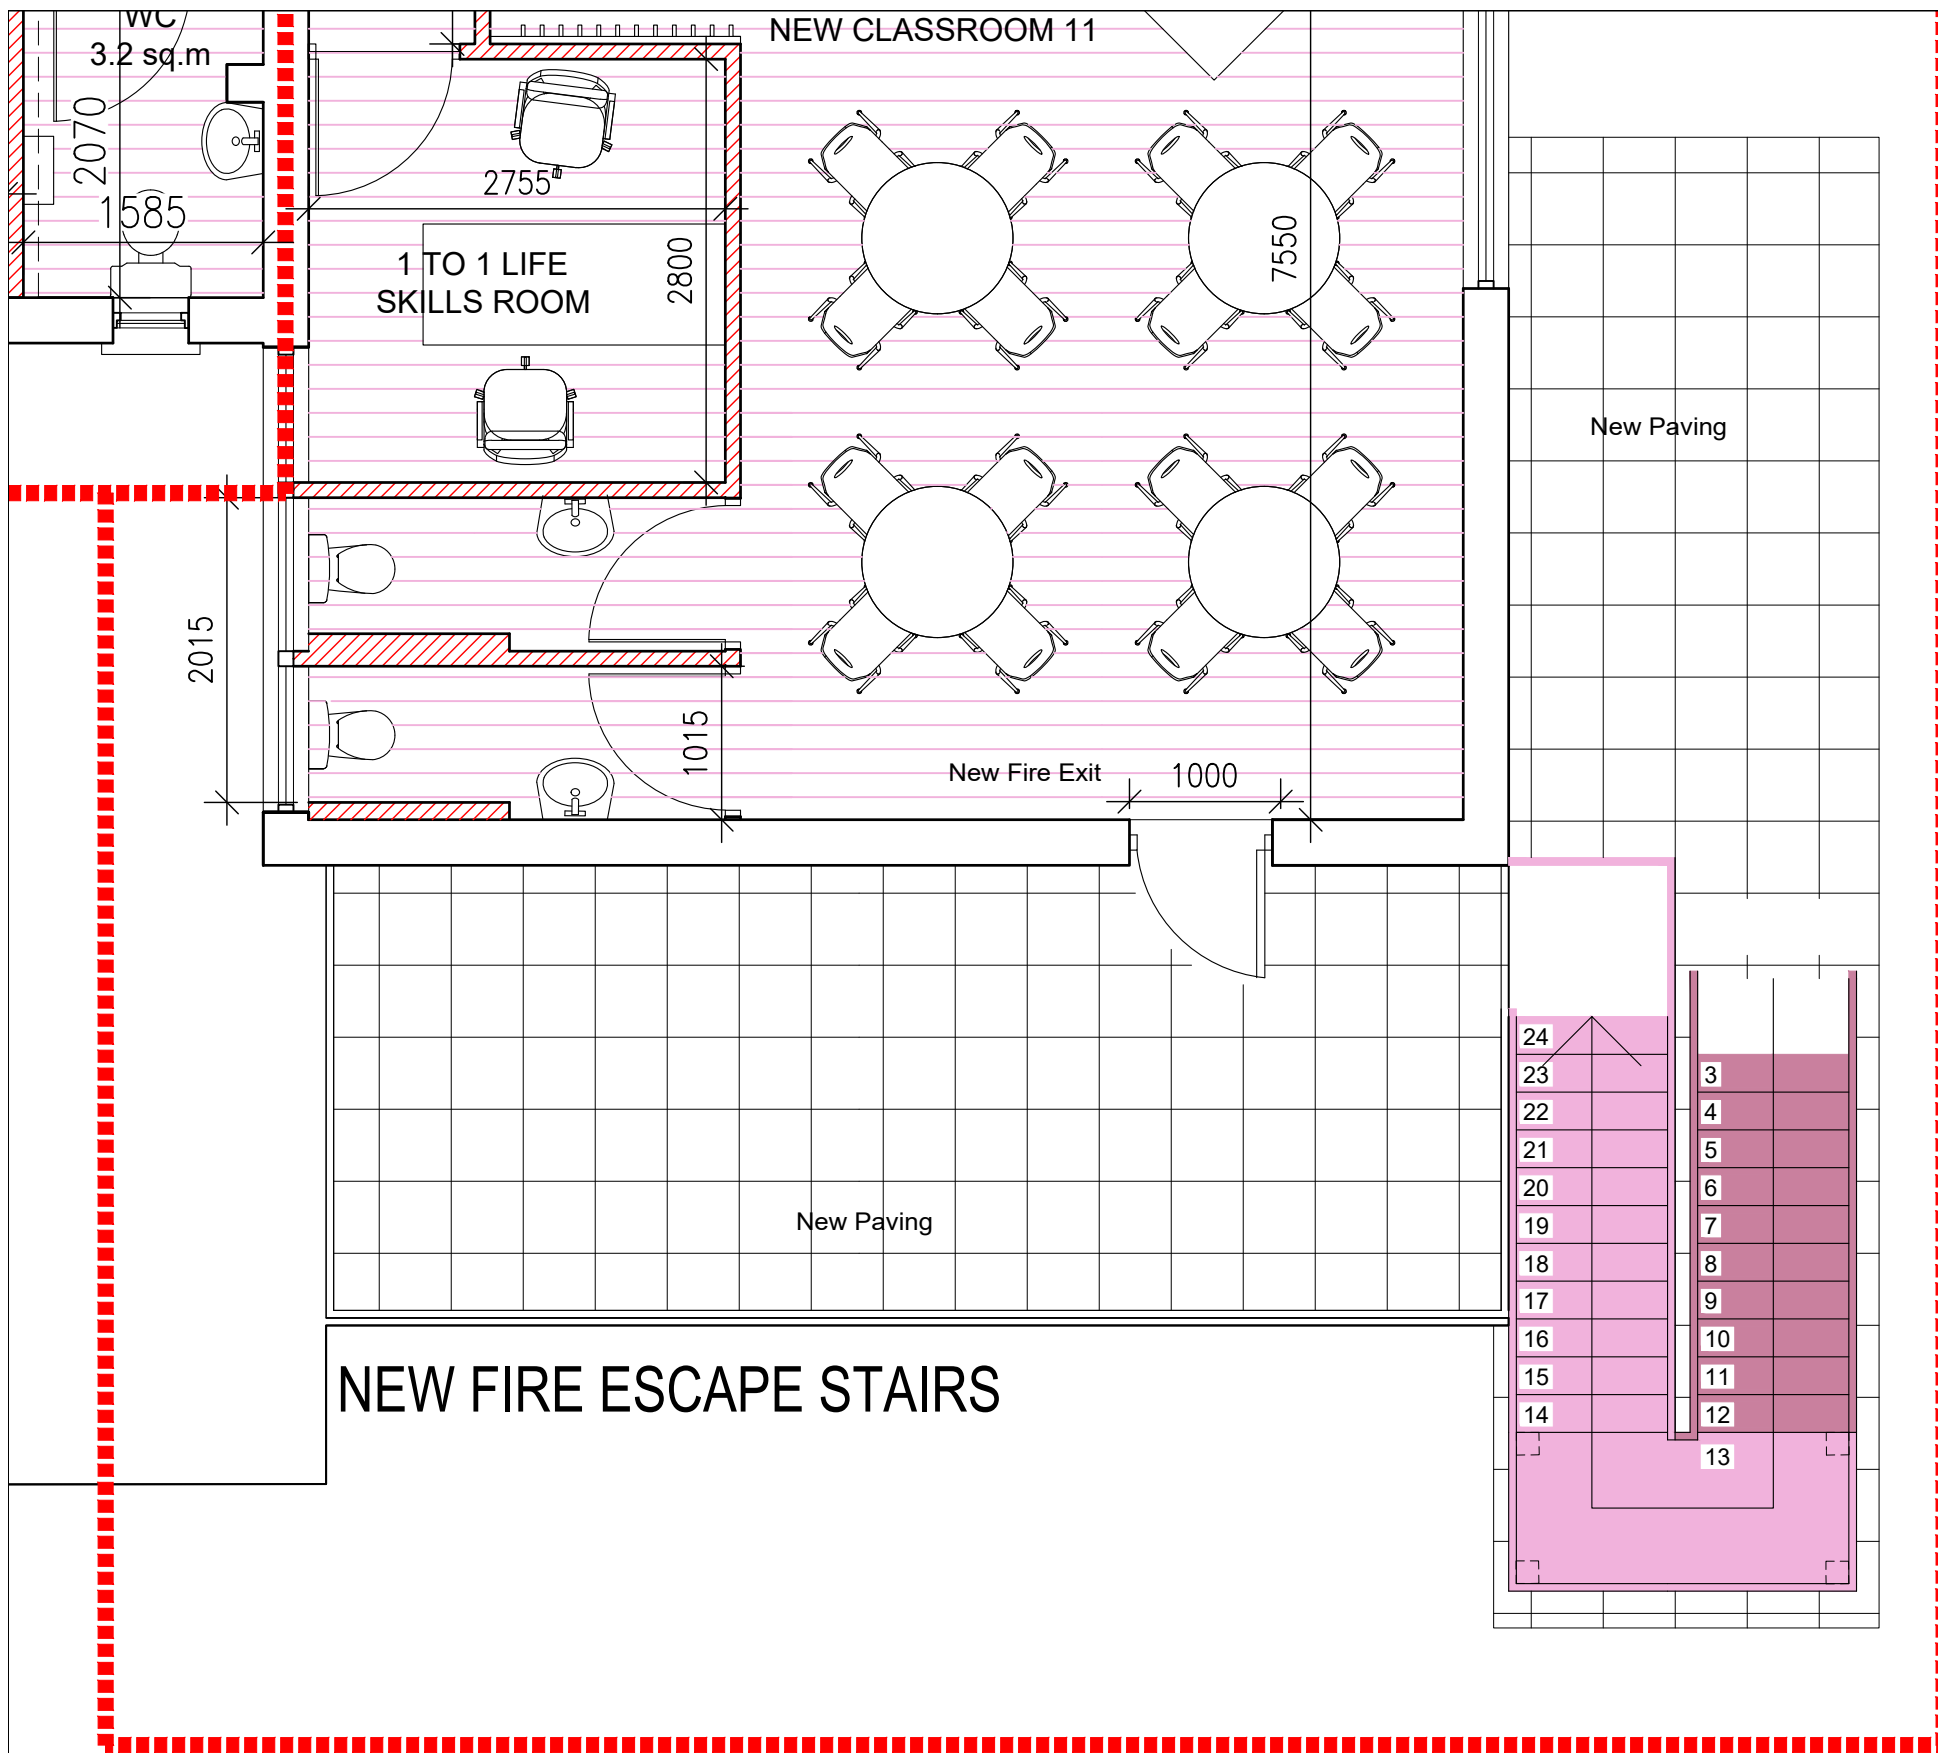

Provide a steel faced fire escape door with panic bolt to existing external door opening, leading to first floor balcony.


Provide new flat roof membrane and paving to balcony flat roof.

Form new opening in flat roof brick parapet wall to facilitate fire escape stairs.

Install new galvanised and painted steel fire escape stairs with concrete infill threads to the end of the building, complete with structural support posts, foundation bases, etc.

Provide concrete base and paviours to pathway serving new fire escape stairs.

Provide signage and ground marking for escape stairs.

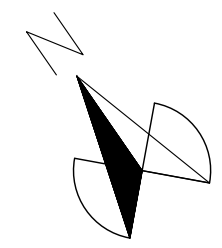

EMERGENCY WORKS 2026

Notes

1. Copyright Reserved
2. Work to figured dimensions only. Do not scale drawing.
3. The contractor is responsible for checking all levels and dimensions on site and shall refer all discrepancies to the Architect
4. Where appropriate, for details of r.c. structure, or mechanical and electrical details, see Engineers drawings
5. Proprietary items shall be fixed in strict accordance with manufacturers instructions.
6. Sizes of proprietary items shall be checked with manufacturer.
7. The contractor shall be responsible for the coordination of structure, finishes and services.

Project			
EMERGENCY / ACCESSIBLE WORK AT ST VINCENTS SPECIAL SCHOOL, DUBLIN 7			
Drawing Title			
PROPOSED FIRST FLOOR- FIRE ESCAPE& NEW LIFE SKILLS ROOM			
Drawing No			
25-04-1 - EW010			
Scale		Rev	Drawn
1:100@A3		-	CQ
		Date	NOV 2025




DOMA Architecture

Architecture & Project Management

www.doma.ie

79 Merrion Square South, Dublin 2,
D02 TN27 tel. 01 507 9990

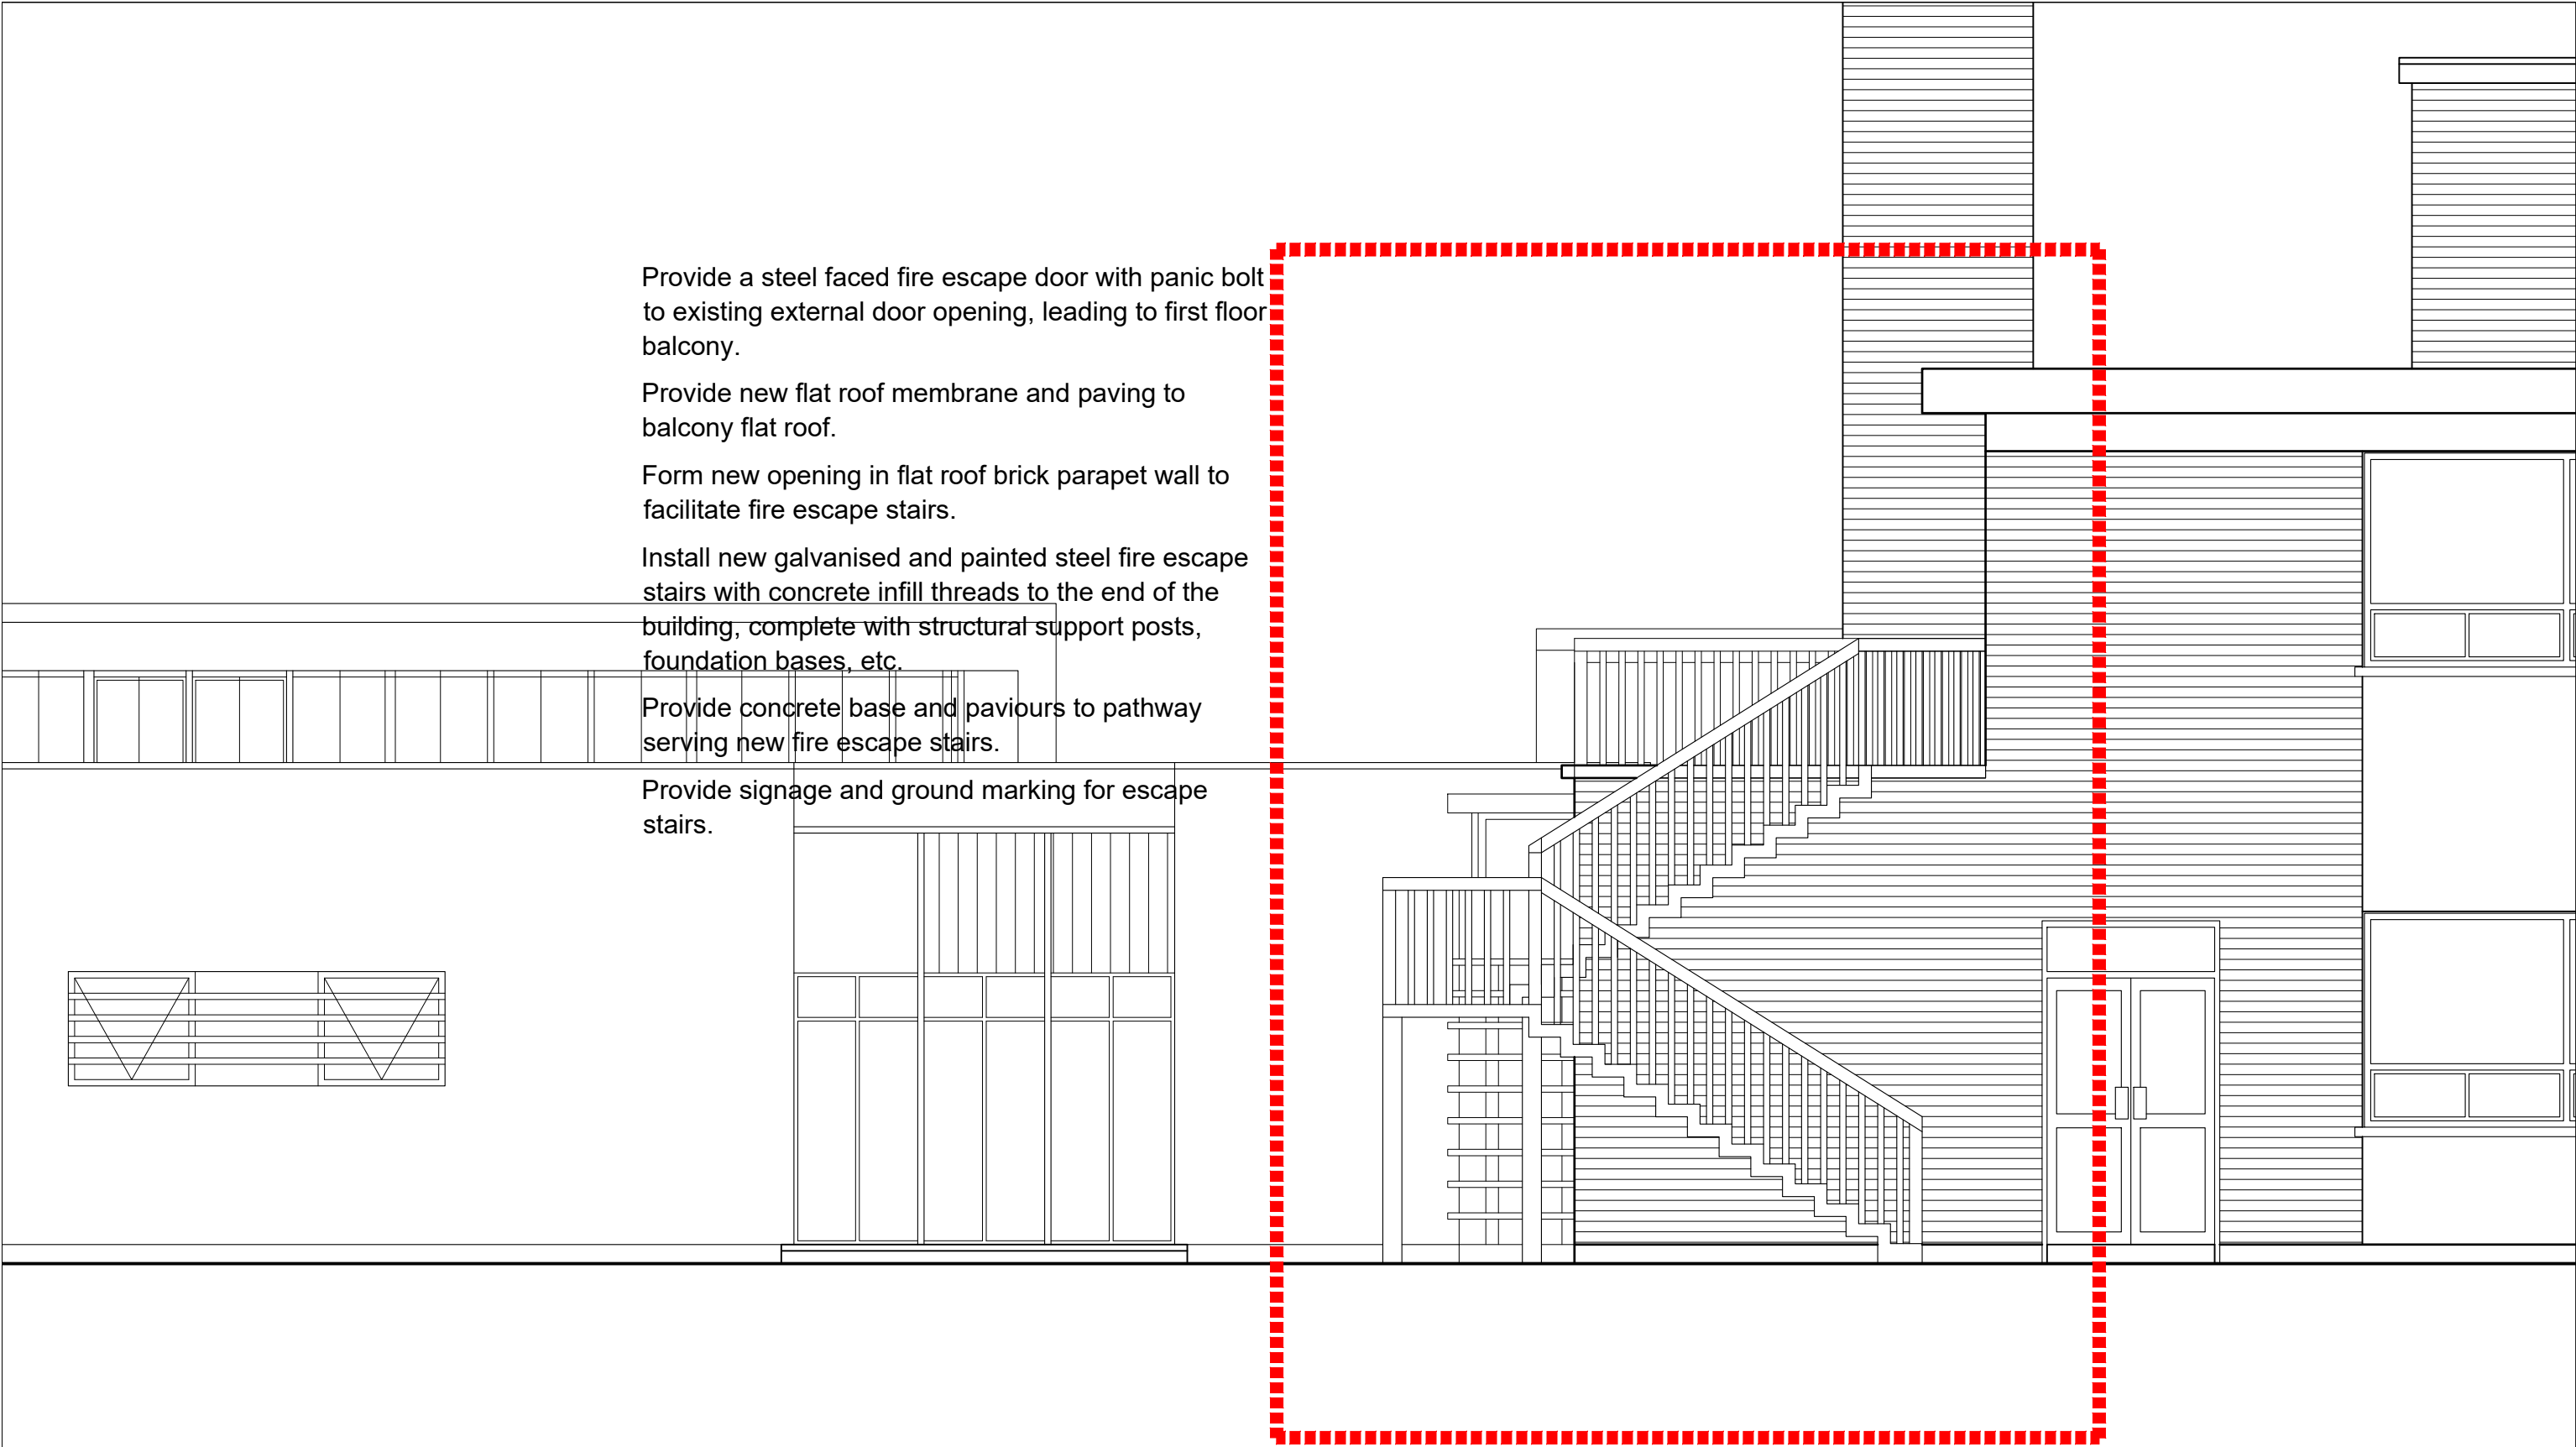

Provide a steel faced fire escape door with panic bolt to existing external door opening, leading to first floor balcony.

Provide new flat roof membrane and paving to balcony flat roof.

Form new opening in flat roof brick parapet wall to facilitate fire escape stairs.

Install new galvanised and painted steel fire escape stairs with concrete infill threads to the end of the building, complete with structural support posts, foundation bases, etc.

Provide concrete base and pavours to pathway serving new fire escape stairs.

Provide signage and ground marking for escape stairs.

EMERGENCY WORKS 2026

Notes

1. Copyright Reserved
2. Work to figured dimensions only. Do not scale drawing.
3. The contractor is responsible for checking all levels and dimensions on site and shall refer all discrepancies to the Architect
4. Where appropriate, for details of r.c. structure, or mechanical and electrical details, see Engineers drawings
5. Proprietary items shall be fixed in strict accordance with manufacturers instructions.
6. Sizes of proprietary items shall be checked with manufacturer.
7. The contractor shall be responsible for the coordination of structure, finishes and services.

Project **EMERGENCY / ACCESSIBLE WORK AT ST VINCENTS SPECIAL SCHOOL, DUBLIN 7**

Drawing Title **PROPOSED FIRE ESCAPE STAIRS - EAST ELEVATIONS**

Drawing No **25-04-1 - EW011**


Scale **1:200@A3** Rev **-** Drawn **CQ** Date **NOV 2025**

DOMA Architecture
Architecture & Project Management



www.doma.ie

79 Merrion Square South, Dublin 2,
D02 TN27 tel. 01 507 9990

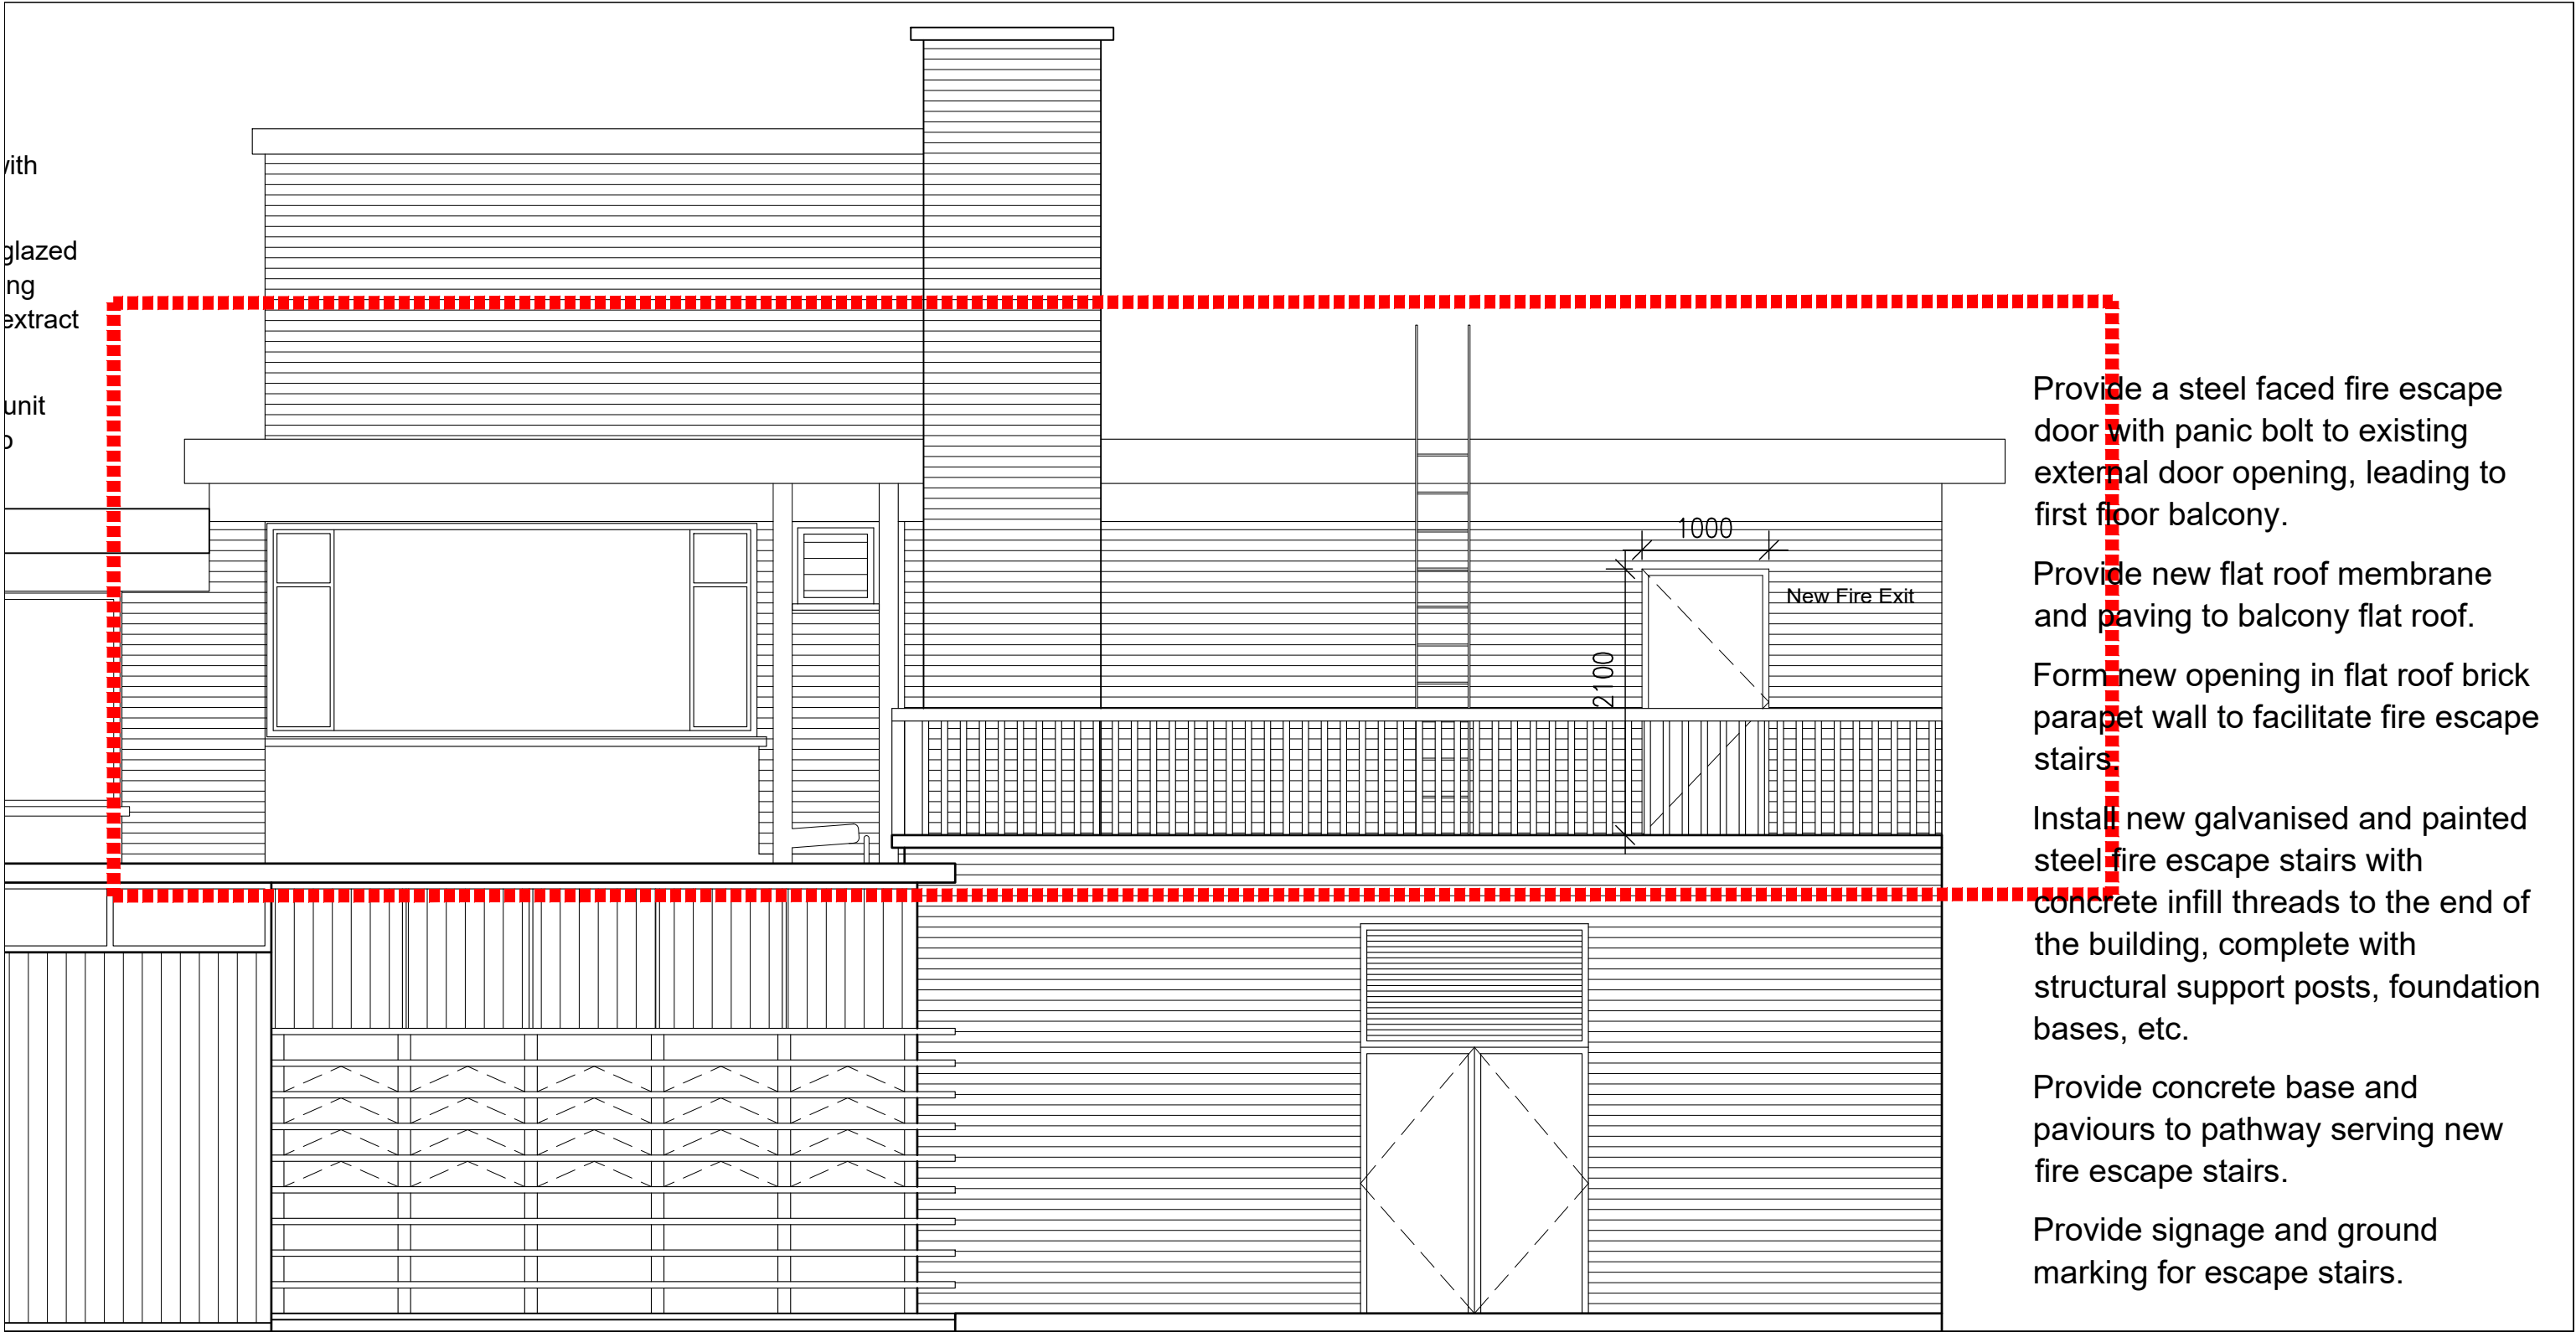

CLASSROOM 11 - NEW LIFE SKILLS ROOM ELEVATION

EMERGENCY WORKS 2026

Notes

1. Copyright Reserved
2. Work to figured dimensions only. Do not scale drawing.
3. The contractor is responsible for checking all levels and dimensions on site and shall refer all discrepancies to the Architect
4. Where appropriate, for details of r.c. structure, or mechanical and electrical details, see Engineers drawings
5. Proprietary items shall be fixed in strict accordance with manufacturers instructions.
6. Sizes of proprietary items shall be checked with manufacturer.
7. The contractor shall be responsible for the coordination of structure, finishes and services.

Project

EMERGENCY / ACCESSIBLE WORK AT
ST VINCENTS SPECIAL SCHOOL, DUBLIN 7

Drawing Title

PROPOSED FIRE ESCAPE STAIRS - SOUTH ELEVATION

Drawing No

25-04-1 - EW012

Scale

1:200@A3

Rev

-

Drawn

CQ

Date

NOV 2025


DOMA Architecture

Architecture & Project Management




www.doma.ie

79 Merrion Square South, Dublin 2,
D02 TN27 tel. 01 507 9990

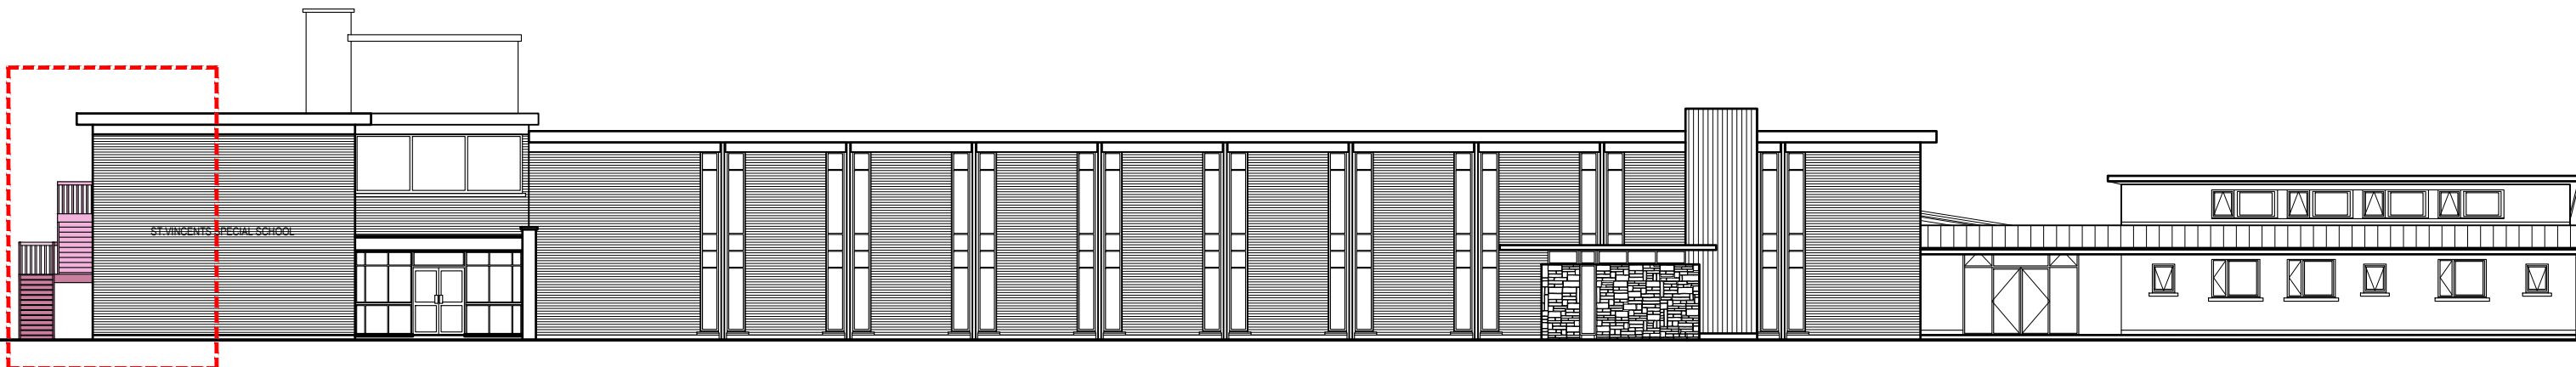

PROPOSED NORTH ELEVATION

PROPOSED EAST ELEVATION

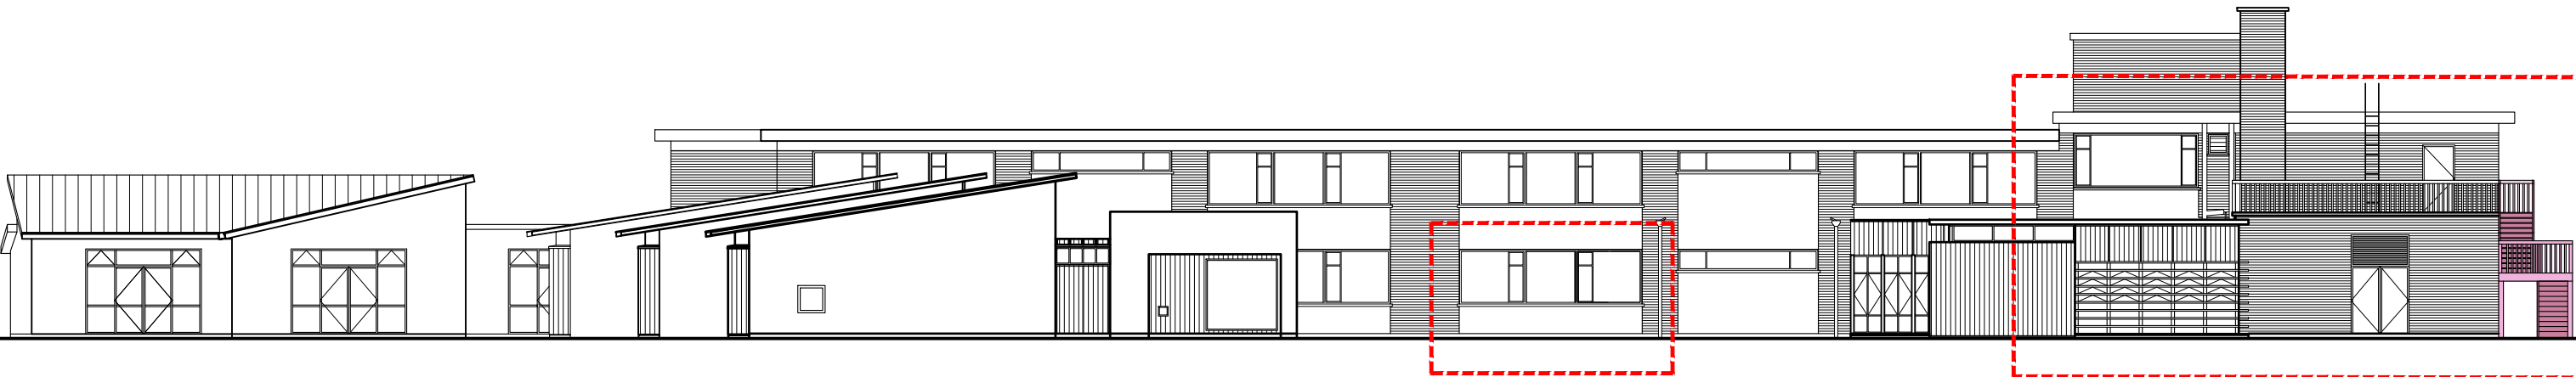

PROPOSED SOUTH ELEVATION

EMERGENCY WORKS 2026

Notes

- 1. Copyright Reserved
- 2. Work to figured dimensions only. Do not scale drawing.
- 3. The contractor is responsible for checking all levels and dimensions on site and shall refer all discrepancies to the Architect
- 4. Where appropriate, for details of r.c. structure, or mechanical and electrical details, see Engineers drawings
- 5. Proprietary items shall be fixed in strict accordance with manufacturers instructions.
- 6. Sizes of proprietary items shall be checked with manufacturer.
- 7. The contractor shall be responsible for the coordination of structure, finishes and services.

Project	EMERGENCY / ACCESSIBLE WORK AT ST VINCENTS SPECIAL SCHOOL, DUBLIN 7		
Drawing Title	PROPOSED NORTH & SOUTH ELEVATIONS		
Drawing No	25-04-1 - EW013		
Scale	1:200@A3	Rev	-
Drawn	CQ	Date	NOV 2025

DOMA Architecture
Architecture & Project Management


www.doma.ie

79 Merrion Square South, Dublin 2,
D02 TN27 tel. 01 507 9990





PROPOSED EAST ELEVATION

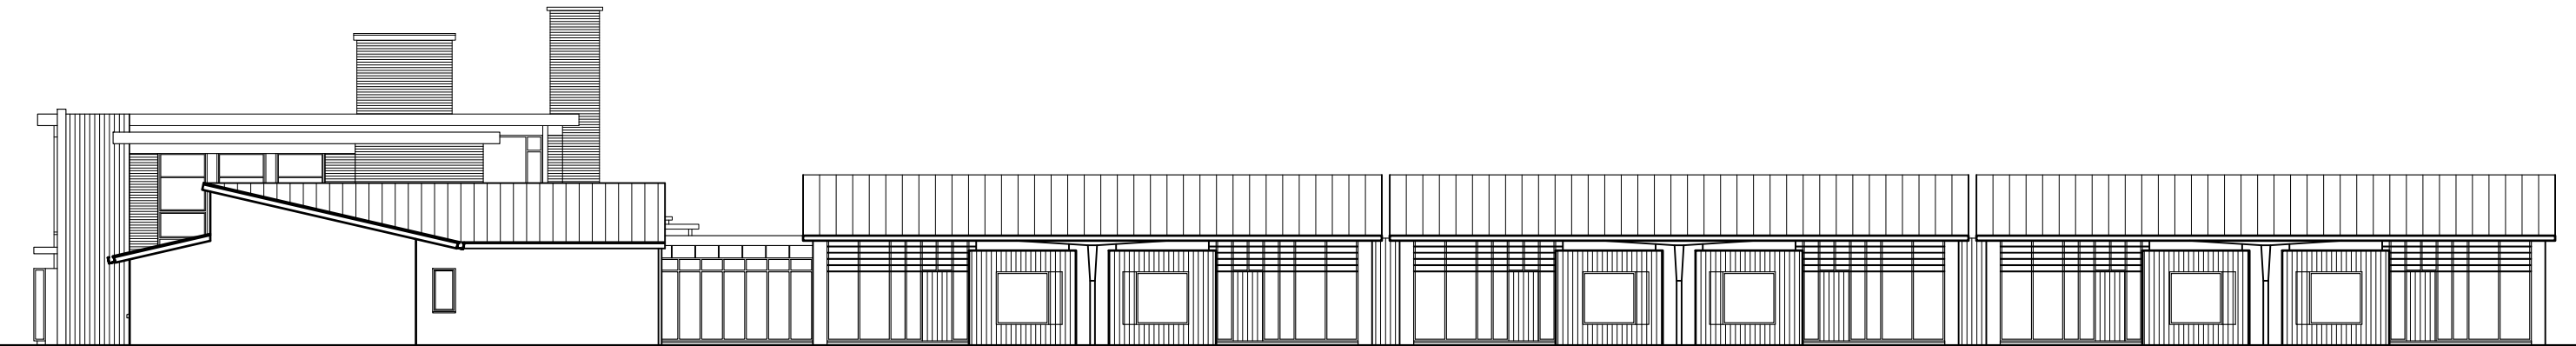

PROPOSED WEST ELEVATION

EMERGENCY WORKS 2026

Notes

- 1. Copyright Reserved
- 2. Work to figured dimensions only. Do not scale drawing.
- 3. The contractor is responsible for checking all levels and dimensions on site and shall refer all discrepancies to the Architect
- 4. Where appropriate, for details of r.c. structure, or mechanical and electrical details, see Engineers drawings
- 5. Proprietary items shall be fixed in strict accordance with manufacturers instructions.
- 6. Sizes of proprietary items shall be checked with manufacturer.
- 7. The contractor shall be responsible for the coordination of structure, finishes and services.

Project		EMERGENCY / ACCESSIBLE WORK AT ST VINCENTS SPECIAL SCHOOL, DUBLIN 7			
Drawing Title		PROPOSED EAST & WEST ELEVATIONS			
Drawing No		25-04-1 - EW014			
Scale	1:200@A3	Rev	-	Drawn	CQ
		Date	NOV 2025		

DOMA Architecture
Architecture & Project Management



www.doma.ie

79 Merrion Square South, Dublin 2,
D02 TN27 tel. 01 507 9990