


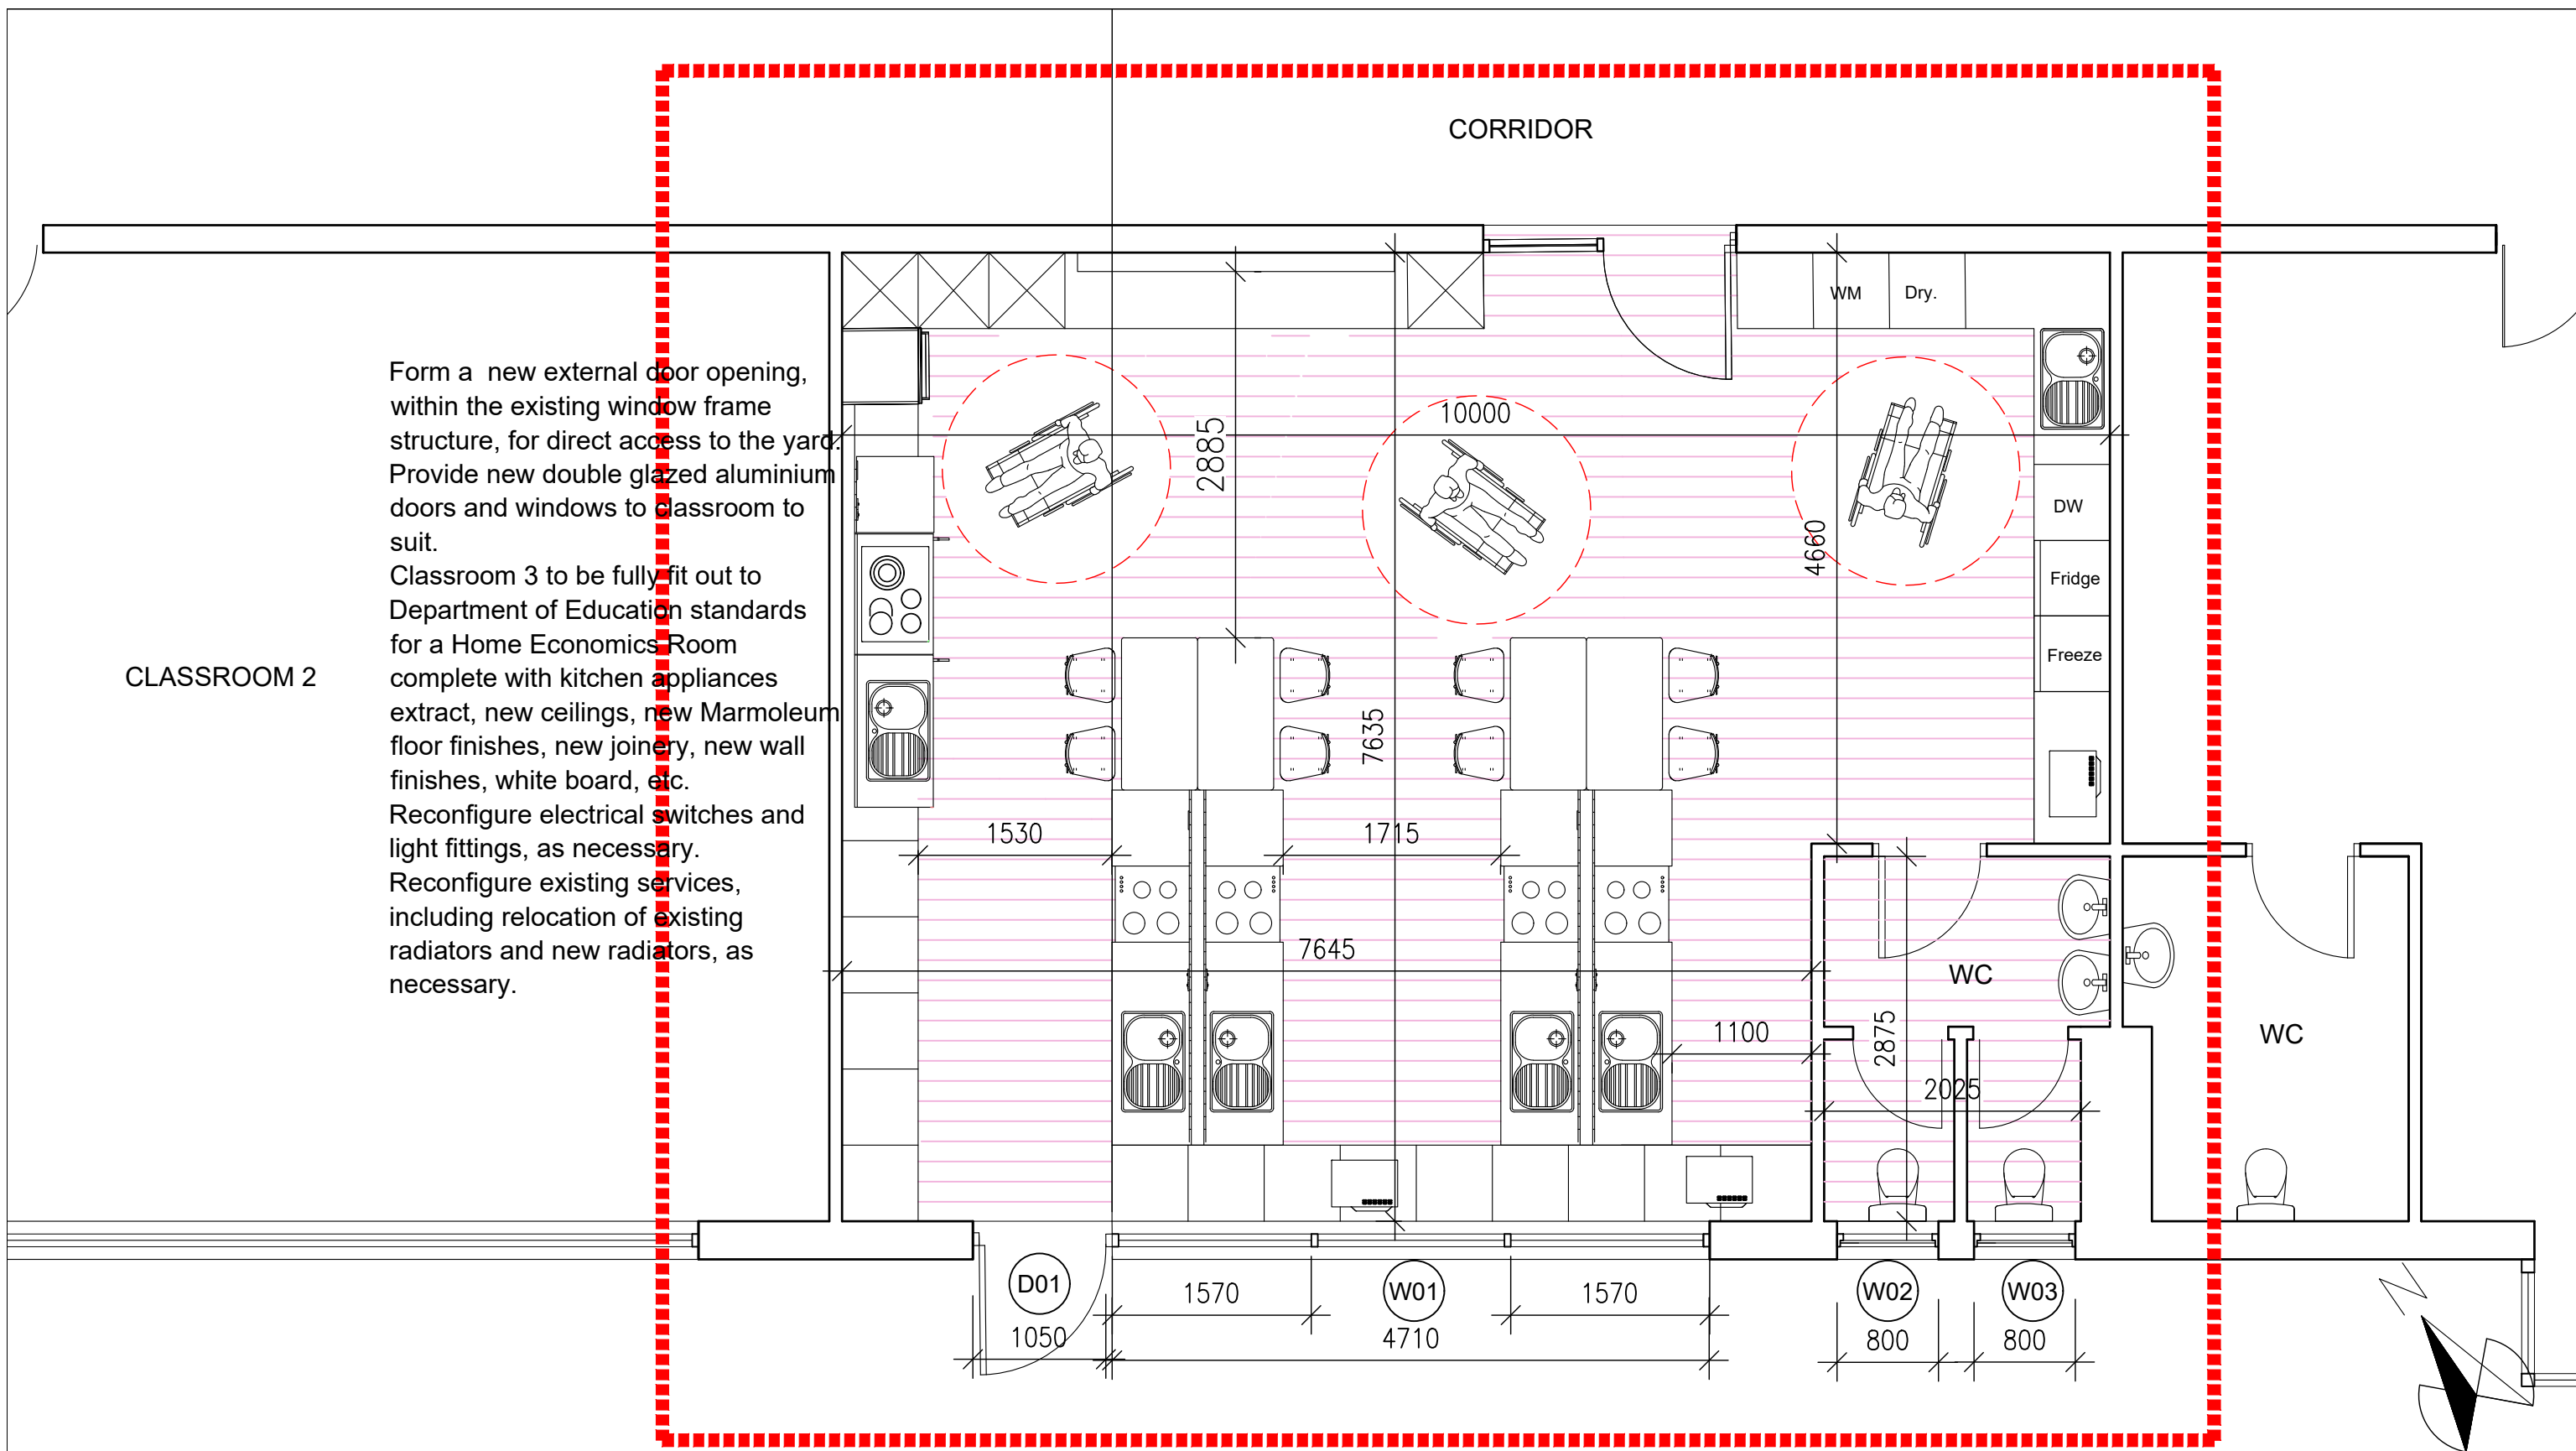

CLASSROOM 3- NEW HOME ECONOMICS ROOM

EMERGENCY WORKS 2026

Notes

1. Copyright Reserved

2. Work to figured dimensions only. Do not scale drawing.

3. The contractor is responsible for checking all levels and dimensions on site and shall refer all discrepancies to the Architect

4. Where appropriate, for details of r.c. structure, or mechanical and electrical details, see Engineers drawings

5. Proprietary items shall be fixed in strict accordance with manufacturers instructions.

6. Sizes of proprietary items shall be checked with manufacturer.

7. The contractor shall be responsible for the coordination of structure, finishes and services.

Project

EMERGENCY / ACCESSIBLE WORK AT
ST VINCENTS SPECIAL SCHOOL, DUBLIN 7

Drawing Title

PROPOSED GROUND FLOOR PLAN - HOME ECONOMICS ROOM

Drawing No

25-04-1 - EW006

Scale

1:50@A3

Rev

-

Drawn

CQ

Date

NOV 2025


DOMA Architecture

Architecture & Project Management



www.doma.ie

79 Merrion Square South, Dublin 2,
D02 TN27 tel. 01 507 9990

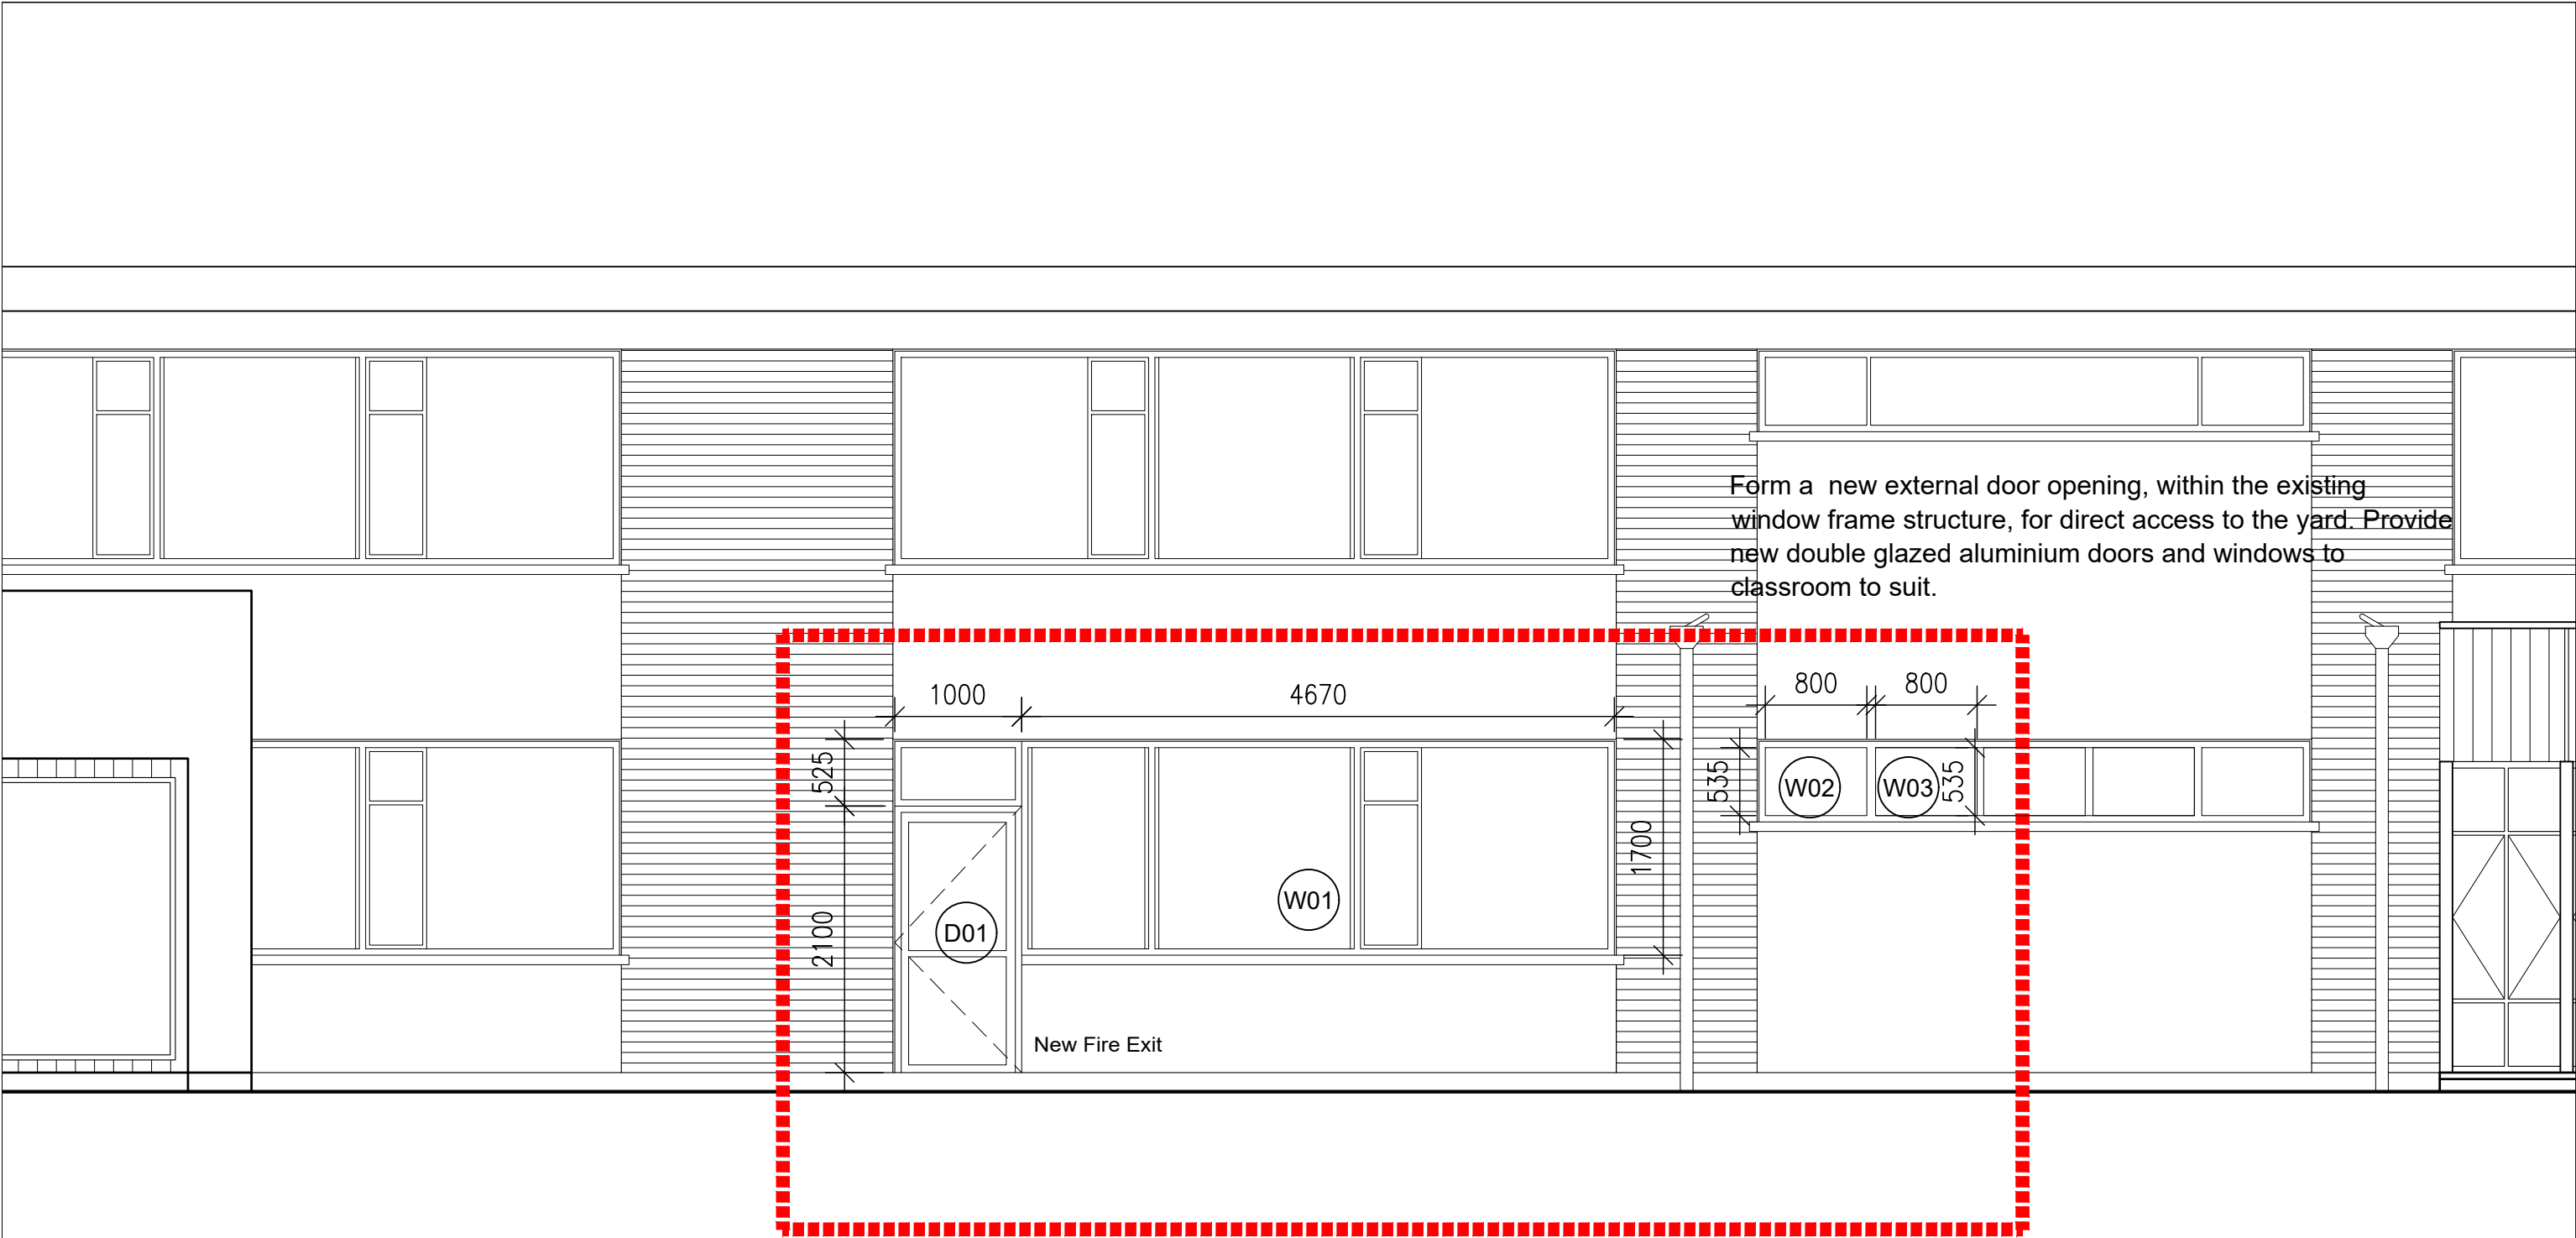

CLASSROOM 3- NEW HOME ECONOMICS ROOM ELEVATION

EMERGENCY WORKS 2026

Notes

1. Copyright Reserved

2. Work to figured dimensions only. Do not scale drawing.

3. The contractor is responsible for checking all levels and dimensions on site and shall refer all discrepancies to the Architect

4. Where appropriate, for details of r.c. structure, or mechanical and electrical details, see Engineers drawings

5. Proprietary items shall be fixed in strict accordance with manufacturers instructions.

6. Sizes of proprietary items shall be checked with manufacturer.

7. The contractor shall be responsible for the coordination of structure, finishes and services.

Project

EMERGENCY / ACCESSIBLE WORK AT
ST VINCENTS SPECIAL SCHOOL, DUBLIN 7

Drawing Title

PROPOSED GROUND FLOOR PLAN - HOME ECONOMICS ROOM

Drawing No

25-04-1 - EW007

Scale

1:50@A3

Rev

-

Drawn

CQ

Date

NOV 2025

DOMA Architecture

Architecture & Project Management




www.doma.ie

79 Merrion Square South, Dublin 2,

D02 TN27 tel. 01 507 9990

79 Merrion Square South, Dublin 2,
D02 TN27 tel. 01 507 9990

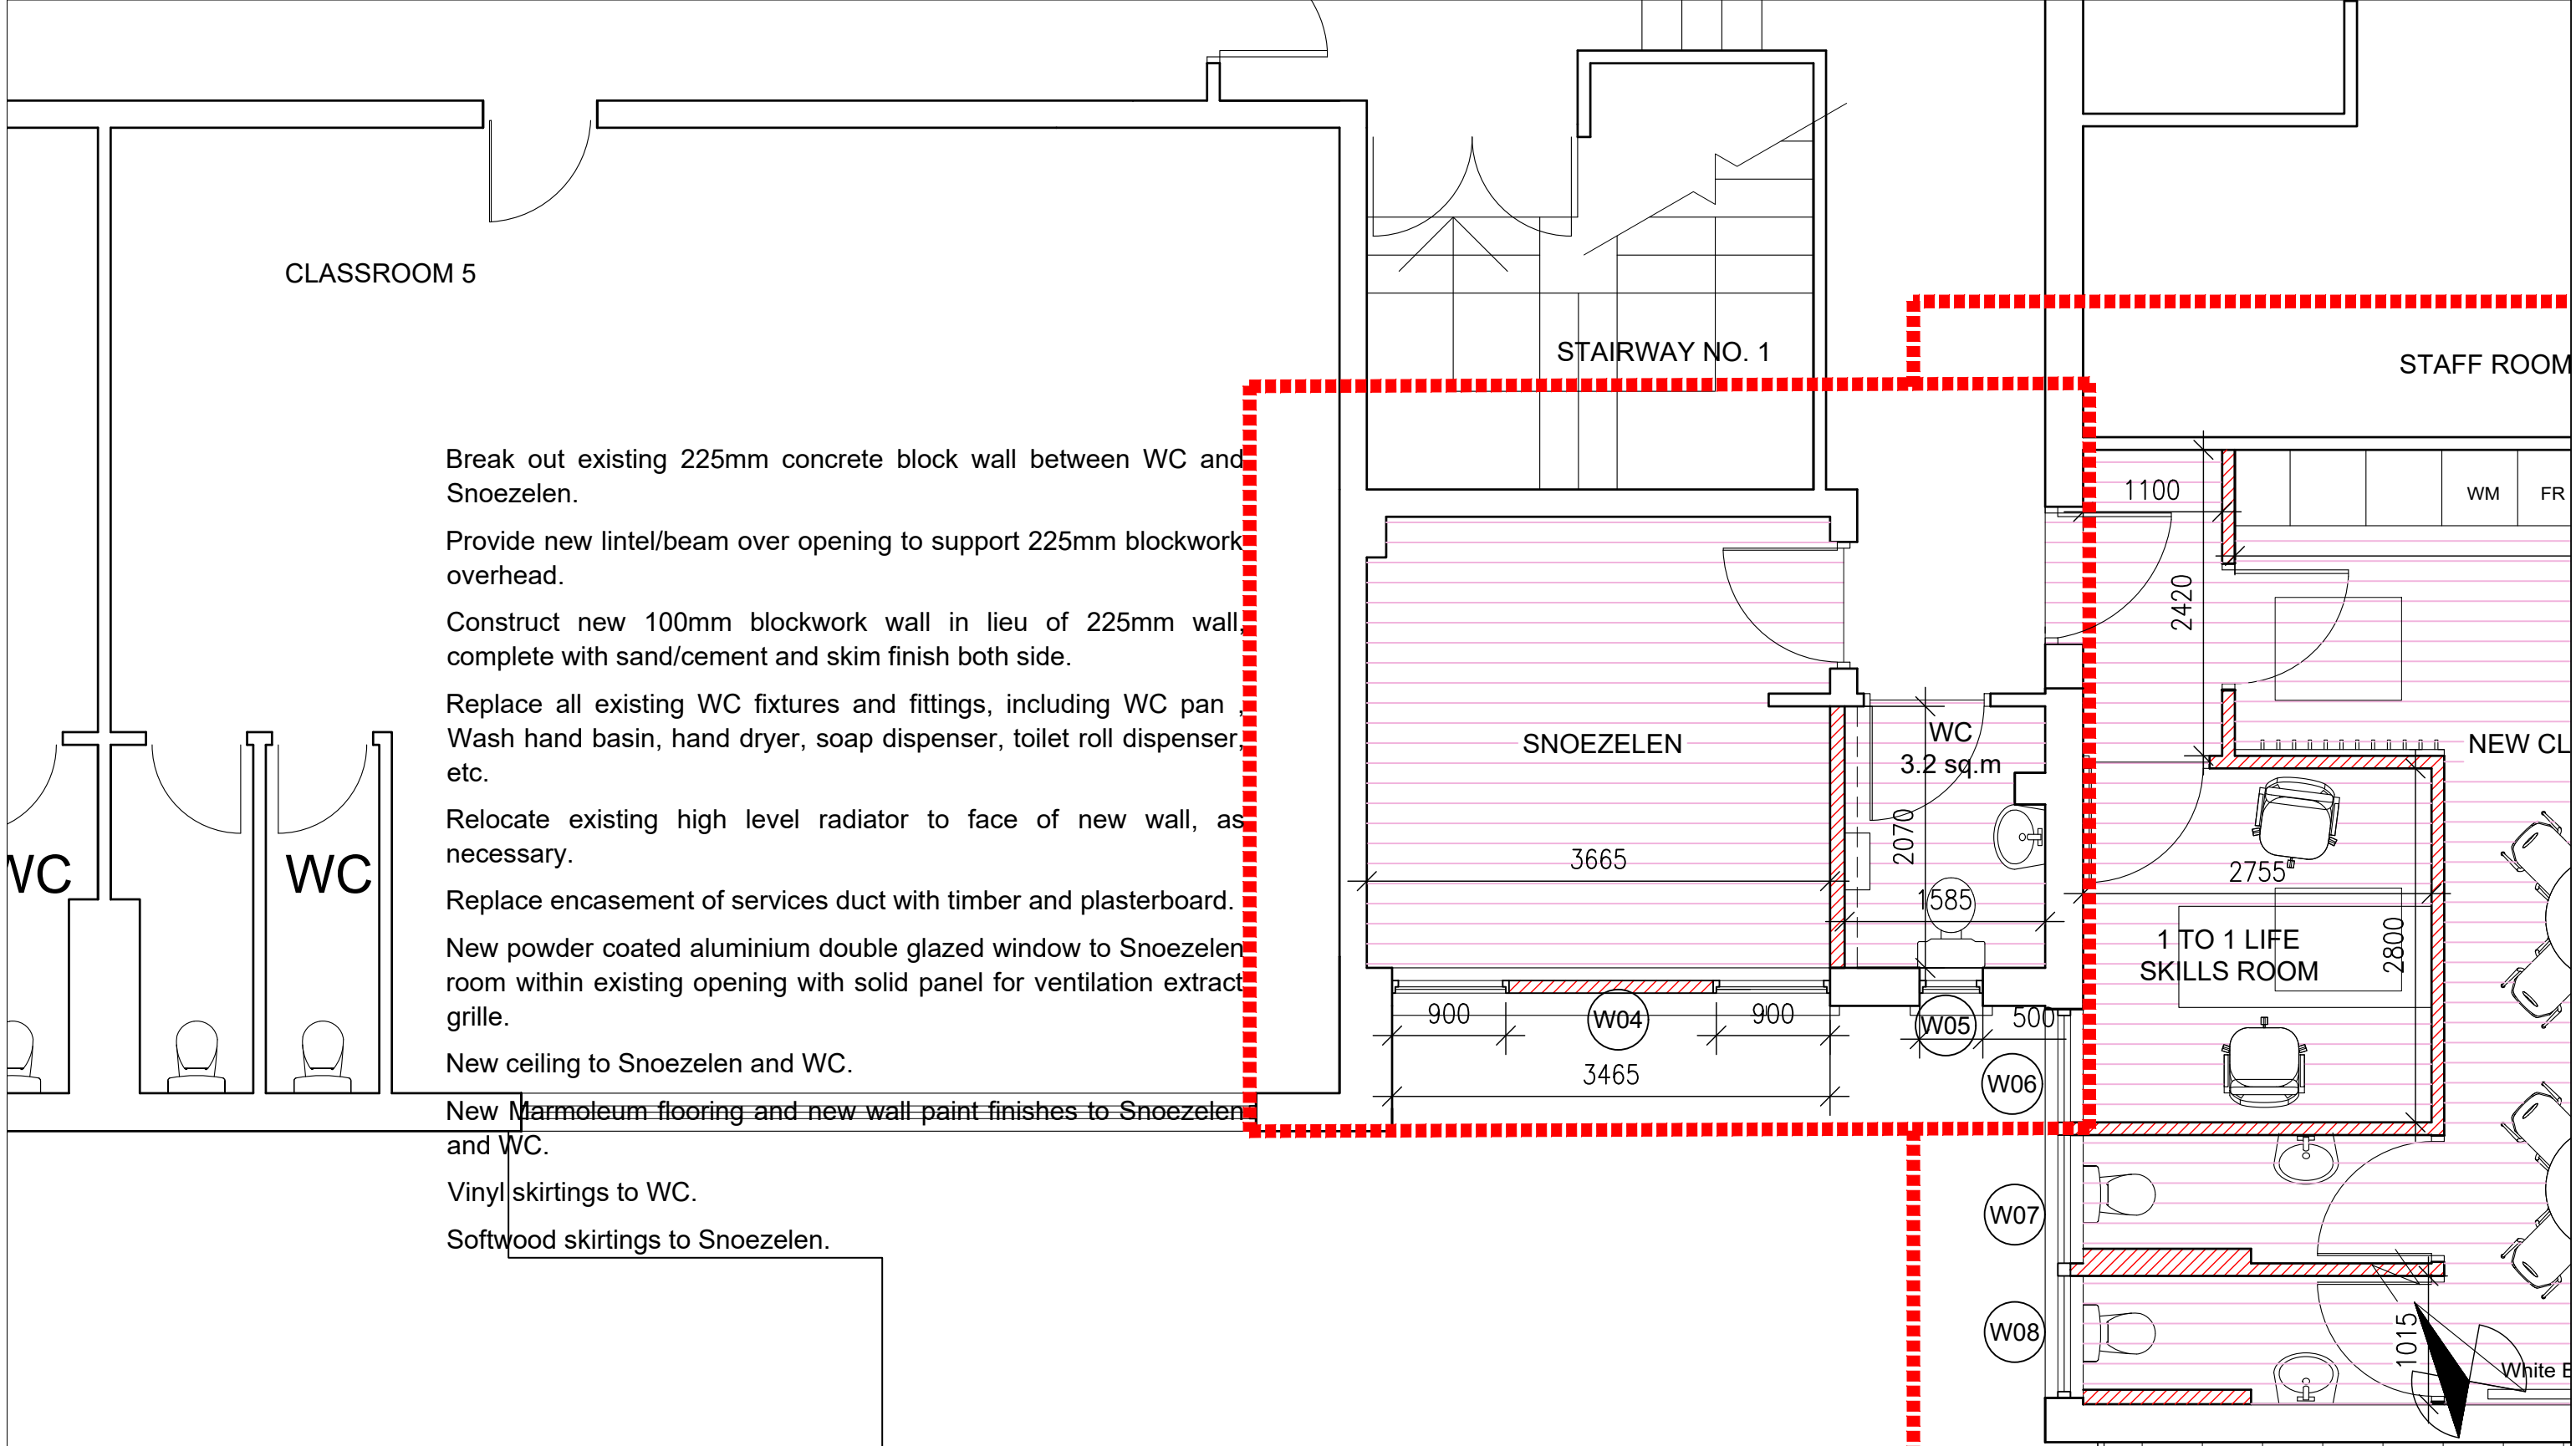

CLASSROOM 11 - NEW LIFE SKILLS & SNOEZELEN &WC

EMERGENCY WORKS 2026

- Notes
- 1. Copyright Reserved
 - 2. Work to figured dimensions only. Do not scale drawing.
 - 3. The contractor is responsible for checking all levels and dimensions on site and shall refer all discrepancies to the Architect
 - 4. Where appropriate, for details of r.c. structure, or mechanical and electrical details, see Engineers drawings
 - 5. Proprietary items shall be fixed in strict accordance with manufacturers instructions.
 - 6. Sizes of proprietary items shall be checked with manufacturer.
 - 7. The contractor shall be responsible for the coordination of structure, finishes and services.

Project	EMERGENCY / ACCESSIBLE WORK AT ST VINCENTS SPECIAL SCHOOL, DUBLIN 7		
Drawing Title	PROPOSED FIRST FLOOR- ACCESSIBLE WC& SNOEZELEN		
Drawing No	25-04-1 - EW008		
Scale	1:50@A3	Rev	-
Drawn	CQ	Date	NOV 2025


DOMA Architecture

Architecture & Project Management



www.doma.ie

79 Merrion Square South, Dublin 2,
D02 TN27 tel. 01 507 9990

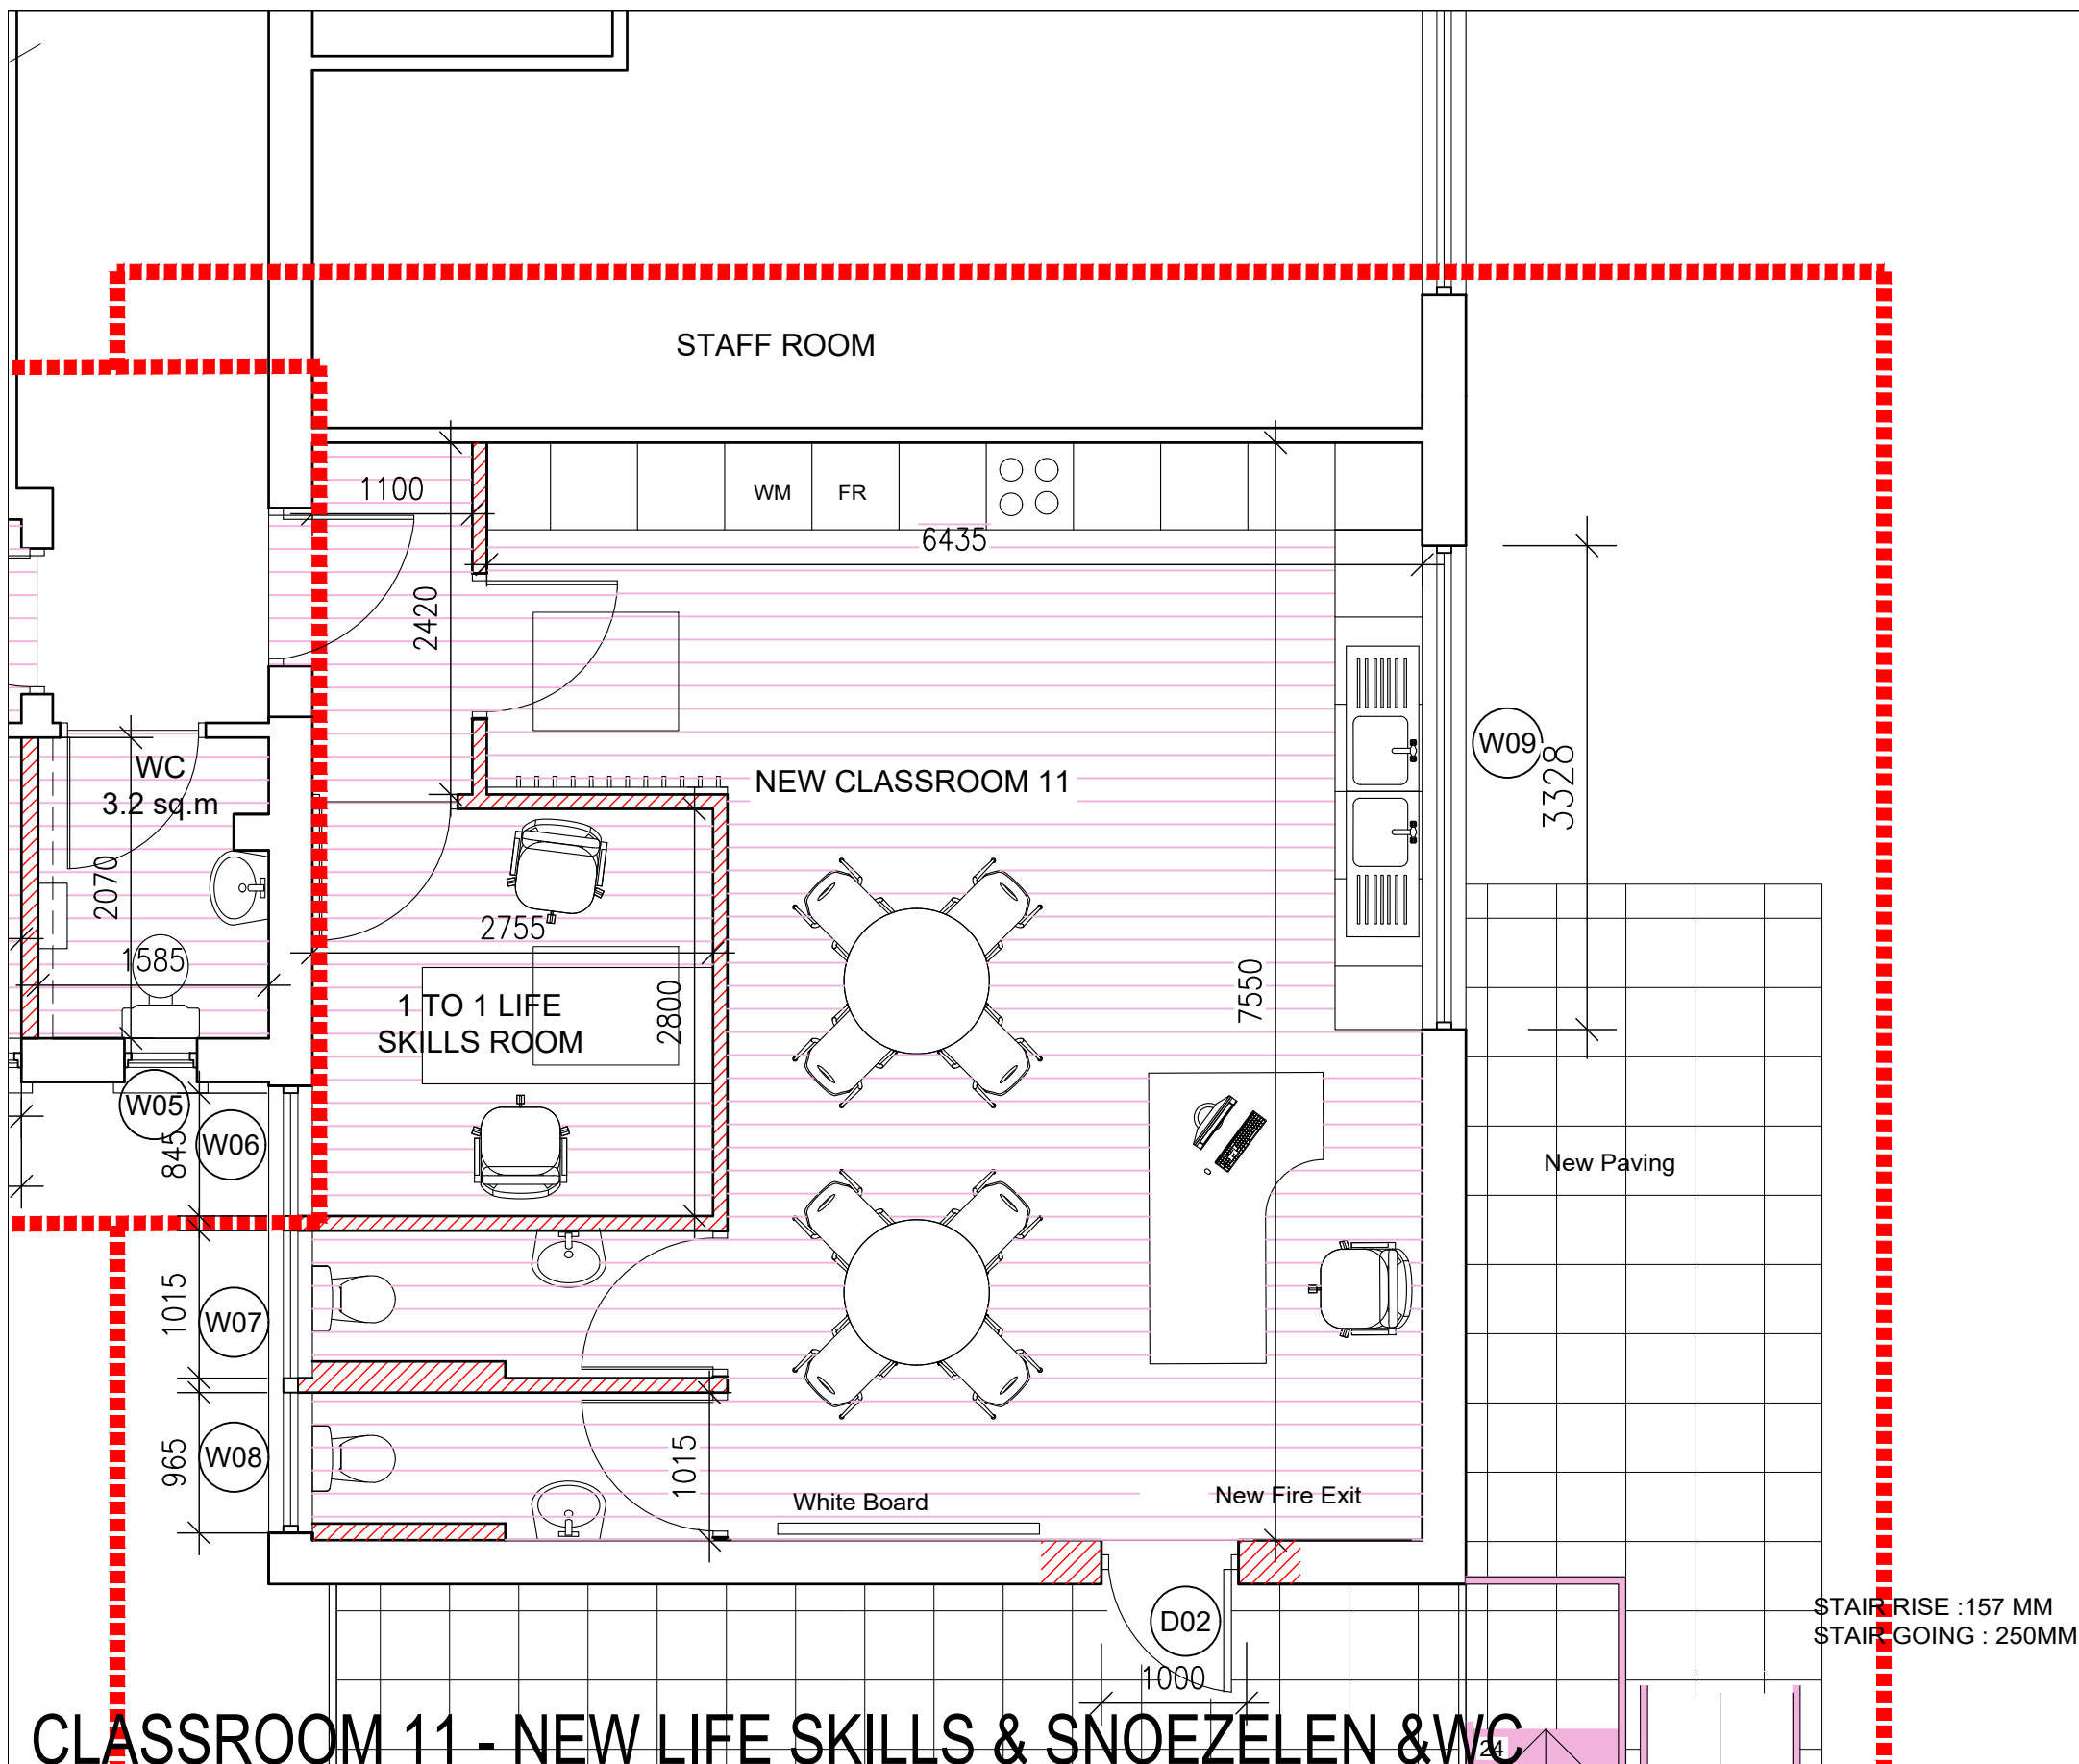

Construct new metal stud partition walls to form one-one life skills room and WC cubicles.


Provide new steel faced fire escape door, with panic bolt and secure locking system to access balcony escape.D01

Provide new double glazed aluminium windows to classroom to suit.W01

Classroom, WC cubicles and one-to-one room to be fully fit out to Department of Education standards, complete with new ceilings, new Marmoleum floor finishes, new doors, new joinery, new wall finishes, white board, etc.

Reconfigure electrical switches and light fittings, as necessary.

Reconfigure existing services, including relocation of existing Classroom 11 radiator and new radiators to new rooms.

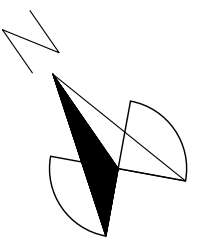

CLASSROOM 11 - NEW LIFE SKILLS & SNOEZELLEN & WC

EMERGENCY WORKS 2026

Notes

1. Copyright Reserved
2. Work to figured dimensions only. Do not scale drawing.
3. The contractor is responsible for checking all levels and dimensions on site and shall refer all discrepancies to the Architect
4. Where appropriate, for details of r.c. structure, or mechanical and electrical details, see Engineers drawings
5. Proprietary items shall be fixed in strict accordance with manufacturers instructions.
6. Sizes of proprietary items shall be checked with manufacturer.
7. The contractor shall be responsible for the coordination of structure, finishes and services.

Project

**EMERGENCY / ACCESSIBLE WORK AT
ST VINCENTS SPECIAL SCHOOL, DUBLIN 7**

Drawing Title

PROPOSED FIRST FLOOR- CLASSROOM & NEW LIFE SKILLS ROOM

Drawing No

25-04-1 - EW009

Scale

1:50@A3

Rev

-

Drawn

CQ

Date


NOV 2025

DOMA Architecture
Architecture & Project Management




www.doma.ie

79 Merrion Square South, Dublin 2,
D02 TN27 tel. 01 507 9990

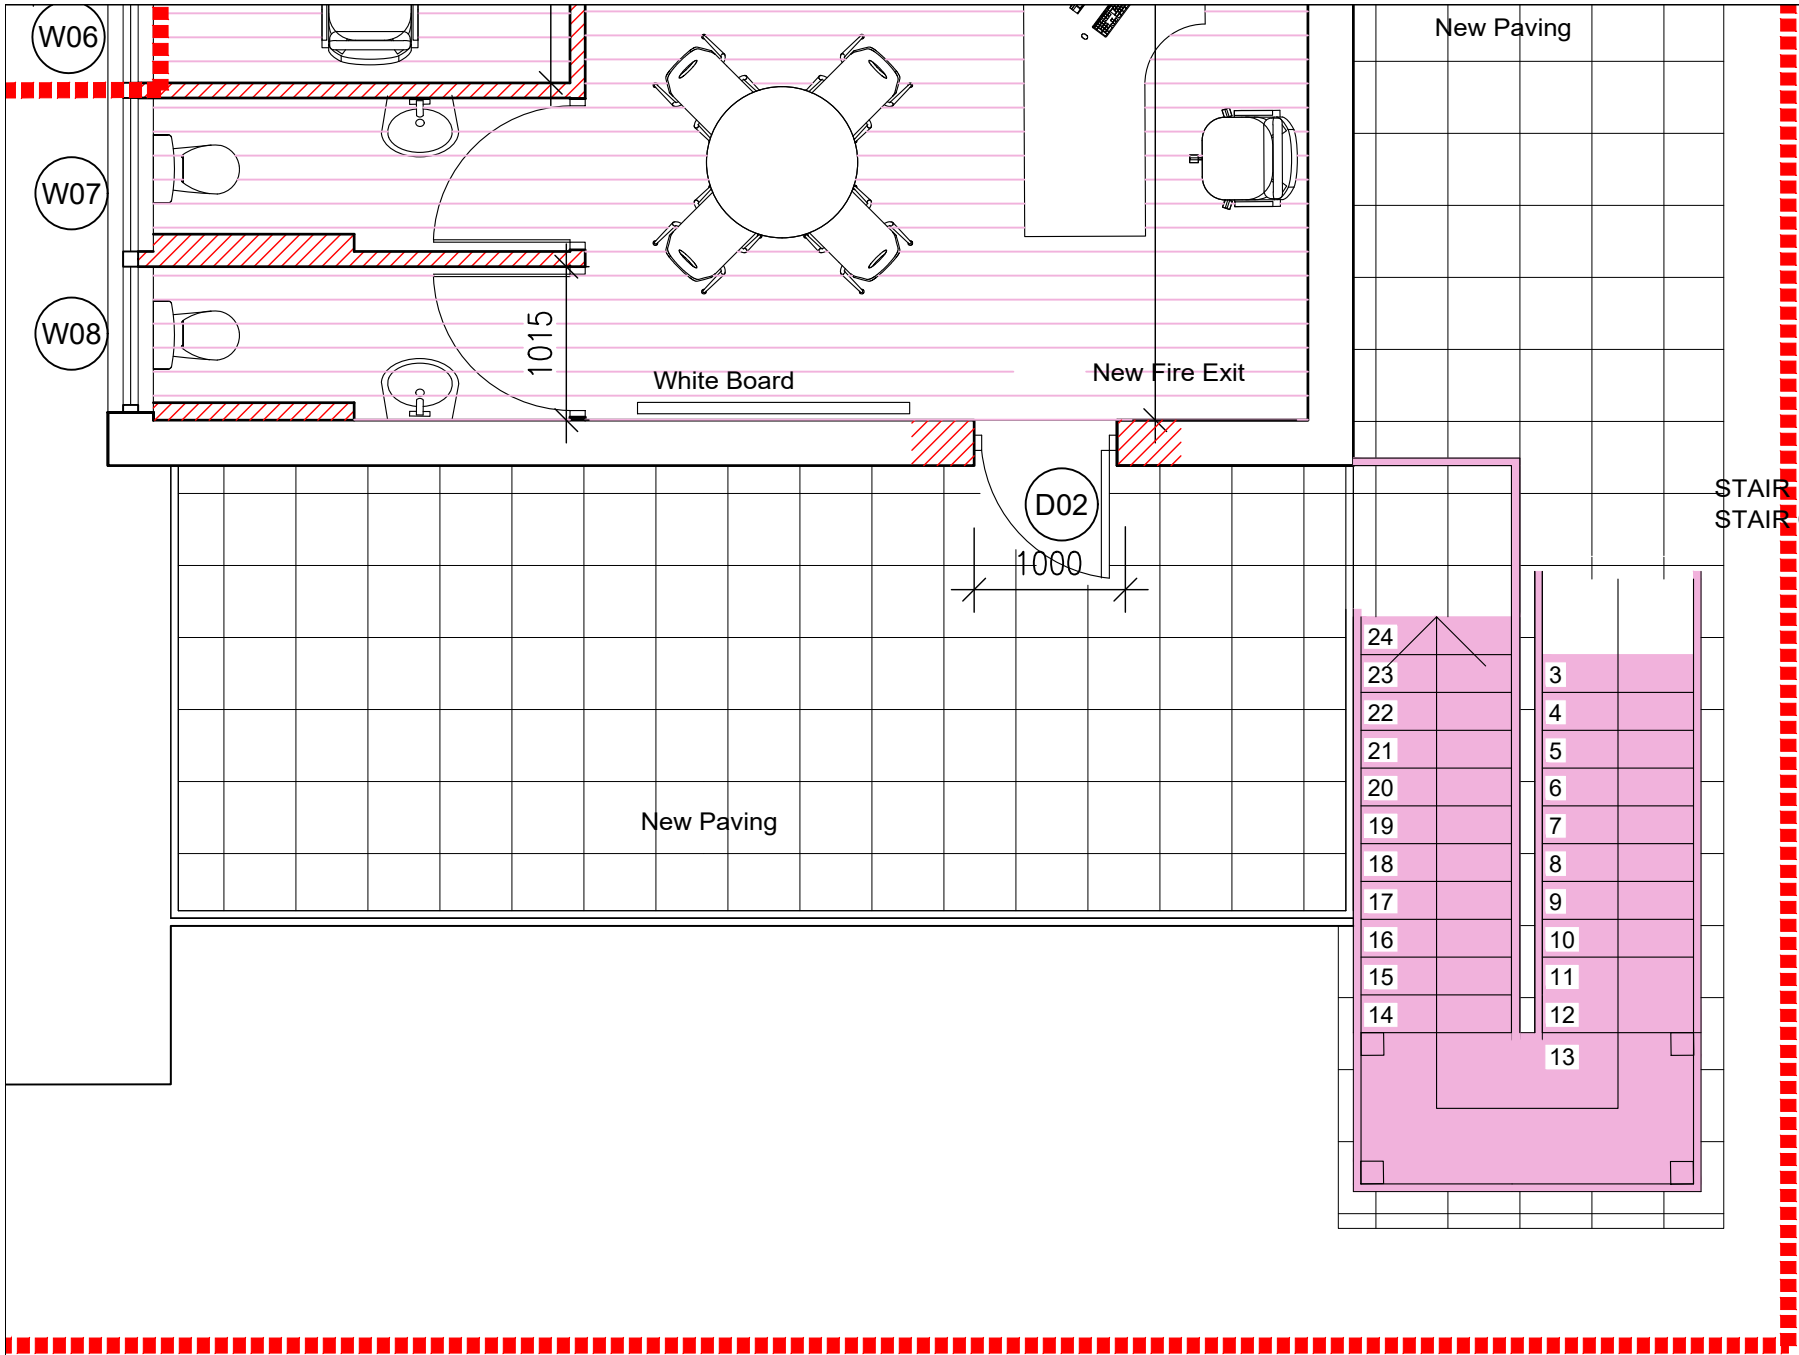

STAIR RISE :157 MM
STAIR GOING : 250MM

- Provide a steel faced fire escape door with panic bolt to existing external door opening, leading to first floor balcony.
- Provide new flat roof membrane and paving to balcony flat roof.
- Form new opening in flat roof brick parapet wall to facilitate fire escape stairs.
- Install new galvanised and painted steel fire escape stairs with concrete infill threads to the end of the building, complete with structural support posts, foundation bases, etc.
- Provide concrete base and paviours to pathway serving new fire escape stairs.
- Provide signage and ground marking for escape stairs.

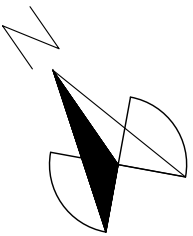

NEW FIRE ESCAPE STAIRS

EMERGENCY WORKS 2026

Notes

- 1. Copyright Reserved
- 2. Work to figured dimensions only. Do not scale drawing.
- 3. The contractor is responsible for checking all levels and dimensions on site and shall refer all discrepancies to the Architect
- 4. Where appropriate, for details of r.c. structure, or mechanical and electrical details, see Engineers drawings
- 5. Proprietary items shall be fixed in strict accordance with manufacturers instructions.
- 6. Sizes of proprietary items shall be checked with manufacturer.
- 7. The contractor shall be responsible for the coordination of structure, finishes and services.


Project	EMERGENCY / ACCESSIBLE WORK AT ST VINCENTS SPECIAL SCHOOL, DUBLIN 7		
Drawing Title	PROPOSED FIRST FLOOR- FIRE ESCAPE STAIRS		
Drawing No	25-04-1 - EW010		
Scale	1:100@A3	Rev	-
Drawn	CQ	Date	NOV 2025

DOMA Architecture
Architecture & Project Management



www.doma.ie
79 Merrion Square South, Dublin 2,
D02 TN27 tel. 01 507 9990

- Provide a steel faced fire escape door with panic bolt to existing external door opening, leading to first floor balcony.
- Provide new flat roof membrane and paving to balcony flat roof.
- Form new opening in flat roof brick parapet wall to facilitate fire escape stairs.
- Install new galvanised and painted steel fire escape stairs with concrete infill threads to the end of the building, complete with structural support posts, foundation bases, etc.
- Provide concrete base and pavours to pathway serving new fire escape stairs.
- Provide signage and ground marking for escape stairs.

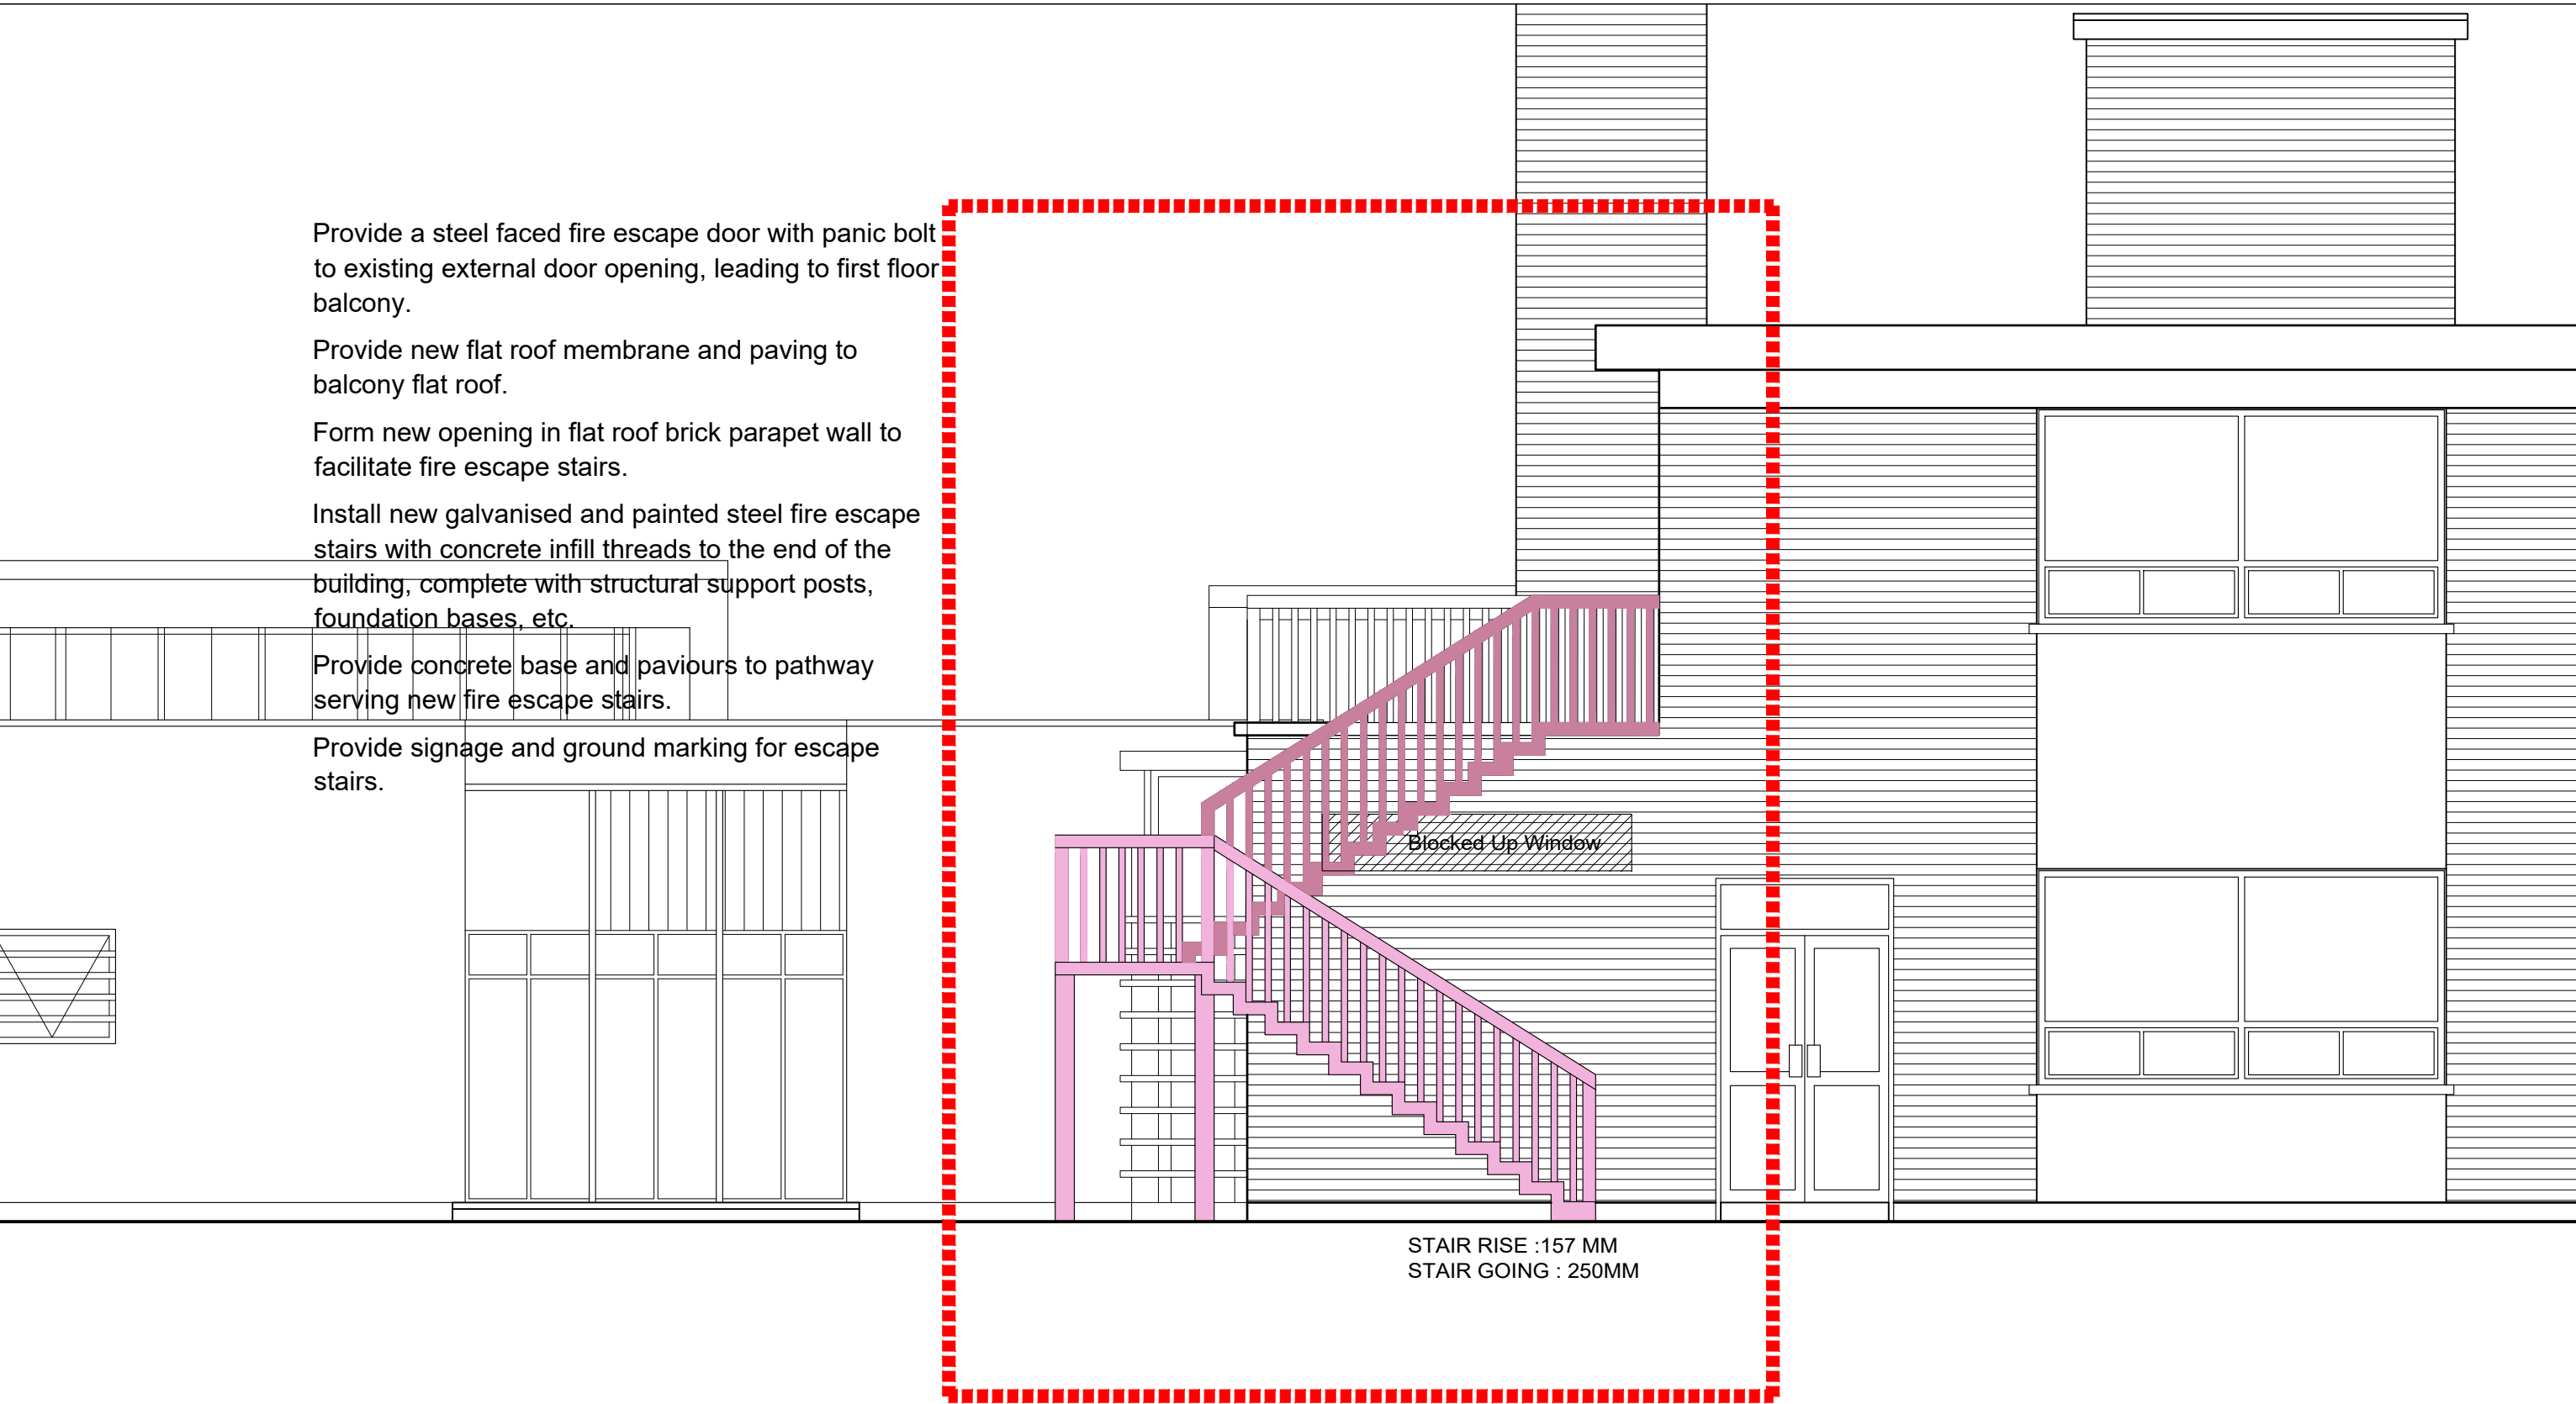

PROPOSED FIRE ESCAPE STAIRS - EAST ELEVATION

EMERGENCY WORKS 2026

Notes

1. Copyright Reserved

2. Work to figured dimensions only. Do not scale drawing.

3. The contractor is responsible for checking all levels and dimensions on site and shall refer all discrepancies to the Architect

4. Where appropriate, for details of r.c. structure, or mechanical and electrical details, see Engineers drawings

5. Proprietary items shall be fixed in strict accordance with manufacturers instructions.

6. Sizes of proprietary items shall be checked with manufacturer.

7. The contractor shall be responsible for the coordination of structure, finishes and services.

Project

EMERGENCY / ACCESSIBLE WORK AT
ST VINCENTS SPECIAL SCHOOL, DUBLIN 7

Drawing Title

PROPOSED FIRE ESCAPE STAIRS - EAST ELEVATIONS

Drawing No

25-04-1 - EW011

Scale

1:50@A3

Rev

-

Drawn

CQ

Date

NOV 2025


DOMA Architecture

Architecture & Project Management



www.doma.ie

79 Merrion Square South, Dublin 2,
D02 TN27 tel. 01 507 9990

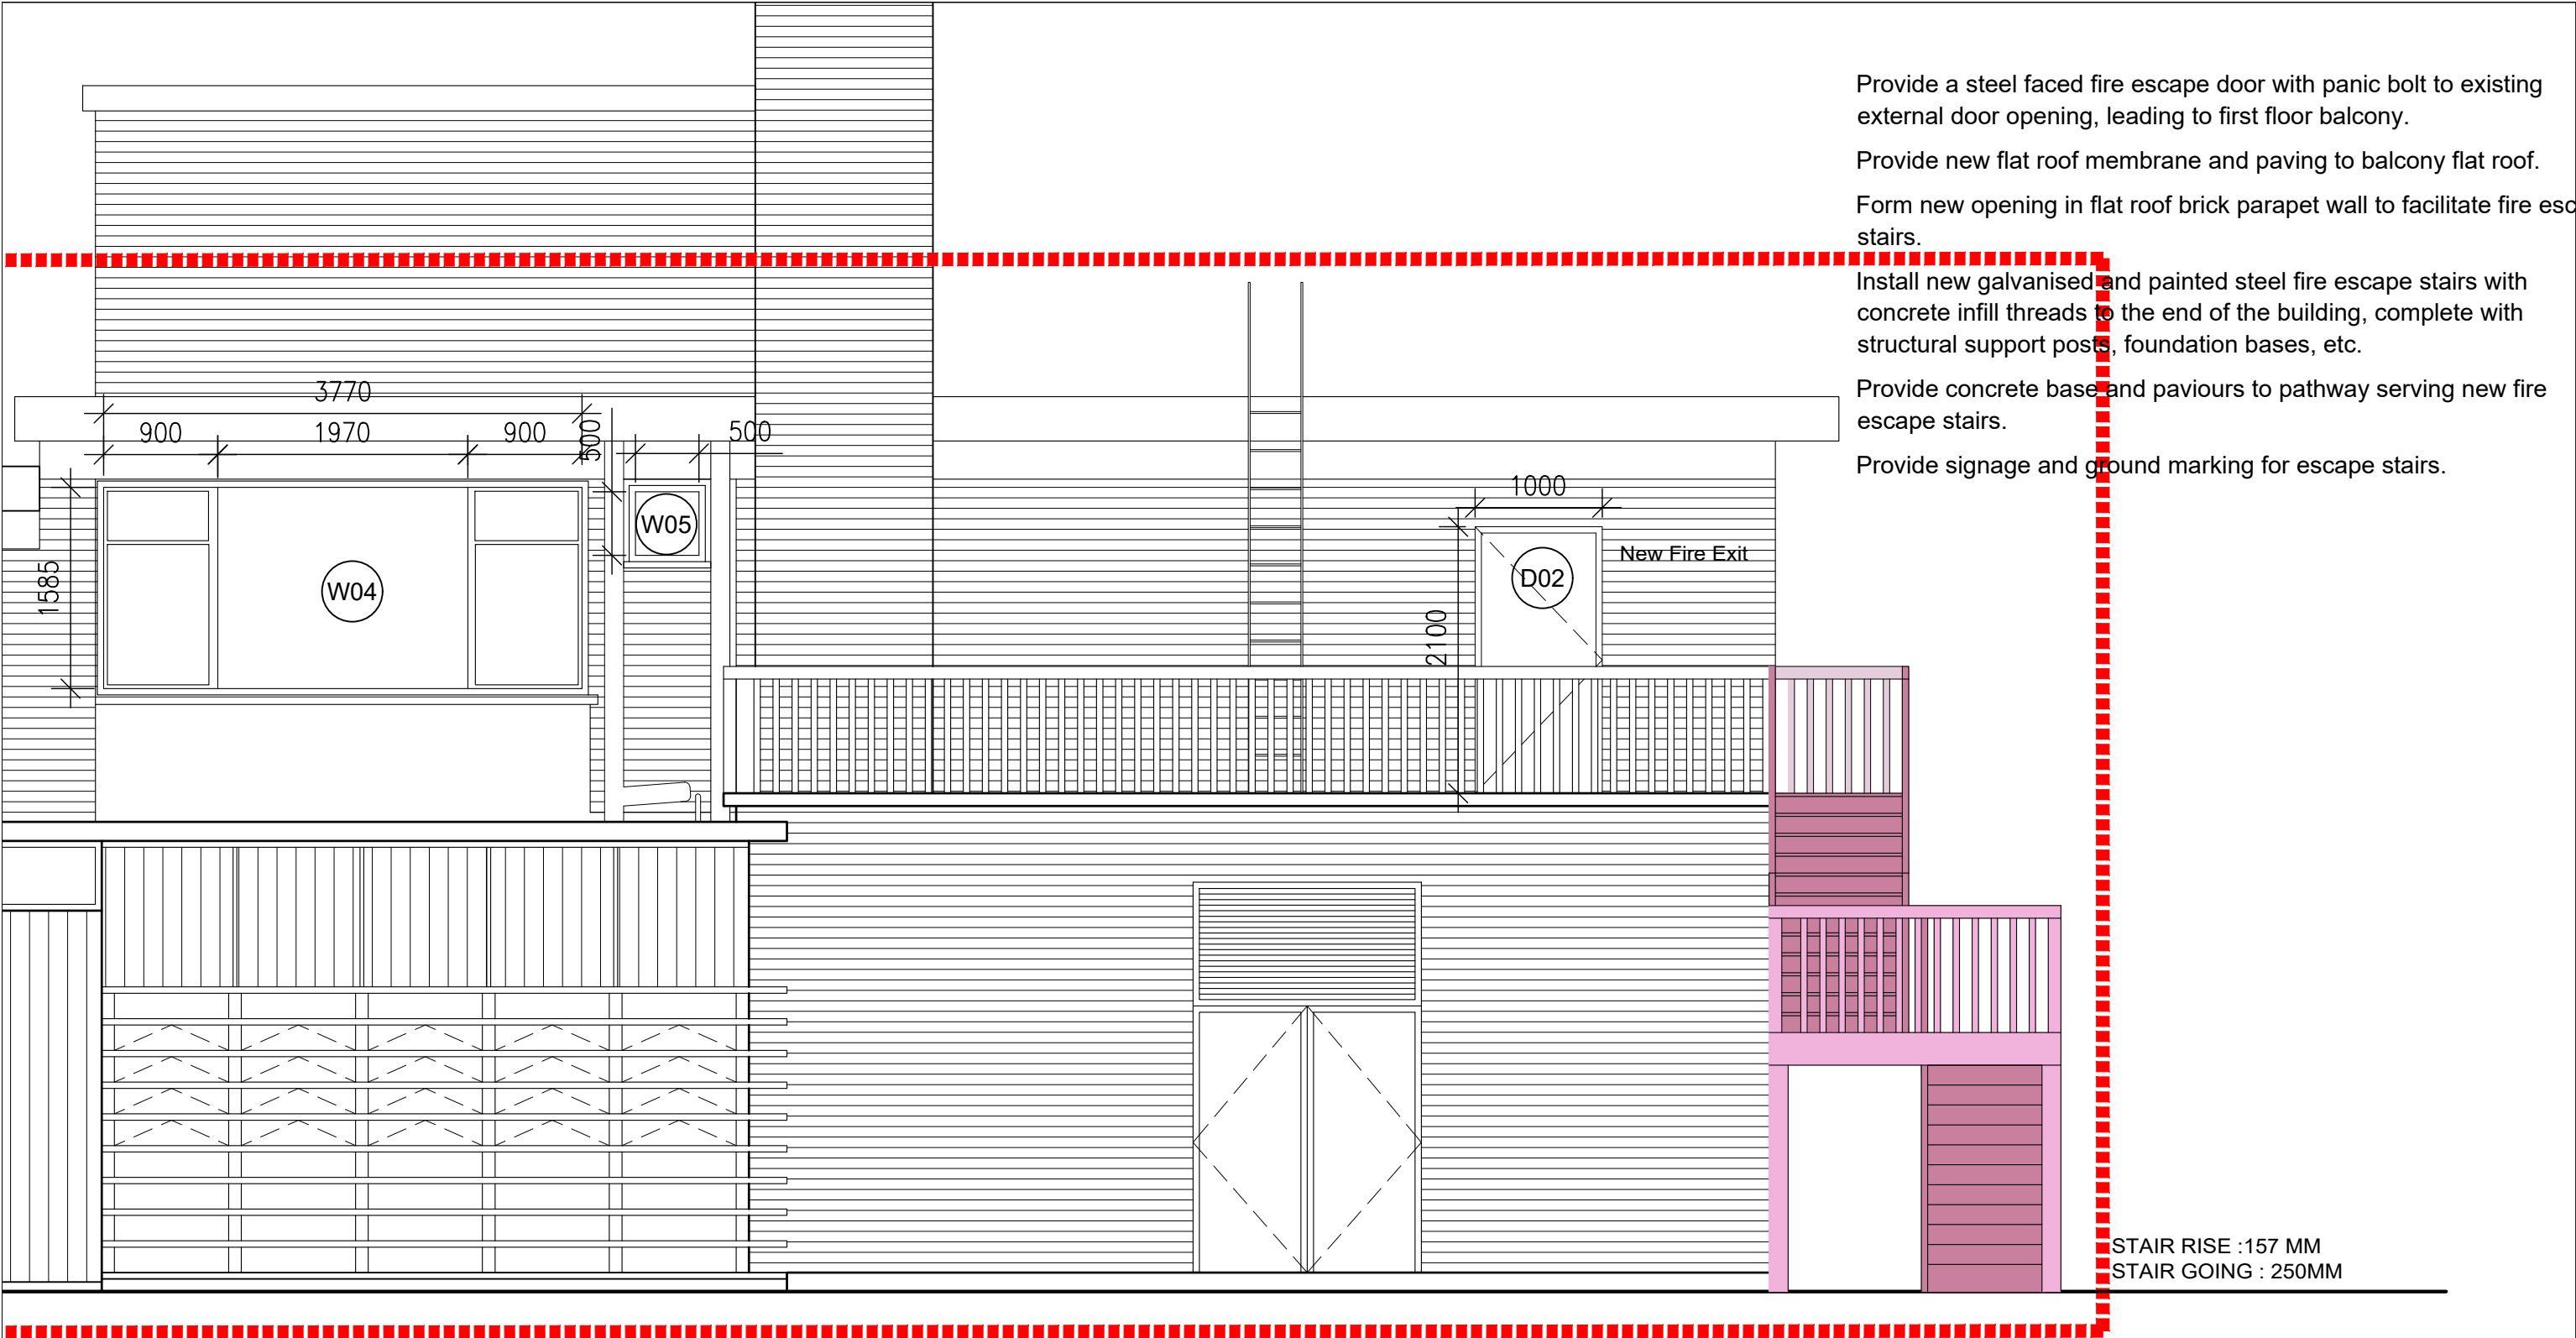

CLASSROOM 11 - NEW LIFE SKILLS ROOM ELEVATION

EMERGENCY WORKS 2026

Notes

1. Copyright Reserved

2. Work to figured dimensions only. Do not scale drawing.

3. The contractor is responsible for checking all levels and dimensions on site and shall refer all discrepancies to the Architect

4. Where appropriate, for details of r.c. structure, or mechanical and electrical details, see Engineers drawings

5. Proprietary items shall be fixed in strict accordance with manufacturers instructions.

6. Sizes of proprietary items shall be checked with manufacturer.

7. The contractor shall be responsible for the coordination of structure, finishes and services.

Project

EMERGENCY / ACCESSIBLE WORK AT
ST VINCENTS SPECIAL SCHOOL, DUBLIN 7

Drawing Title

PROPOSED FIRE ESCAPE STAIRS - SOUTH ELEVATION

Drawing No

25-04-1 - EW012

Scale

1:200@A3

Rev

-

Drawn

CQ

Date

NOV 2025

DOMA Architecture

Architecture & Project Management



www.doma.ie

79 Merrion Square South, Dublin 2,
D02 TN27 tel. 01 507 9990