


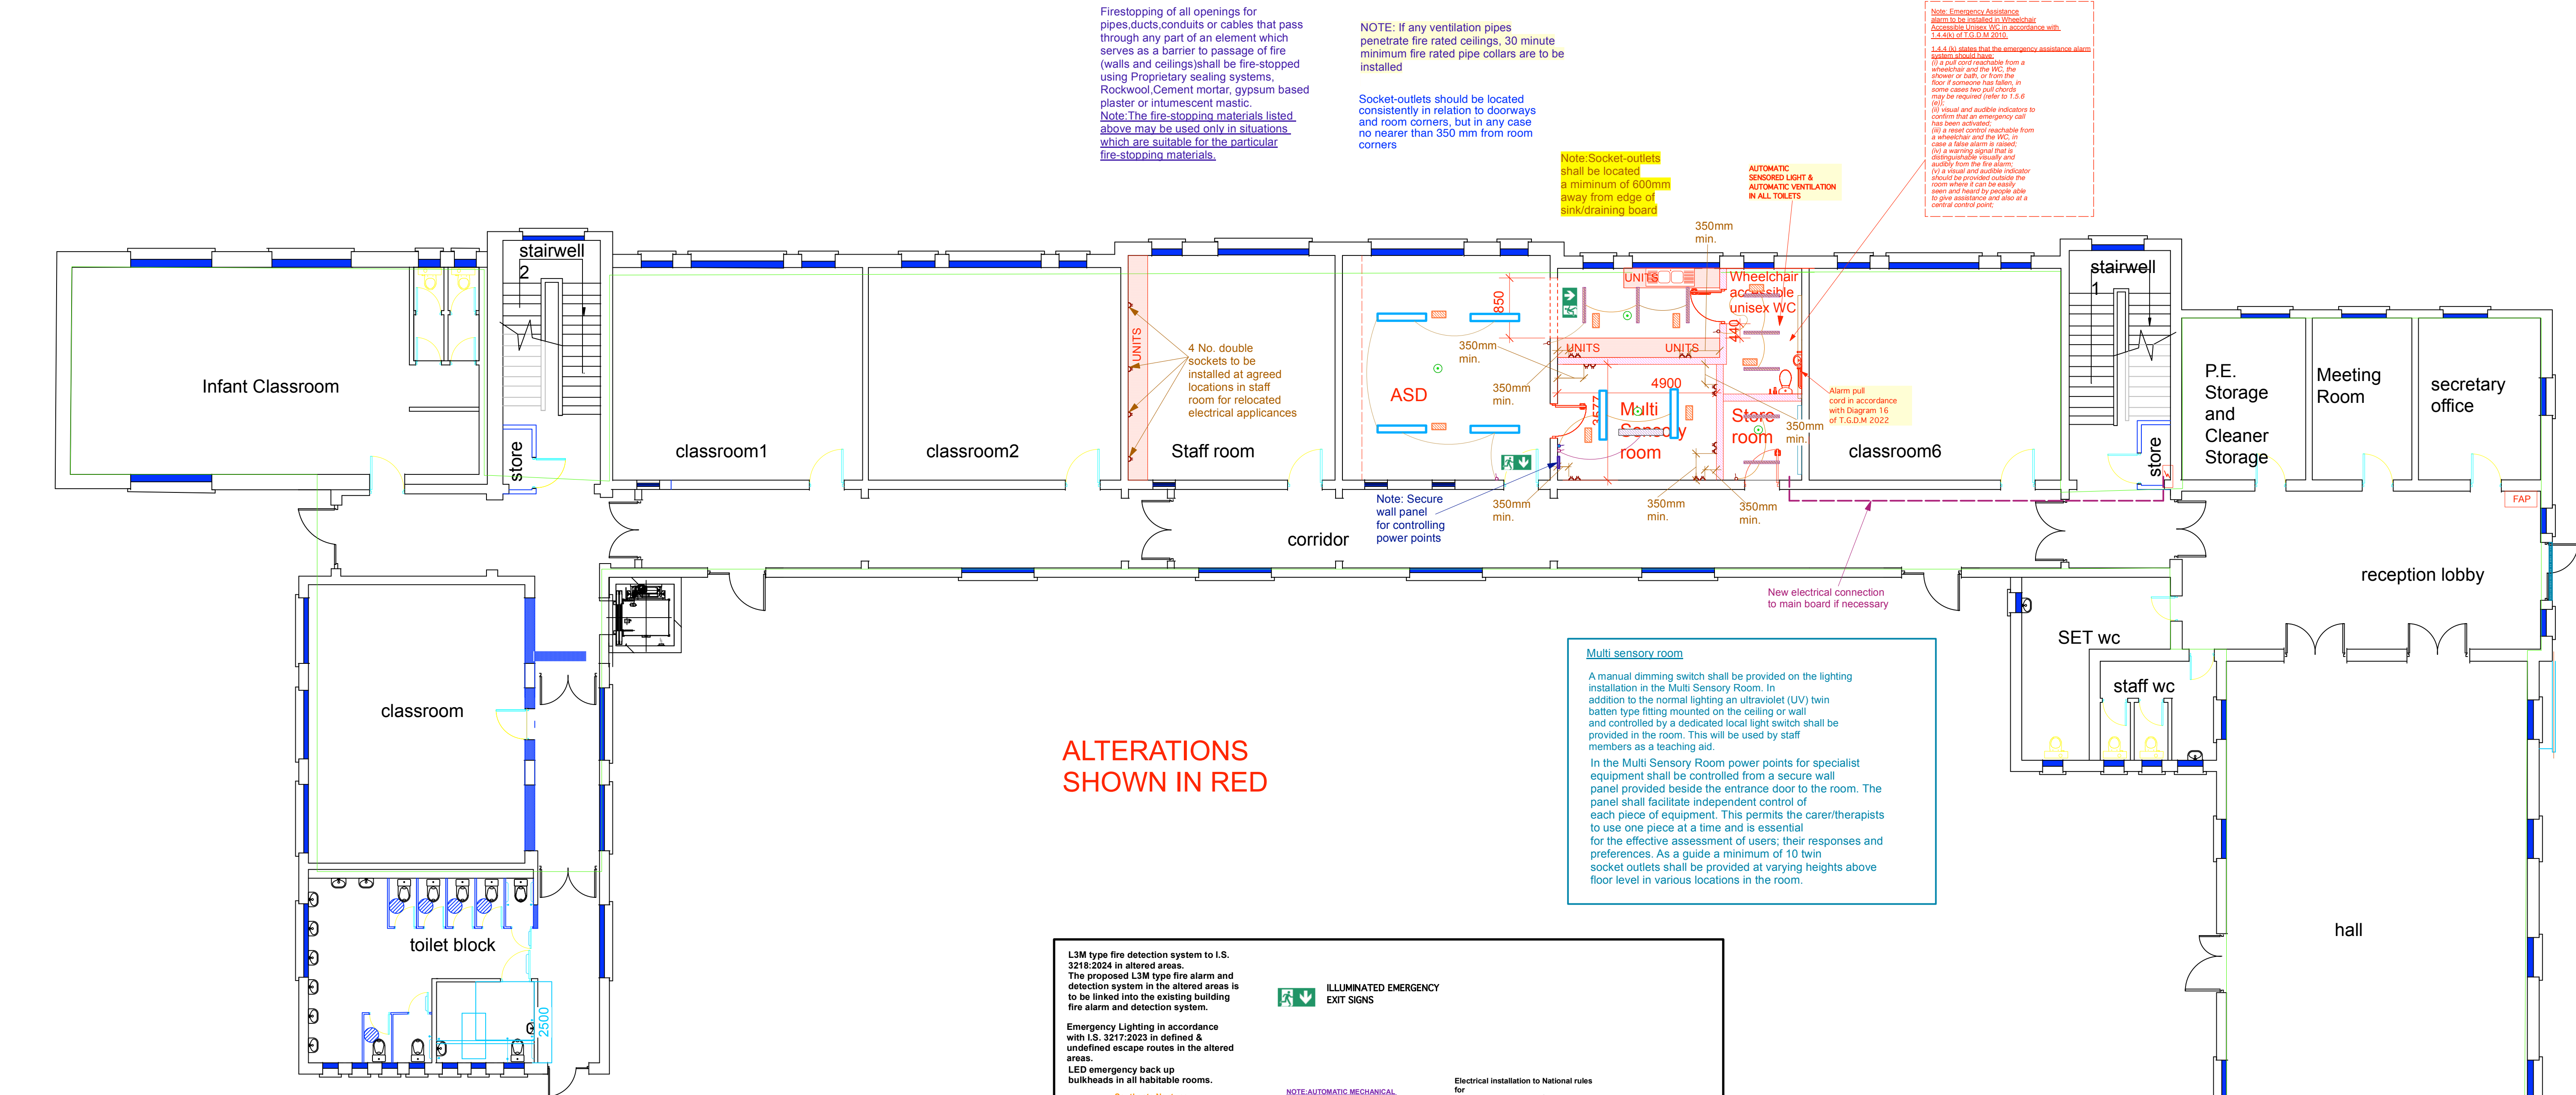

PROPOSED GROUND FLOOR PLAN

Project Title:	Alterations at Scoil Ailbhe
Drawing Ref. No.:	789424_PS_003
Title:	ELECTRICAL MARKUP
Client:	Ref. no. 789424
Scoil Ailbhe, Thurles, Co. Tipperary	Scale: 1-100@A1
	Date: 17-7-26
	Drawn: D.B.
	Checked: P.J.N.
Patrick J. Newell, B.E., Ph.D., C.Eng., Eur. Ing., Oaklands, Headford, Co. Galway. Phone: 093 35641 Fax.: 093 35050 E-mail: info@newelleng.ie Website: www.newelleng.ie	

All works to comply with Current Irish Building Regulations, Technical Guidance Documents and accompanying details. All work to be in compliance with all relevant Irish, European, British and International Standards.

Use Figured Dimensions only. Do not scale from Drawing.

Any discrepancy between drawings to be notified to Consulting Engineer for clarification.

Compliance with the Building Control (Amendment) Regulations 2014 will be required. The contractor will be required to facilitate the Assigned Certifier as required including providing all requested ancillary certificates and scheduling works to comply with the project Inspection Plan.

NOTE: L3M FIRE DETECTION SYSTEM TO I.S. 3218:2024 IN ALTERED AREAS INTEGRATED INTO EXISTING SYSTEM.

NOTE: MECHANICAL VENTILATION SYSTEM MUST AUTOMATICALLY SHUT OFF ON ACTIVATION OF THE FIRE ALARM

NOTE: Height of sockets-outlets, switches and controls as per diagram 32 of T.G.D.M 2022 (see attached)

NOTE: FIRE DETECTORS TO BE INSTALLED IN ALL ATTIC SPACES CONNECTED TO FIRE ALARM IN ACCORDANCE WITH I.S. 3218:2024

NOTE: FIXINGS FOR LIGHTS/DETECTORS NOT TO INTERFERE WITH FIRESTOPPING OR AIRTIGHTNESS

