



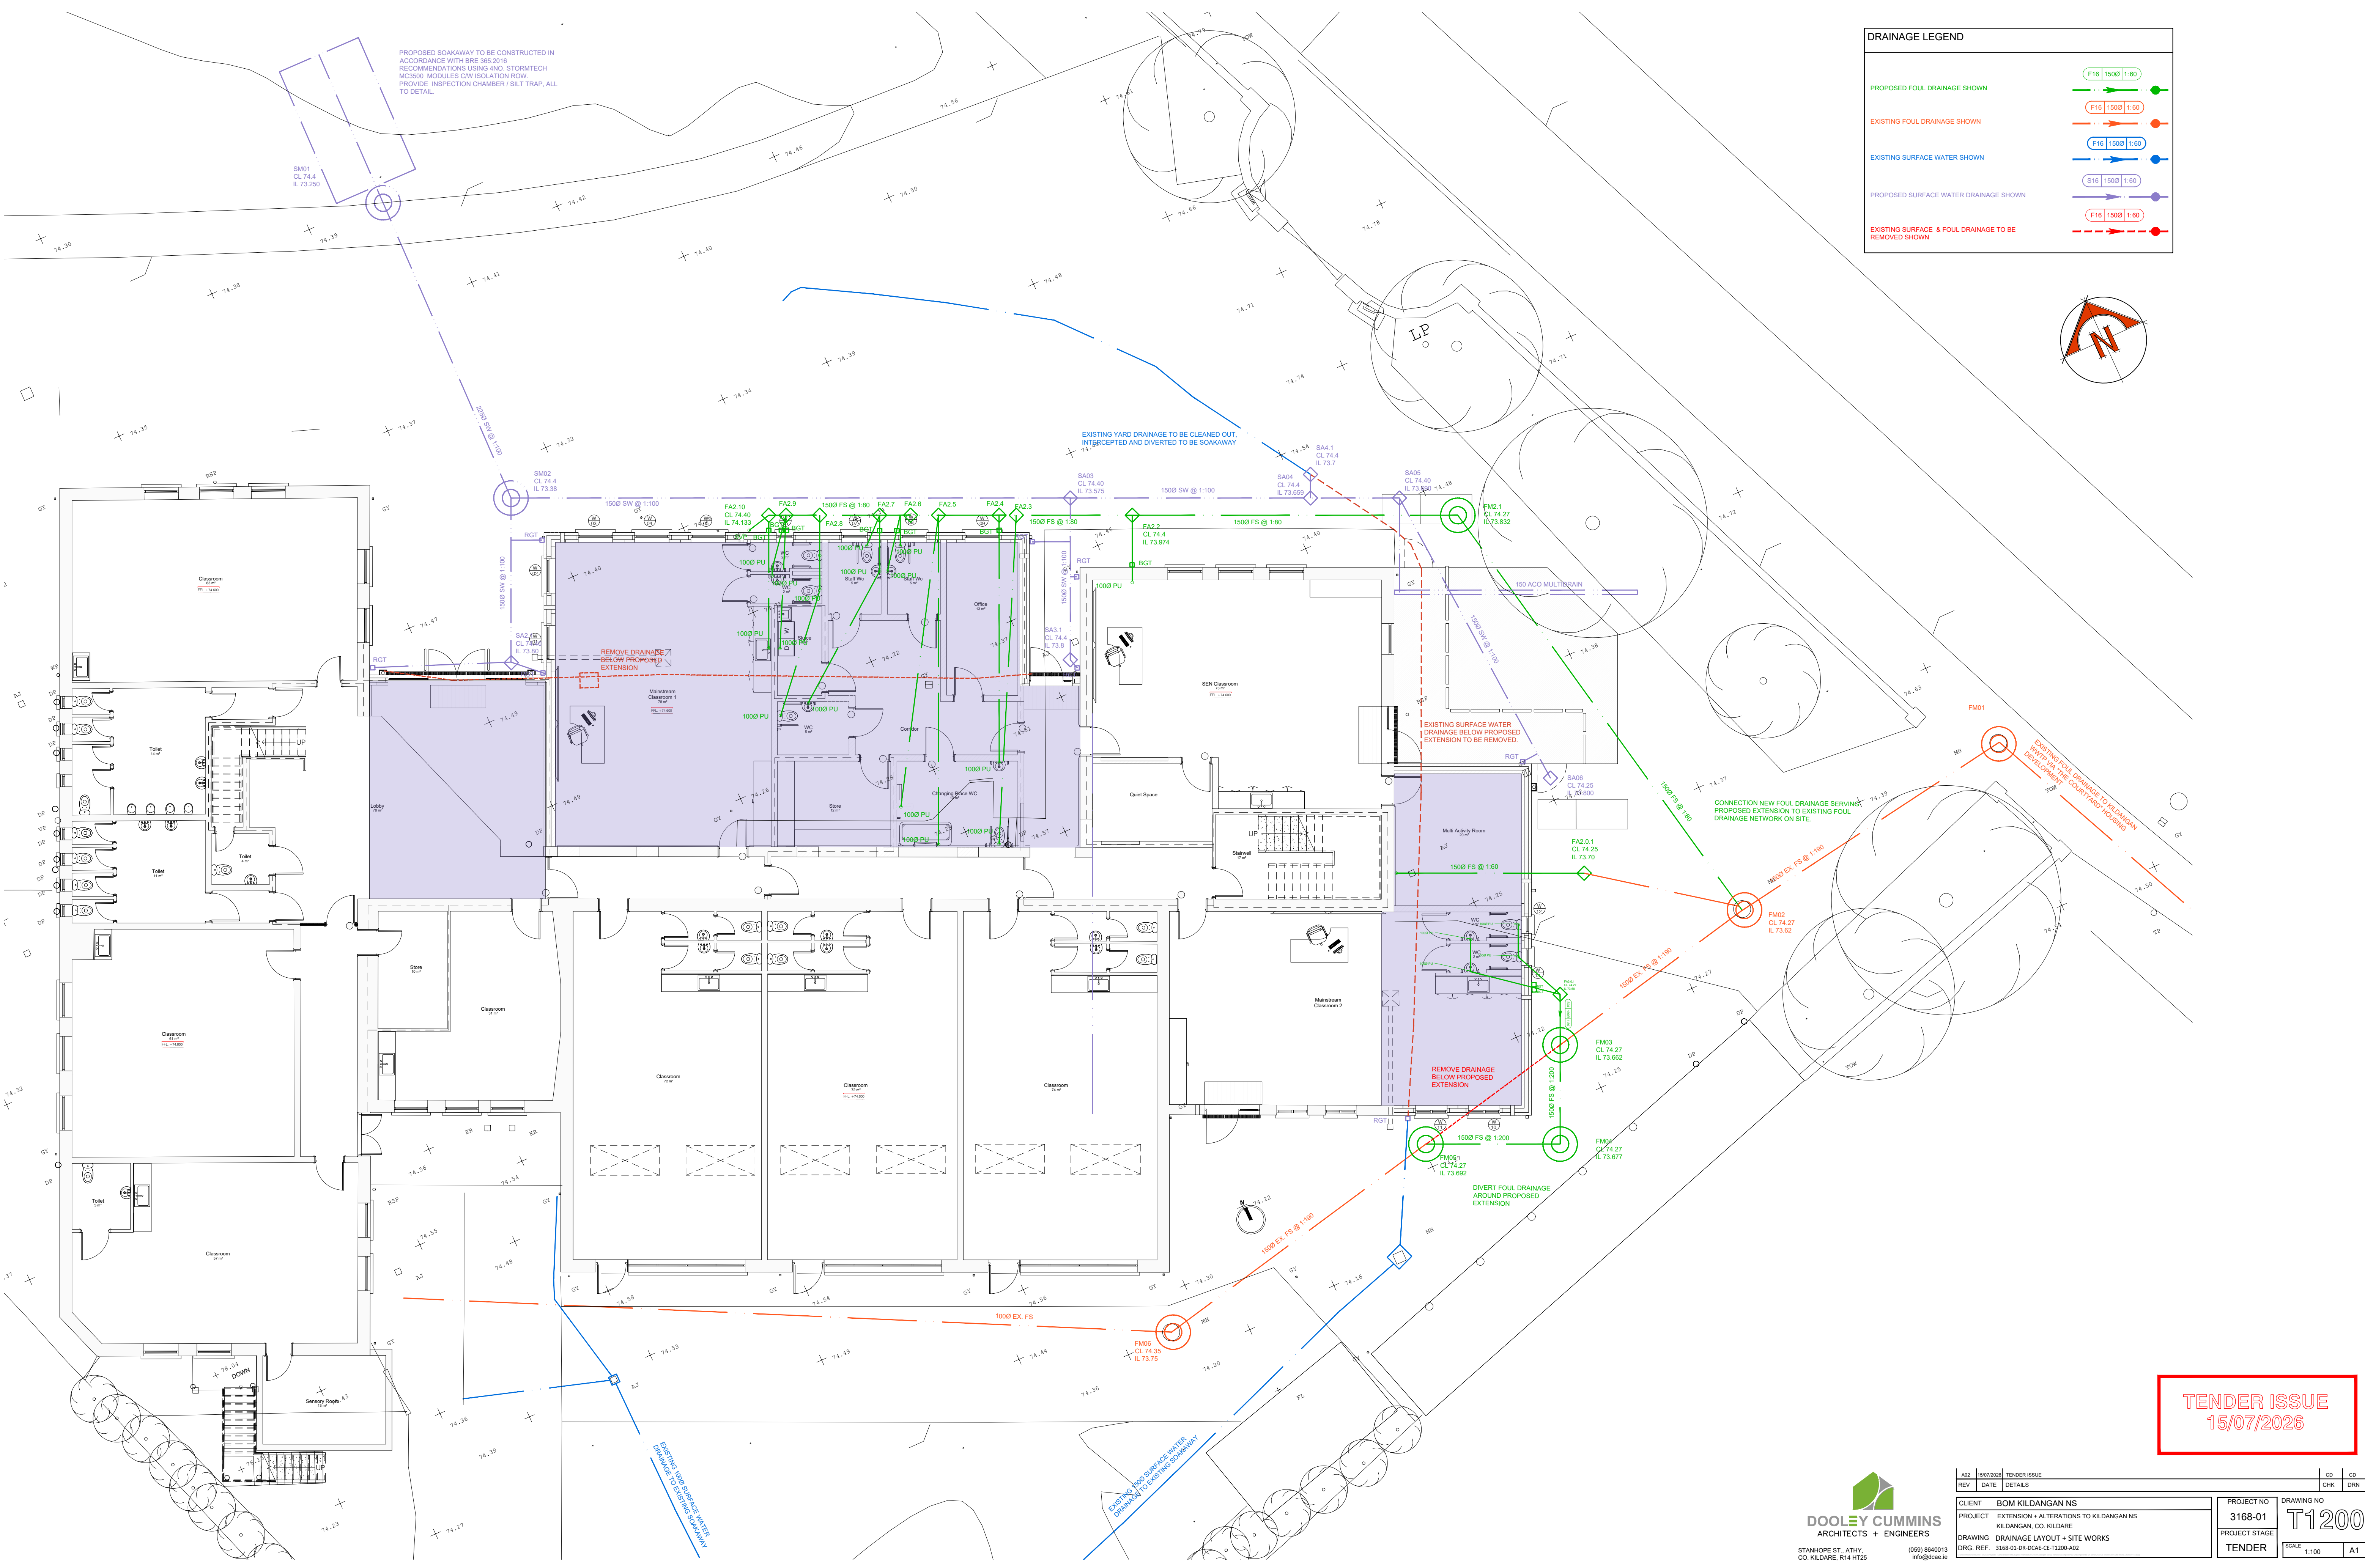

DRAINAGE LEGEND	
PROPOSED FOUL DRAINAGE SHOWN	F16 1500 1:60
EXISTING FOUL DRAINAGE SHOWN	F16 1500 1:60
EXISTING SURFACE WATER SHOWN	F16 1500 1:60
PROPOSED SURFACE WATER DRAINAGE SHOWN	S16 1500 1:60
EXISTING SURFACE & FOUL DRAINAGE TO BE REMOVED SHOWN	F16 1500 1:60

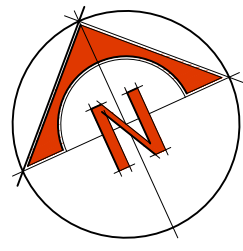

TENDER ISSUE
15/07/2026

		PROJECT NO 3168-01		DRAWING NO T1200	
ARCHITECTS + ENGINEERS		PROJECT STAGE TENDER		SCALE 1:100	
STANNAPPE, ST. ATHY, CO. KILDARE, R14 HT25		PROJECT EXTENSION + ALTERATIONS TO KILDANGAN NS		DRAWING DRAINAGE LAYOUT + SITE WORKS	
(059) 8643013 info@dooley.ie		DRG. REF. 3168-01-DR-DRAE-CE-T1200-002		TENDER	

COPYRIGHT LICENSE GRANTED ONLY TO THE NAMED CLIENT TO SUCH EXTENT AS TO ALLOW THE SPECIFIC WORKS TO BE CONSTRUCTED. THIS LICENSE DOES NOT EXTEND TO ANY OTHER WORKS. DONOT SCALE FROM DRAWINGS. USE MEASURED DIMENSIONS ONLY. IF IN DOUBT, ASK. NOTIFY DOOLEY OF ANY ERRORS OR DISCREPANCIES. ALL WORKS SHALL BE CARRIED OUT IN ACCORDANCE WITH BUILDING REGULATIONS, SAFETY, HEALTH & WELFARE AT WORK CONSTRUCTION REGULATIONS AND BS AND EN STANDARDS. WORKS REFERRED TO IN THIS DRAWING WHICH DO NOT MEET THE REQUIREMENTS OF THE ABOVE STANDARDS OR MAY CAUSE HAZARDOUS WORKING CONDITIONS SHALL BE BROUGHT TO THE ATTENTION OF DOOLEY. THE PERSONS RESPONSIBLE FOR CARRYING OUT THE WORKS SHALL CHECK THE ACCURACY OF THE DRAWINGS AGAINST THE SITE, ITS GEOMETRY AND CONDITIONS PRIOR TO THE CARRYING OUT OF THE WORKS.