


A1



PROTECTIVE SERVICES LAYOUT (SCALE 1:100)

PROTECTIVE SERVICES SYMBOLS

WPB	WIRELESS HAND HELD PANIC ATTACK BUTTON	C-	INTERNAL CCTV CAMERA C/W SPUR OUTLET (* DENOTES NUMBER OF CAMERAS)
FARP	NEW FIRE ALARM REPEATER PANEL FOR THE NEW EXTENSION.	CX-	EXTERNAL CCTV CAMERA C/W SPUR OUTLET (* DENOTES NUMBER OF CAMERAS)
S	NEW OPTICAL SMOKE DETECTOR	DVR	NEW CCTV DIGITAL RECORDER FOR THE CCTV SYSTEM IN THE BUILDING
S	NEW COMBINED SMOKE DETECTOR AND SOUNDER FOR THE FIRE ALARM SYSTEM.	MN	NEW FLAT SCREEN CCTV MONITOR FOR THE CCTV SYSTEM
MCP	NEW MANUAL CALL POINT	EDVR	EXISTING CCTV DIGITAL RECORDER FOR THE CCTV SYSTEM IN THE EXISTING BUILDING
VAD	NEW VISUAL AID DEVICE	ME	EXISTING FLAT SCREEN CCTV MONITOR FOR THE CCTV SYSTEM
S	NEW SMOKE DETECTOR INSTALLED IN CEILING VOID C/W REMOTE LED INDICATOR TO BE INSTALLED IN THE CEILING	PULL CORD	PULL CORD FOR THE EMERGENCY CALL SYSTEM
EFAP	EXISTING FIRE ALARM PANEL FOR THE FIRE ALARM SYSTEM IN THE BUILDING.	OS	OVER DOOR SOUNDER FOR EMERGENCY CALL SYSTEM
FAI	NEW FIRE ALARM INTERFACE	R	RESET BUTTON FOR EMERGENCY CALL SYSTEM
EBGL	NEW EMERGENCY BREAK GLASS UNIT FOR DOOR ACCESS SYSTEM	IAP	EXISTING MAIN INTRUDER ALARM PANEL FOR THE INTRUDER ALARM SYSTEM.
PRX	NEW COMBINED PROXIMITY FOB READER AND KEYPAD FOR THE DOOR ACCESS SYSTEM	N-IAP	NEW INTRUDER ALARM PANEL FOR THE EXTENSION WHICH SHALL BE CONNECTED TO EXISTING INTRUDER ALARM SYSTEM.
Power	NEW POWER SUPPLY FOR DOOR ACCESS SYSTEM	EX	NEW INTRUDER ALARM SOUNDER (EXTERNAL)
		IS	NEW INTRUDER ALARM SOUNDER (INTERNAL)
		DC	DUAL TECH PASSIVE INFRA-RED MOTION DETECTOR NEW INTRUDER ALARM DOOR CONTACT

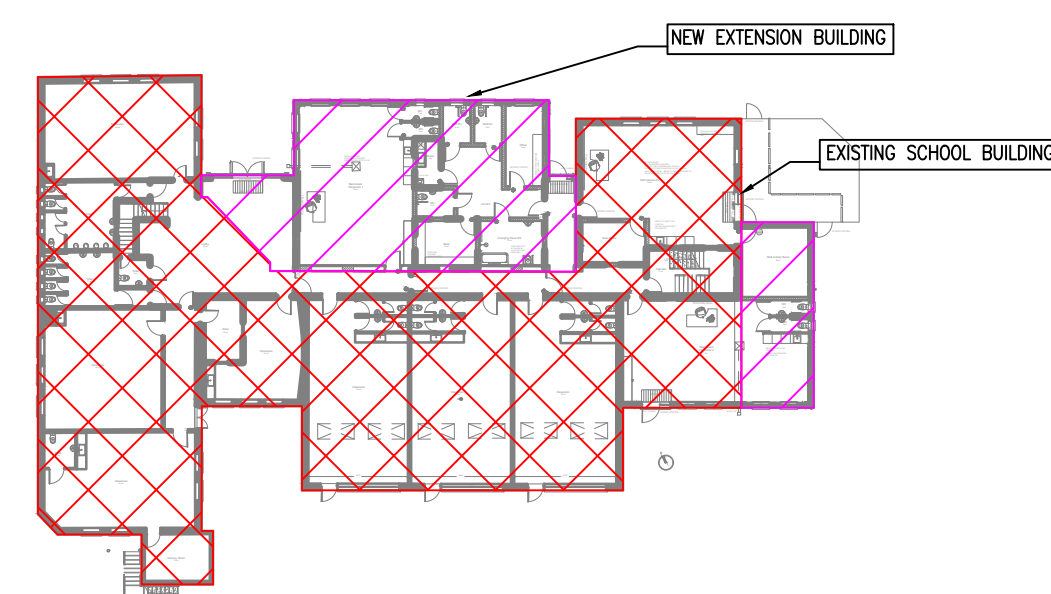

KEYPLAN 1:500

ALL ELECTRICAL SERVICES
THROUGHOUT THE NEW EXTENSION
ARE TO BE CHASED INTO WALLS.

GENERAL NOTES:

1. THIS DRAWING IS TO BE READ IN CONJUNCTION WITH ALL MECHANICAL, ELECTRICAL, ARCHITECTURAL AND STRUCTURAL DRAWINGS & SPECIFICATIONS.
 2. THE CONTRACTOR SHALL CO-ORDINATE FULLY WITH ALL OTHER TRADES BEFORE COMMENCING WORK. THE MECHANICAL CONTRACTOR SHALL BE RESPONSIBLE FOR PROVIDING ALL THE NECESSARY INFORMATION TO ALLOW THE MAIN CONTRACTOR CO-ORDINATE ALL SERVICES.
 3. THE MECHANICAL CONTRACTOR SHALL ALLOW FOR CO-ORDINATING THE MECHANICAL INSTALLATION WITH THE ELECTRICAL CONTRACTOR ON SITE. EXTRA COSTS INCURRED DUE TO THE CO-ORDINATION EXERCISE NOT BEING COMPLETED WILL NOT BE ACCEPTED BY THE EMPLOYER.
 4. DO NOT SCALE THIS DRAWING. ALL DIMENSIONS TO BE TAKEN ON SITE.
 5. THE CONTRACTOR SHALL ALLOW FOR THE SUPPLY AND INSTALLATION OF ALL ELECTRICAL SERVICES INDICATED ON THIS DRAWING.
 6. THE CONTRACTOR SHALL BE RESPONSIBLE TO IDENTIFY SUITABLE FINAL ROUTES FOR CABLE CONTAINMENT, ELECTRICAL SERVICES, ETC AS INDICATED ON THE DRAWINGS.
 7. NEW MAINS RUN OF ELECTRICAL CONTAINMENT SHALL BE INSTALLED IN THE AREAS AS INDICATED. THIS IS INDICATIVE ONLY AND IF THE CONTRACTOR FINDS A MORE CONVENIENT ROUTE FOR THE ELECTRICAL SERVICES ON SITE THEN THAT WILL BE ACCEPTABLE.
 8. FINAL LOCATION OF ALL ITEMS OF SOCKETS/IT POINTS/LIGHTING, ETC. SHALL BE AGREED ON SITE WITH THE EMPLOYERS REPRESENTATIVE AND THE CLIENT.
 9. ALL SERVICES THROUGH FIRE BARRIERS SHALL BE SLEEVED EACH SIDE OF THE BARRIER. THE MAIN CONTRACTOR SHALL ALLOW FOR FIRE PROOFING THE OPES AFTER SERVICES IS INSTALLED.
 10. THE CONTRACTOR SHALL ALLOW FOR ALL NECESSARY LABOUR, WIRING AND ATTENDANCES IN COMPLETING ALL THE ELECTRICAL WORKS AS INDICATED ON THE DRAWINGS AND SPECIFICATIONS.
 11. ALL AREAS: ALL ELECTRICAL SERVICES BELOW CEILING LEVEL FOR THE ELECTRICAL INSTALLATION IN ALL AREAS SHALL BE RECESSED/CONCEALED AND FINISHED FLUSH WITH THE FINISHED WALL, UNLESS STATED OTHERWISE. LAISE WITH THE MAIN CONTRACTOR FOR ALL NECESSARY CHASES OR BOXING OUT TO CONCEAL SERVICES IN THE UNIT.
- FIRE ALARM SERVICES NOTES:**
12. THE FIRE ALARM SYSTEM SHALL BE DESIGNED, INSTALLED AND COMMISSIONED ACCORDING TO AN L1 SYSTEM IN ACCORDANCE WITH LS 3218: 2024.
 13. FIRE ALARM DETECTION HEADS SHALL BE MAINS WIRED AND SHALL ALSO HAVE A BATTERY BACK-UP. EACH HEAD SHALL ALSO HAVE AN IN-BUILT SOUNDER.
 14. FIRE ALARM DETECTION HEADS SHALL INCLUDE A CONDITION INDICATION LIGHT.
 15. ALL MANUAL CALL POINTS TO BE PROVIDED WITH CLEAR PLASTIC TAMPER COVERS.
 16. ALL MANUAL CALL POINTS SHALL BE OF THE FULLY RESETTABLE TYPE VIA KEY OPERATION. THE USE OF BREAKABLE GLASS IN THE CALL UNITS IS NOT PERMITTED.
 17. FINAL LOCATION OF ALL ITEMS OF SHALL BE AGREED ON SITE WITH THE EMPLOYERS REPRESENTATIVE AND THE CLIENT.
 18. WHERE SIGNAL/CONTROL CABLES ARE ROUTED TO THEIR RESPECTIVE CONTROL PANEL PROVIDE LOCAL PLASTIC TRUNKING TO ENCLOSE MULTIPLE RUNS OF CABLE.
- INTRUDER ALARM & CCTV NOTES:**
19. THE ELECTRICAL CONTRACTOR SHALL DESIGN, INSTALL COMMISSION A FULLY MONITORED INTRUDER ALARM SYSTEM WHICH SHALL COMPLY WITH ISEN50131/1.
 20. THE CONTRACTOR SHALL ALLOW FOR ALL EXPANSION BOARDS AS REQUIRED.
 21. ALL EXTERNAL SOUNDERS TO BE FITTED WITH GALVANIZED STEEL MESH CAGES. ALL TO BE SUPPLIED AND FITTED BY THE CONTRACTOR
 22. ALL PIR'S SHALL BE FITTED WITH 'DOUBLE-KNOCK' DUAL ACTIVATION TO COMPLY WITH GARDA REQUIREMENTS.
 23. THE ELECTRICAL CONTRACTOR SHALL ALLOW FOR POWER SUPPLY & ELECTRICAL CONNECTION TO ALL SECURITY AND DOOR ACCESS ITEMS IDENTIFIED.
 24. THE ELECTRICAL CONTRACTOR SHALL DESIGN, INSTALL AND COMMISSION A FULLY MONITORED CCTV SYSTEM WHICH SHALL COMPLY TO ISEN50131/1 AND IS199.
 25. ALL NEW EXTERNAL CCTV CAMERAS TO BE PLACED AT HIGH LEVEL. FINAL LOCATION OF ALL NEW CCTV CAMERAS AND EQUIPMENT TO BE REVIEWED WITH CLIENT PRIOR TO INSTALLATION.
 26. INCLUDE FOR POWER SUPPLIES AND ELECTRICAL WIRING TO ALL NEW CCTV EQUIPMENT AS SHOWN ON THE DRAWINGS AND DETAILED IN THE SPECIFICATIONS.
 27. THE CONTRACTOR SHALL ALLOW FOR ALL EXPANSION BOARDS AS REQUIRED. THE CONTRACTOR SHALL DESIGN INSTALL AND COMMISSION A FULLY DIGITAL CCTV SYSTEM WHICH SHALL COMPLY TO ISEN50132 AND IS199.

ACCESS SYSTEM NOTES:

28. THE CONTRACTOR SHALL ALLOW FOR THE COMPLETE INSTALLATION OF ALL DOOR AND GATE ACCESS SYSTEMS. THE DOOR AND GATE ACCESS SYSTEMS AND DOOR ACCESS DEVICES SHALL BE SUPPLIED, WIRED, INSTALLED AND COMMISSIONED BY THE ELECTRICAL CONTRACTOR. REFER TO THE SPECIFICATION FOR FURTHER DETAILS.

EMERGENCY CALL SYSTEMS:

29. THE CONTRACTOR SHALL ALLOW FOR THE SUPPLY AND INSTALLATION OF ALL THE EMERGENCY CALL SYSTEM FOR THE UNIVERSAL TOILET IN THE BUILDING AS INDICATED ON THE DRAWINGS. SEE DRAWINGS AND THE SPECIFICATIONS FOR FURTHER INFORMATION ON ITEMS REQUIRED. ALLOW FOR ALL NECESSARY ATTENDANCES FOR THE SUPPLY AND INSTALLATION OF THE SYSTEMS.

T2	17.07.2026	E.OLAYA	G.BENNDORF
T1	14.08.2024	K. DAVITT	G. BENNDORF
REV	DATE	PREPARED BY/PROJECT ENGINEER	QUALITY CHECK BY:

M&E CONSULTANT

Galileo
ENERGY SERVICES

UNIT A6, M4 BUSINESS PARK, MAYNOOTH
ROAD, CELBRIDGE, CO. KILDARE.
Tel: 01-6274103
www.galileoenergy.ie

Copyright ©

Drawing Status
TENDER

Job Title
KILDANGAN NATIONAL SCHOOL,
KILDANGAN,
MONASTEREVIN,
CO. KILDARE.

Drawing Title
**PROTECTIVE SERVICES
LAYOUT**

Architect M'LOUGHLIN ARCHITECTURE
Unit 48, Elm House Tel. 045 854 900
Millennium Park, Naas
Co.Kildare, Ireland

Scale:	1:100 @ A1	Drawn By:	E.O
Job No.	22-055	Drawing No.	68(E001)
		Rev.	T2