


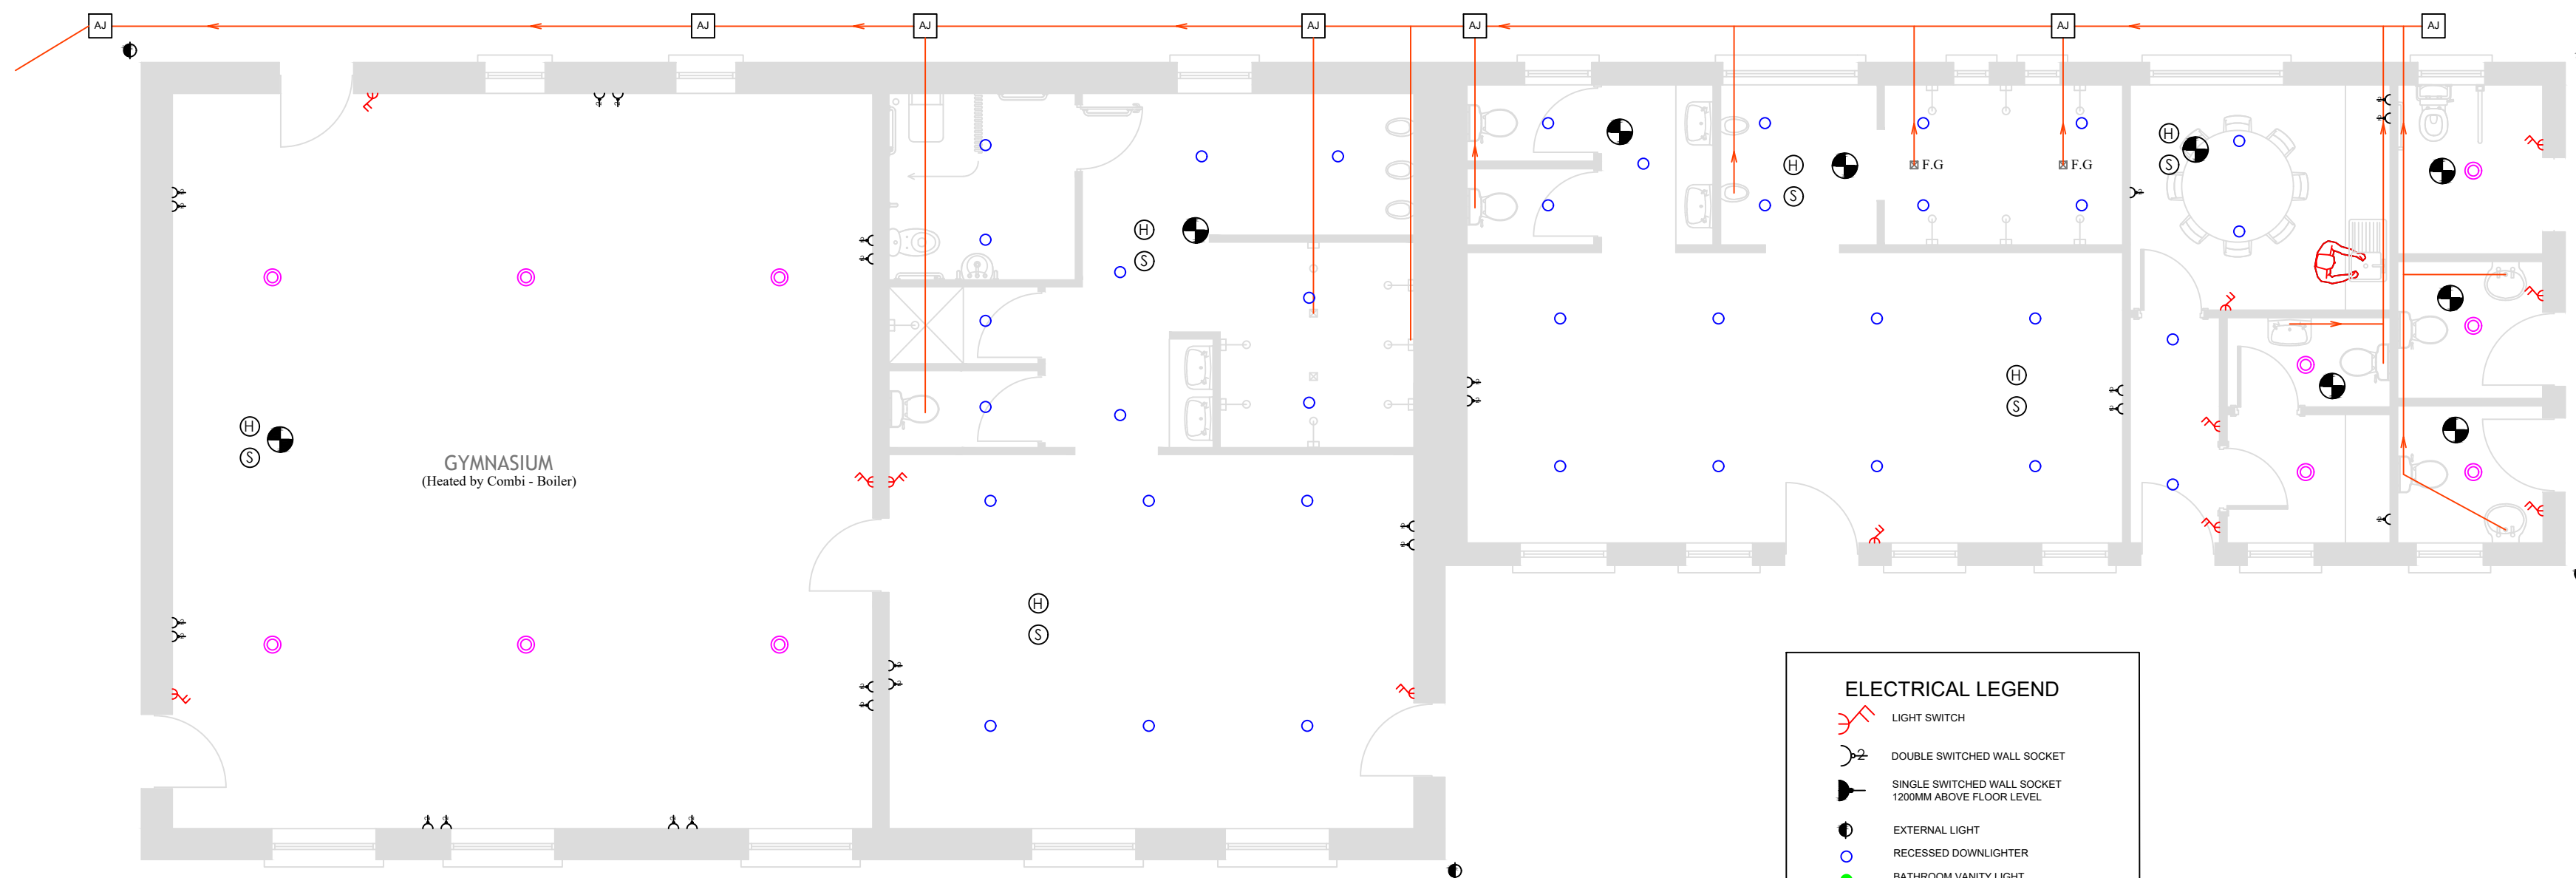

 **Proposed Ground Floor Plan**
SCALE NTS

ELECTRICAL LEGEND	
	LIGHT SWITCH
	DOUBLE SWITCHED WALL SOCKET
	SINGLE SWITCHED WALL SOCKET 1200MM ABOVE FLOOR LEVEL
	EXTERNAL LIGHT
	RECESSED DOWNLIGHTER
	BATHROOM VANITY LIGHT
	Pendant Light
	TV AERIAL POINT
	MECHANICAL EXTRACT FAN
	THERMOSTAT
	TELEPHONE POINT
	CAT 5 or 6 DATA SOCKET
	COMBINED HEAT DETECTOR AND FIRE ALARM SOUNDER
	COMBINED SMOKE/HEAT DETECTOR AND FIRE ALARM SOUNDER
	HEATED TOWEL RADIATOR



Contact :-Clahanelinehan, Cahirciveen, Co. Kerry
Mob: (087) 2673766

Client:
Folliore GAA,
Gortmore,
Cahersiveen,
Co. Kerry

Scale: 1:75 @ A2 Date: 19/11/2025

Drawn by: D.S Drawing No. 16/02 Rev. N/A

Note:-

Pictures are strictly for the purpose of showing samples of our work and some units may be exclusive to individual clients.

All drawings and designs suggested by 3DS Designs must be checked by a qualified architect to ensure that they fully comply with all necessary building and safety regulations.

Drawings are strictly for use between 3DS Designs and their clients only, in accordance with our terms and conditions, a copy of which can be obtained on request. ©COPYRIGHT