



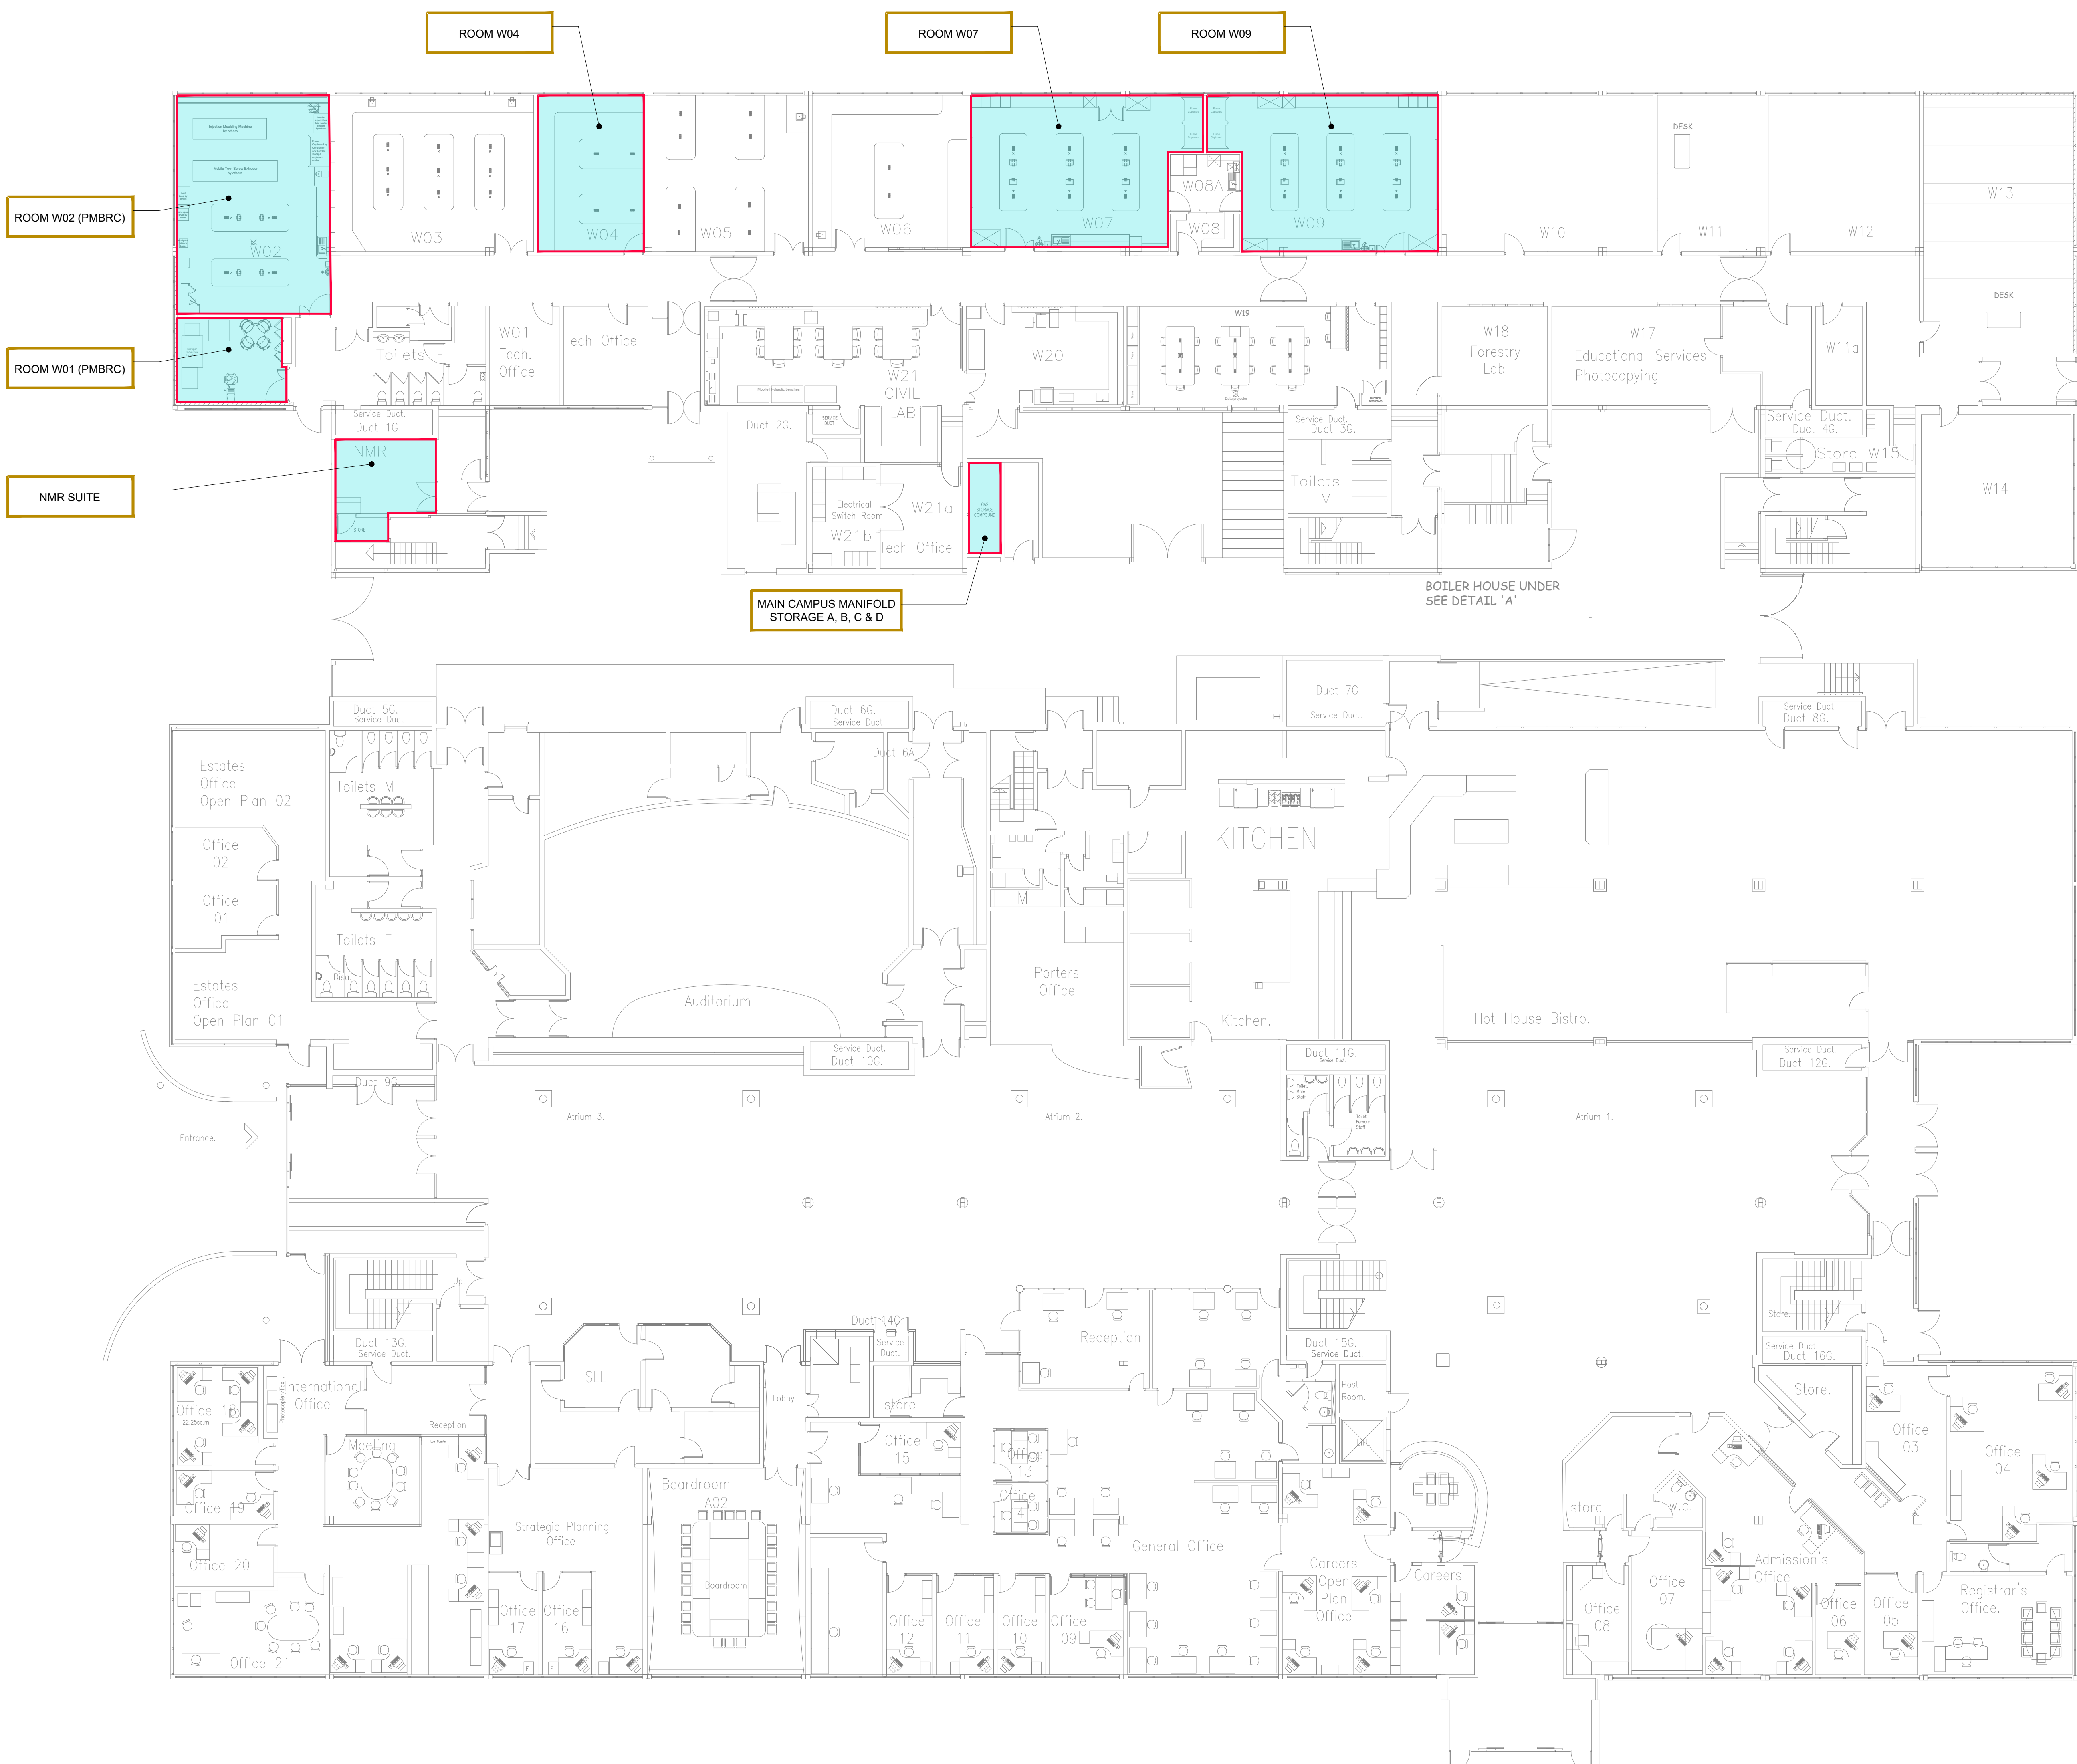

NOTE:
REFER TO GAS MANIFOLD AND REGULATOR SCHEDULE FOR LIST OF OUTLETS/QUANTITIES.

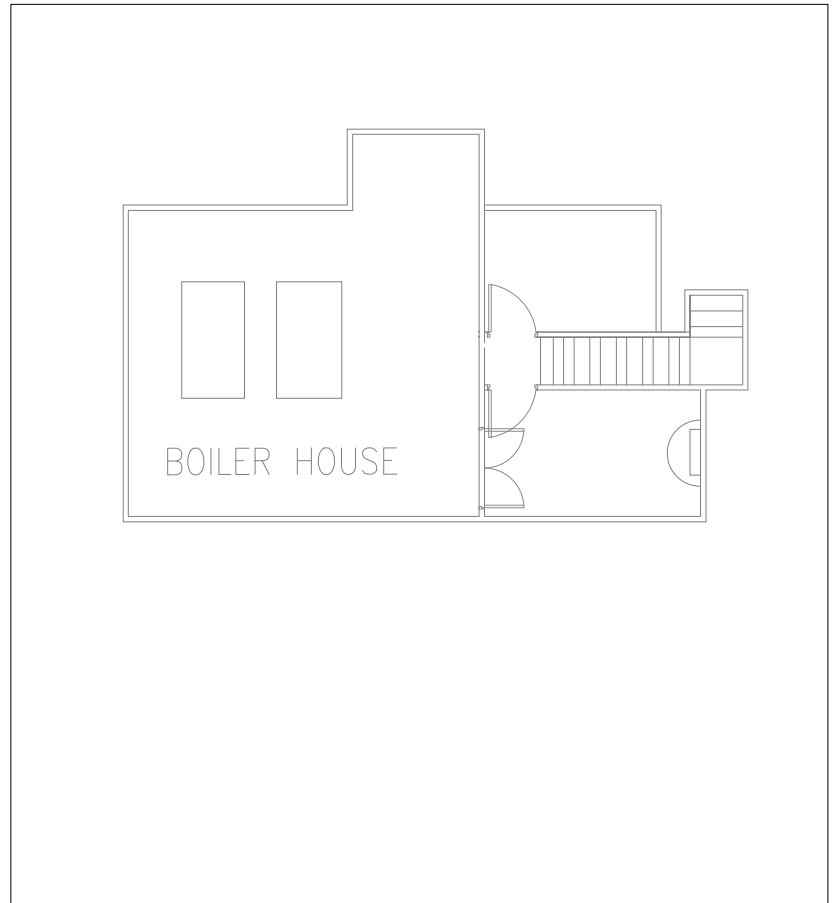

Rev	Description	Date
CLIENT: SOUTH EAST TECHNOLOGICAL UNIVERSITY		
South East Technological University Cork Road, Waterford.		
PROJECT: GAS REGULATORS & MANIFOLDS UPGRADE WORKS		
DRAWING TITLE: CORK ROAD CAMPUS -ENG & SCIENCE BUILDING- GROUND FLOOR PLAN		
SCALE: 1:150 @ A1		DRAWING SIZE: A1
DATE: AUGUST 2026		DRAWN BY: AM
DRAWING No: M1		REV: 0

ESTATES OFFICE (WD)