


NOTE:
REFER TO GAS MANIFOLD AND REGULATOR SCHEDULE FOR LIST OF OUTLETS/QUANTITIES.

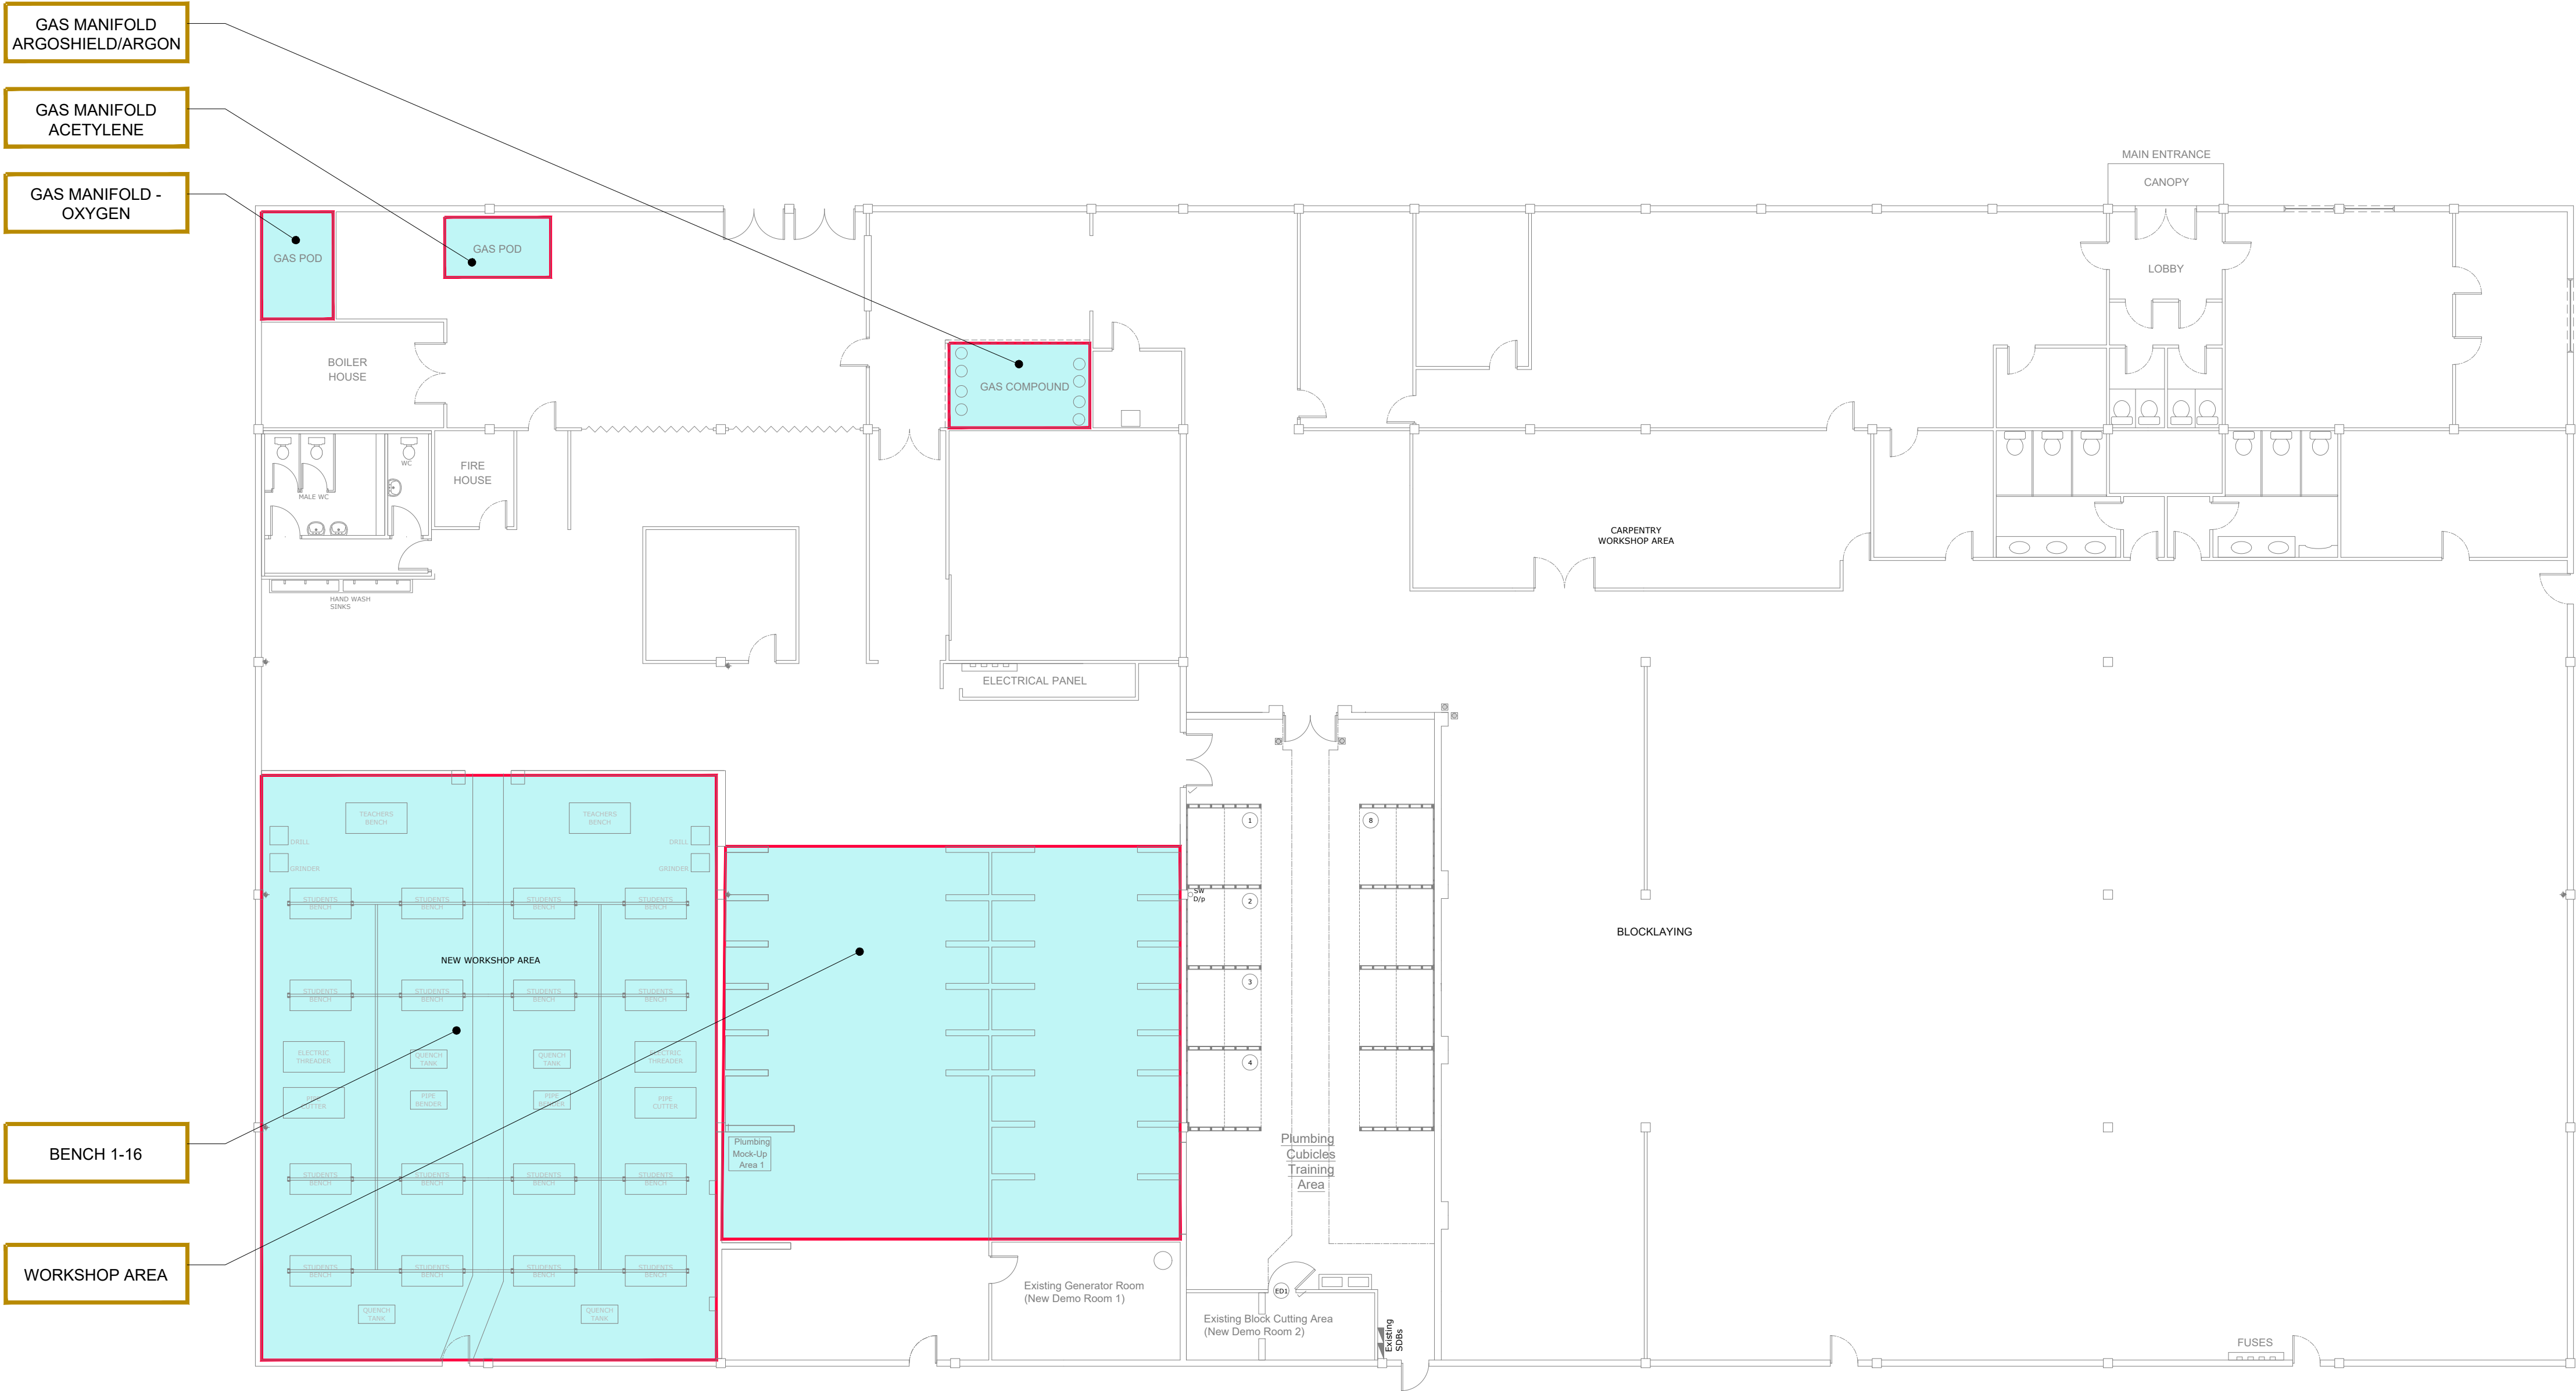

Rev	Description	Date
CLIENT: SOUTH EAST TECHNOLOGICAL UNIVERSITY		
South East Technological University Cork Road, Waterford.		
PROJECT: GAS REGULATORS & MANIFOLDS UPGRADE WORKS		
DRAWING TITLE: BROWNES ROAD CAMPUS -HARVEYS BUILDING-		
GROUND FLOOR PLAN		
SCALE: 1:150 @ A1	DRAWING SIZE: A1	
DATE: AUGUST 2026	DRAWN BY: AM	
DRAWING No: M3	REV: 0	

ESTATES OFFICE (WD)