


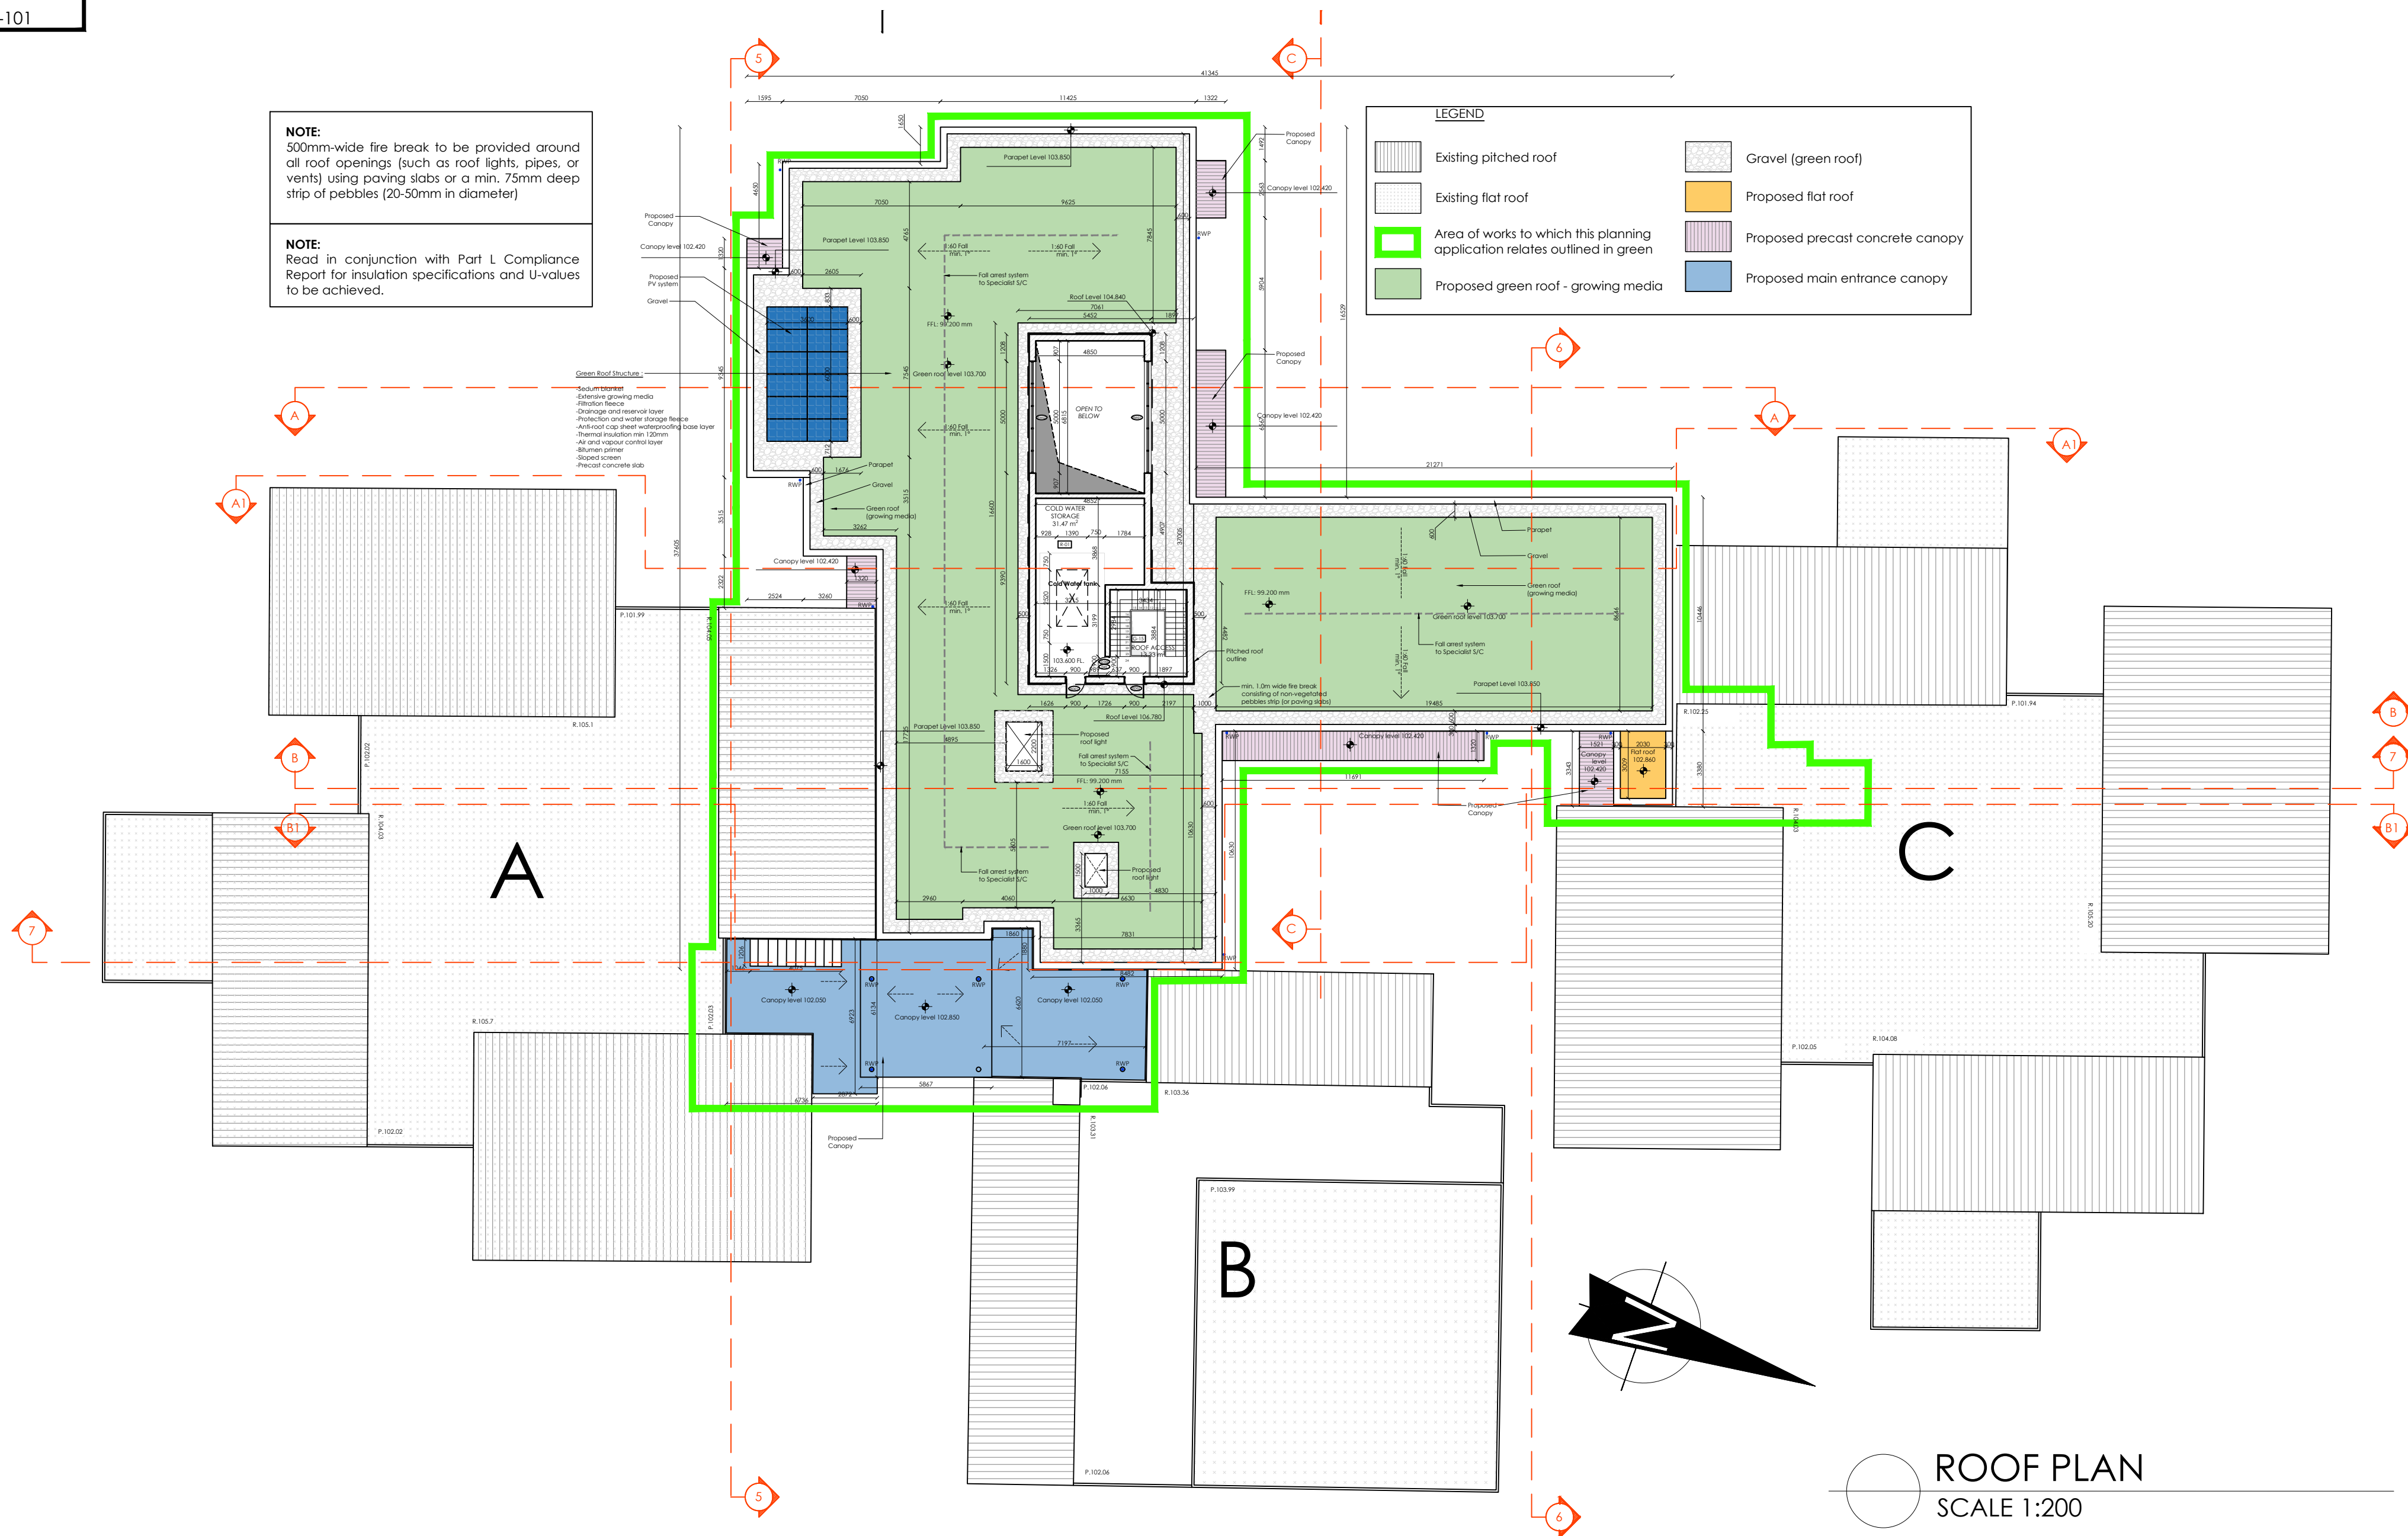

NOTES :

*This drawing is copyright and may not be copied or altered without permission.
Use only figured dimensions. Do not scale this drawing.
The contractor is responsible for checking all dimensions on site prior to construction.
The Architects are to be notified of any discrepancies prior to work commencing.
Levels and contours, shown on drawings, are relative to local datum unless specified*

[illegible]

CLIENT :		QUEEN OF ANGELS PRIMARY SCHOOL	
PROJECT :		Additional Accommodation	
ADDRESS :		Wedgewood,Sandymford, Dublin,16	
DRAWING :			
ROOF PLAN			
P&ID REF:		SCALE:	DWG. NO.:
22518-TEN		1/200	22518-TEN-101
DRAWN BY:	DATE:	REV:	
MC, TG	13.10.2025		

