




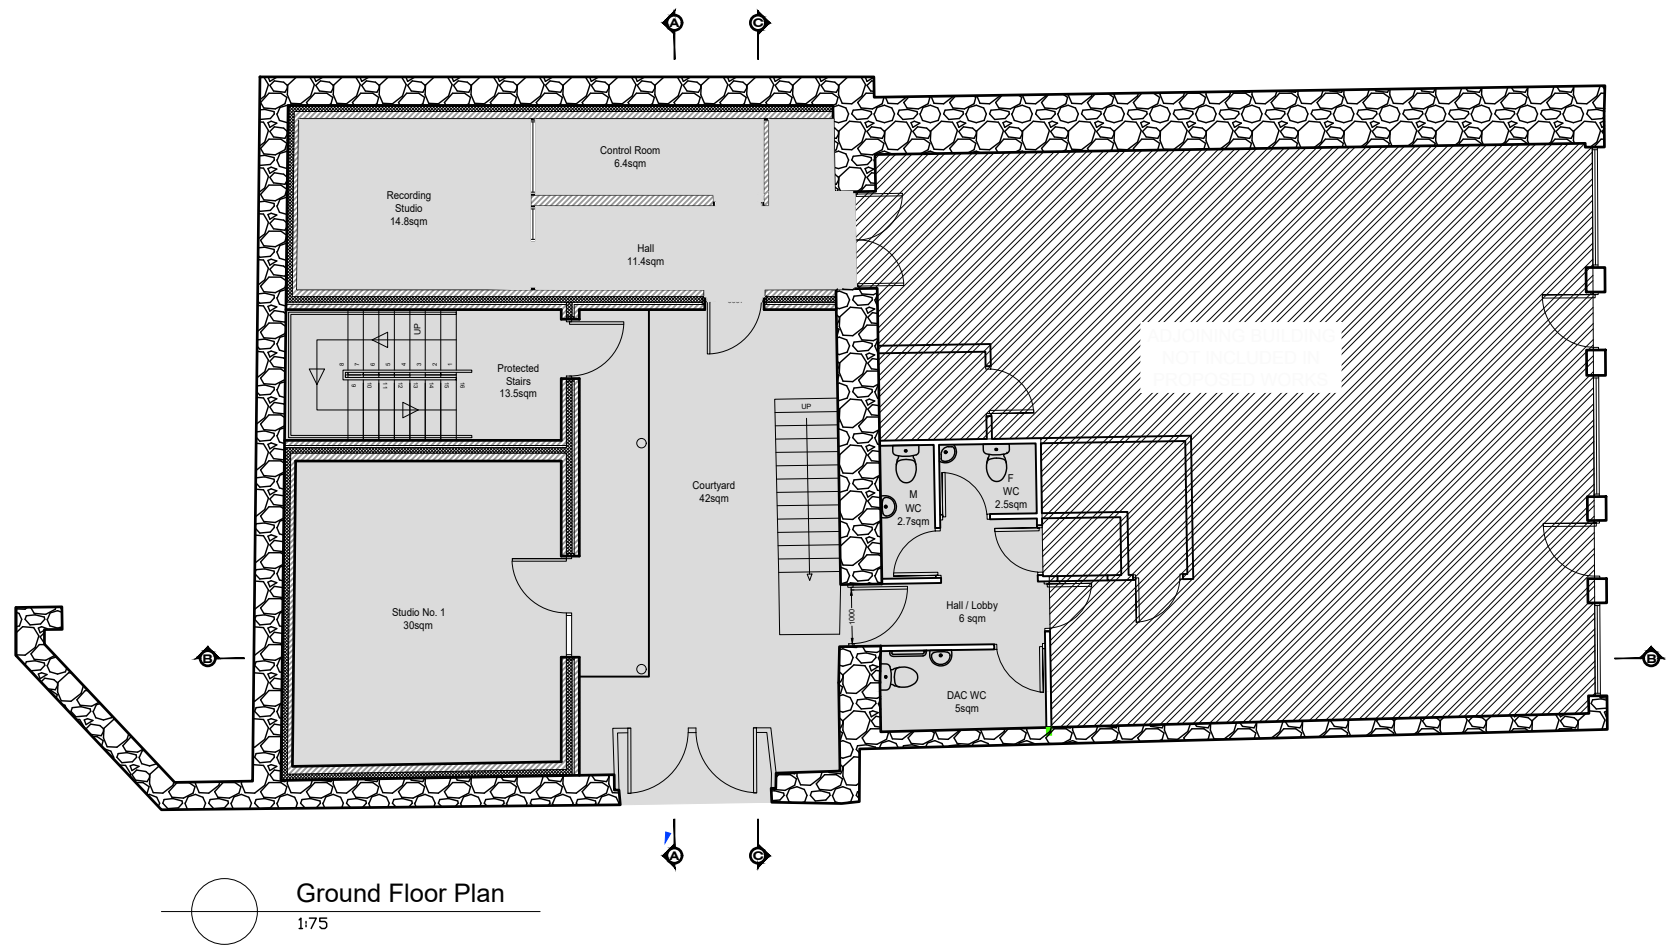

Ground Floor Plan
1:75

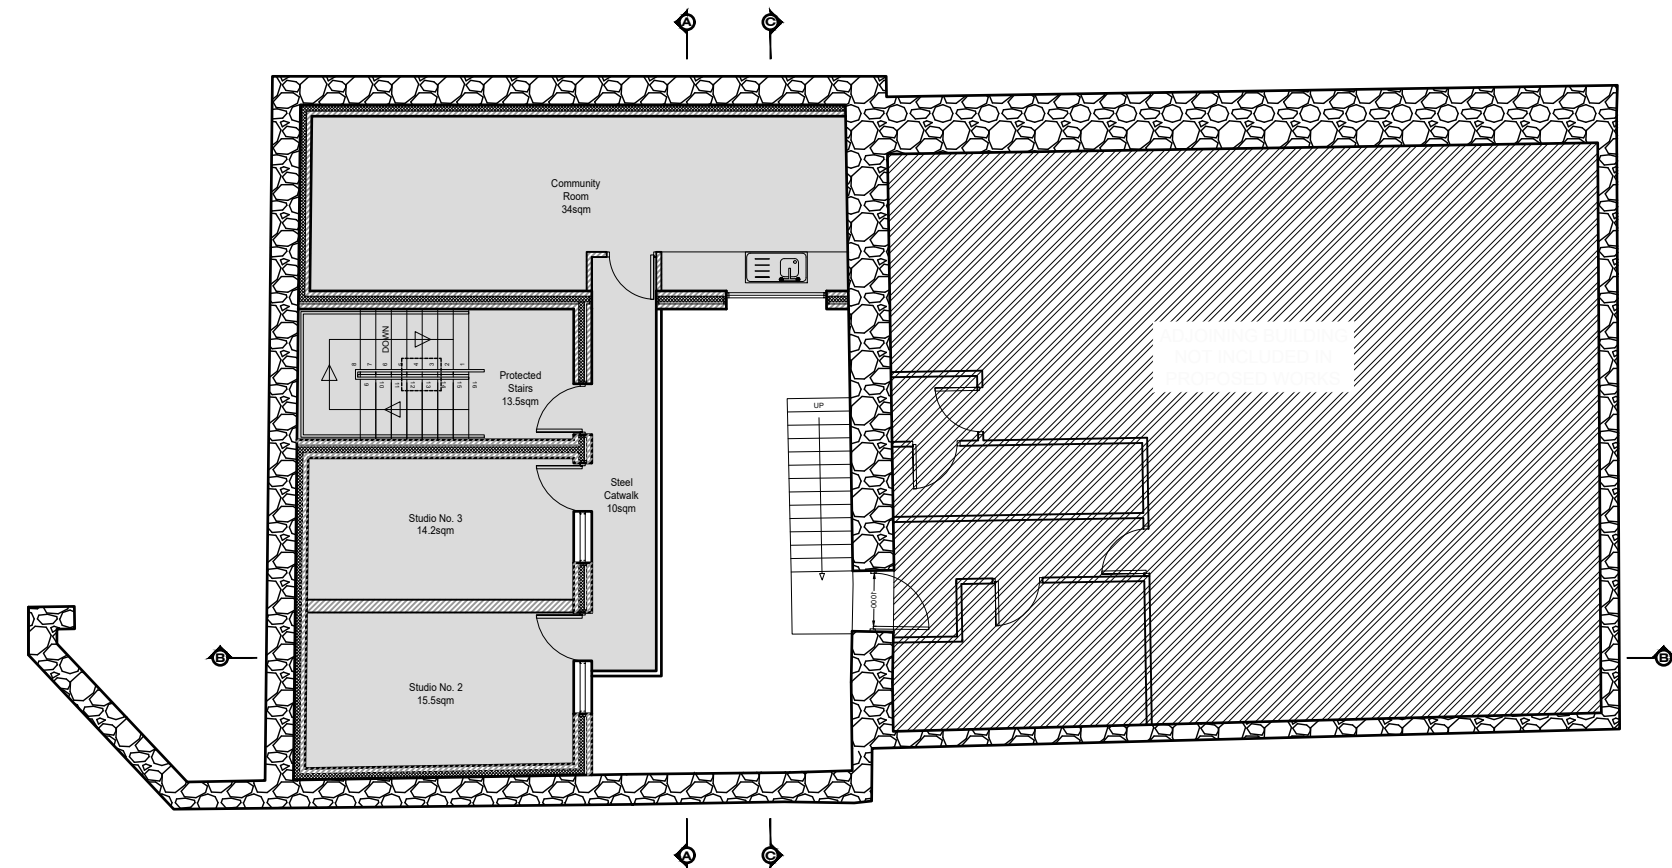

First Floor Plan
1:75

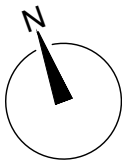

- NOTES
- GENERAL NOTES:**
- FIGURED DIMENSIONS ONLY TO BE TAKEN FROM THIS DRAWING.
 - ALL DRAWINGS TO BE CHECKED BY THE CONTRACTOR ON SITE.
 - ENGINEER/EMPLOYERS REPRESENTATIVE, AS APPROPRIATE, TO BE INFORMED BY THE CONTRACTOR OF ANY DISCREPANCIES BEFORE ANY WORK COMMENCES.
 - THE CONTRACTOR SHALL UNDERTAKE A THOROUGH CHECK FOR THE ACTUAL LOCATION OF ALL SERVICES/UTILITIES, ABOVE AND BELOW GROUND, BEFORE ANY WORK COMMENCES.
 - ALL LEVELS SHOWN RELATE TO ORDNANCE SURVEY DATUM AT MALIN HEAD.

Door Fastenings:
All doors to be fitted with simple fastenings to release door if locked.
Door release strategy as per fire safety report

Fire Detection and Alarm System:
Proposed Grade D L2/L3 fire detection and alarm system designed and installed in accordance with the recommendations set out in I.S. 3218

Electrical Installations:
To be carried out in accordance with the National Rules of The Electrical Installations Part 1 and 2 issued by The Electrical Technical Council

Fire Protection Equipment:
~~Portable fire extinguishers to be provided in accordance with the Fire services act 1981 & 2003 and the requirements of EN3-1.S.291(2015).~~

DAC LEGEND

- 450mm TURNING CIRCLE
- 1500mm TURNING CIRCLE
- 1800mm TURNING CIRCLE
- 1400mm x 900mm REFUGE AREA
- 1 SQM AOV
- 1:38 SLOPE
- 850 WIDTHS SHOWN ARE CLEAR WIDTHS

NOTE: THIS DRAWING IS TO BE USED FOR
DISABILITY ACCESS COMPLIANCE PURPOSES
ONLY. THIS IS NOT A CONSTRUCTION
DRAWING.

DAC.01	BCMS Issue	DD	MF	01.09.26
rev.	modifications	by	chkd	date

Layout Ref.:	
--------------	--

file	G:\Shared Drives\MFA Projects\0690 SCC - Land Of Arts Desire PEACEPLUS\03 Design\04 Fire And DAC\0690-MFA-XX-XX-DR-DAC-XX-100.dwg
------	---

MFA
CONSULTING ENGINEERS

Block B, Innovation Quarter
Ballina, Tone Street, Ballina,
Co. Mayo F26 WY4X
2nd Floor, Source Building,
Harmony Hill, Co. Sligo F91 YXV7
T: 096 560955
087-7858700
E: info@mflagroup.ie
W: www.mflagroup.ie

No part of this document may be reproduced or transmitted in any form or stored in any retrieval system of any nature without the written permission of MFA Consulting Engineers as copyright holder except as agreed for use on the project for which the document was originally issued.

Client:
Sligo County Council

Project
**The Nest, Quay Street,
Co. Sligo F91 K79P**

Stage:
Disability Access Compliance

Title:
Floor Plans

Drawn: DD	Checked: M.F	Scale: A.S @ A1	Date 20.04.'26
--------------	-----------------	--------------------	-------------------

Drawing No. 0690-MFA-XX-XX-DR-DAC-101	Revision DAC.01
--	---------------------------