


- GENERAL NOTES
1.

THIS DRAWING SHALL BE READ IN CONJUNCTION WITH THE SPECIFICATION AND ALL OTHER RELEVANT DRAWINGS.
2.

THIS DRAWING MUST NOT BE SCALED FOR INSTALLATION PURPOSES. WORK TO FIGURED AND SITE OBTAINED DIMENSION ONLY.
3.

THE ELECTRICAL SERVICES CONTRACTOR IS FULLY RESPONSIBLE FOR ALL ON-SITE CO-ORDINATION OF HIS AND ALL OTHER SERVICES.
4.

PIR'S FOR FANS SUPPLIED BY ELECTRICAL CONTRACTOR

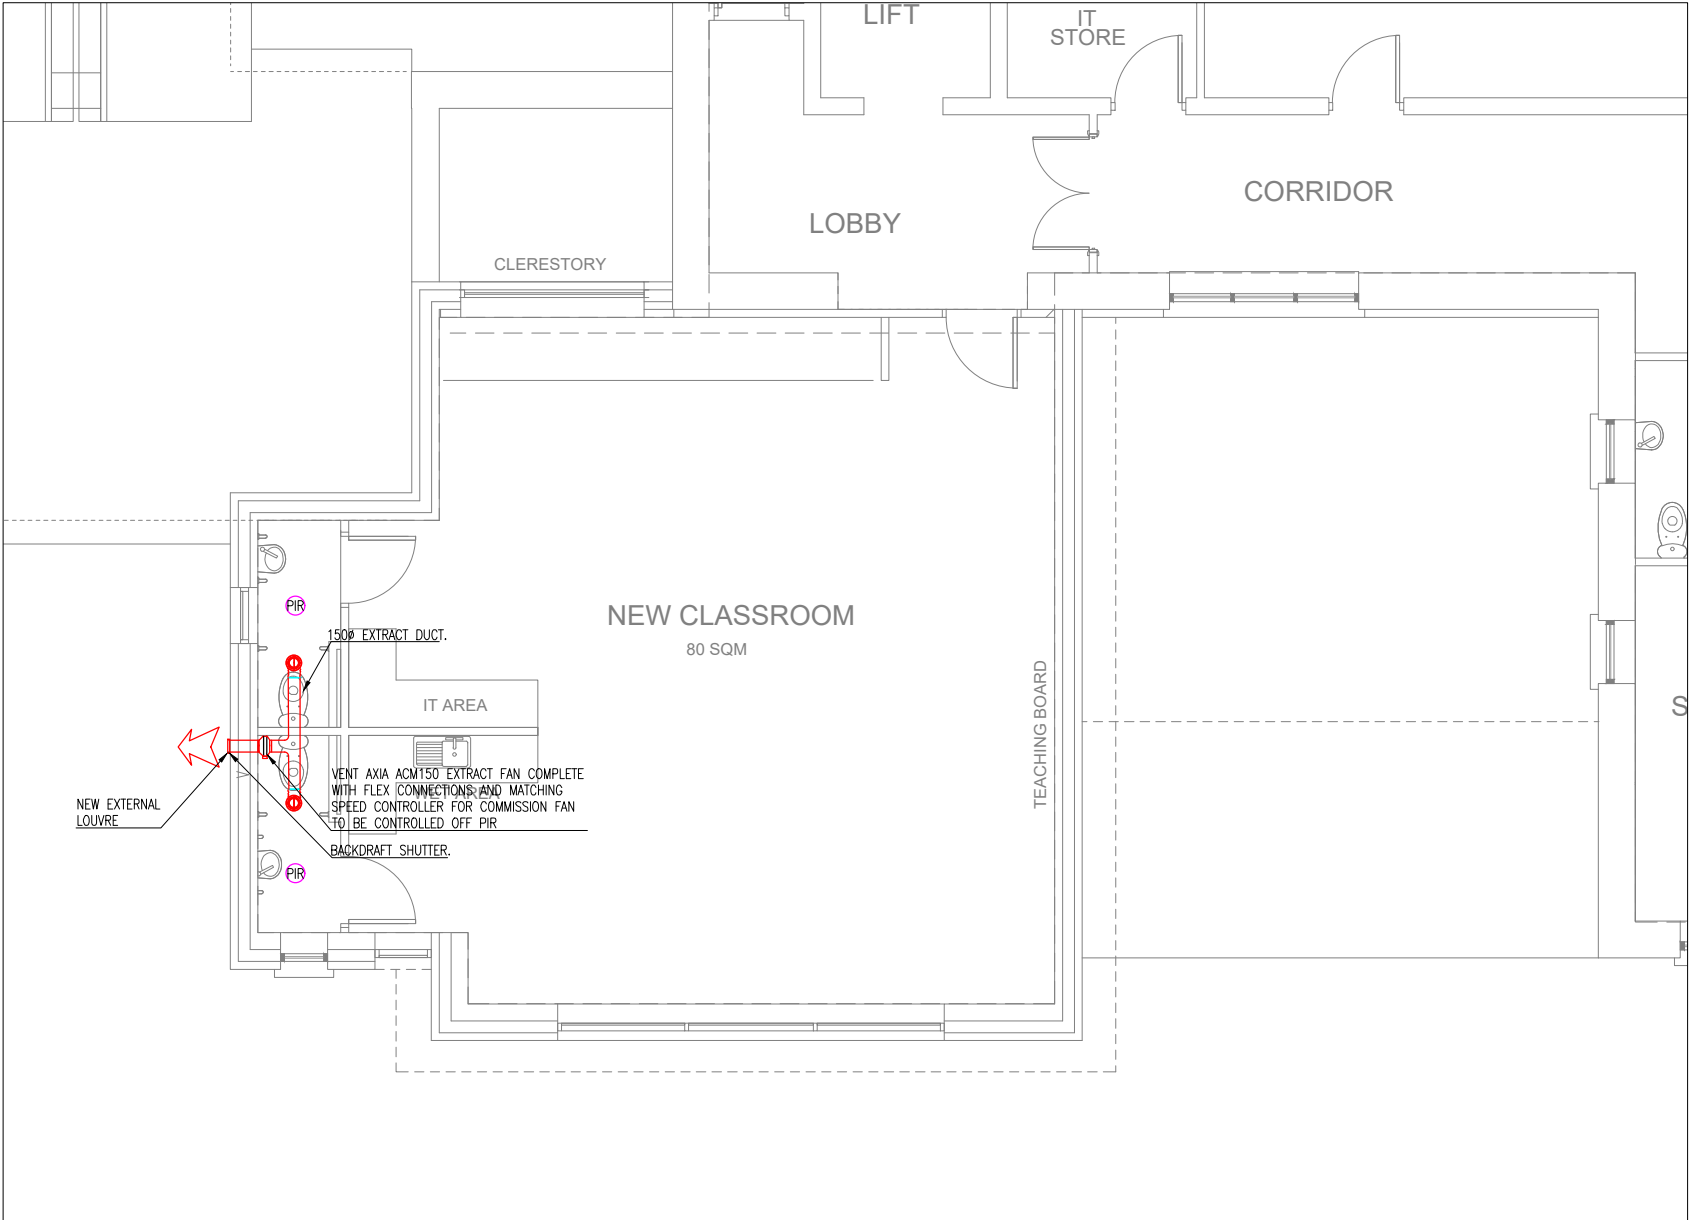

M201 VENTILATION LAYOUT – FIRST FLOOR
01 SCALE 1:50 @ A1 1:100 @ A3

REF	FLOW (L/s)	MODEL	NOTES
EF	15	QUIET EXTRACT FAN	1,2 & 3
1. LINKED TO LIGHT SWITCH			
2. WITH RUN-ON TIMER			
3. MAX SPECIFIC FAN POWER = 0.3 W/l/s			

M201 FAN SCHEDULE
02

TO ISSUE FOR TENDER

18.08.26

CR

Revisions

Date

Checked


COLMAN REYNOLDS ASSOCIATES
Building Services Engineers and Project Managers
Unit 9 Southern Cross Business Park, Bognall Rd, Bray, Co Wicklow.
[t] +353-1-2768700 [f] +353-1-6865522
[e] info@cra.ie

Project

COLLOONEY NS, SLIGO

Drawing Title

VENTILATION LAYOUT
FIRST FLOOR

Date

07.07.26

Drawn

PH

Checked

CR

Scale

1:50 @ A1
1:100 @ A3

Project No.

A1172

Drawing No.

M201

Rev.

T0

