
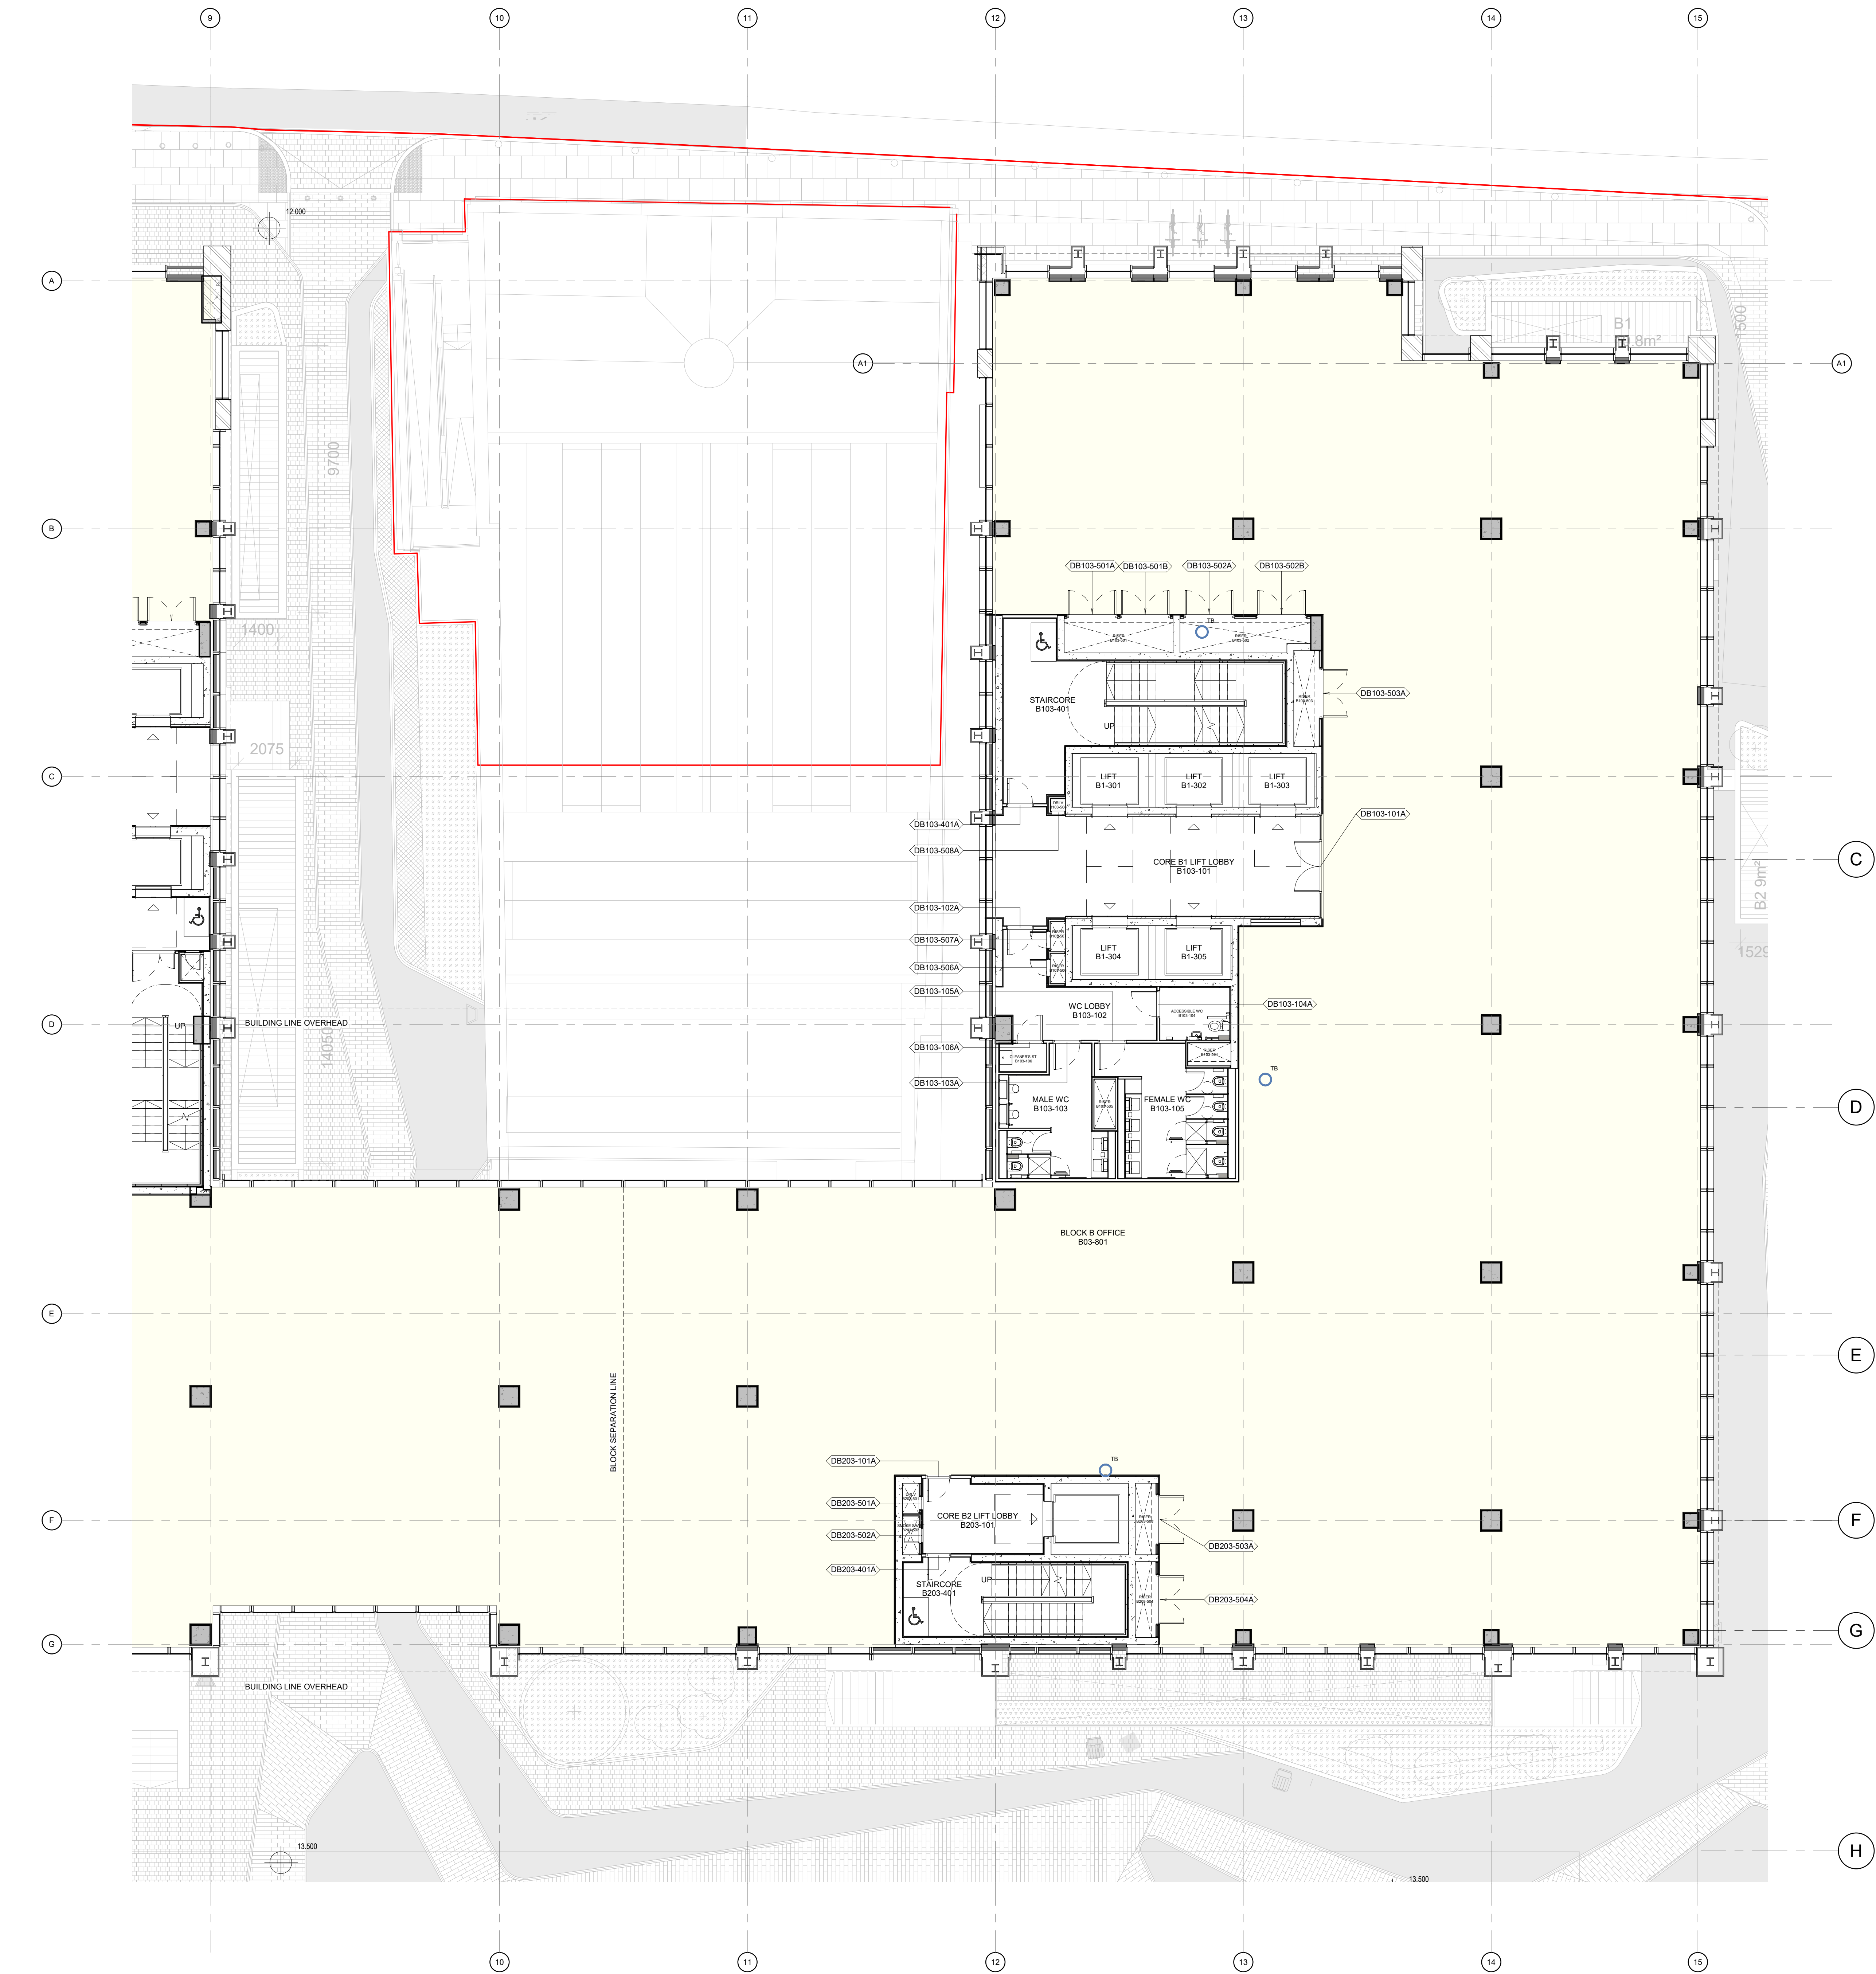


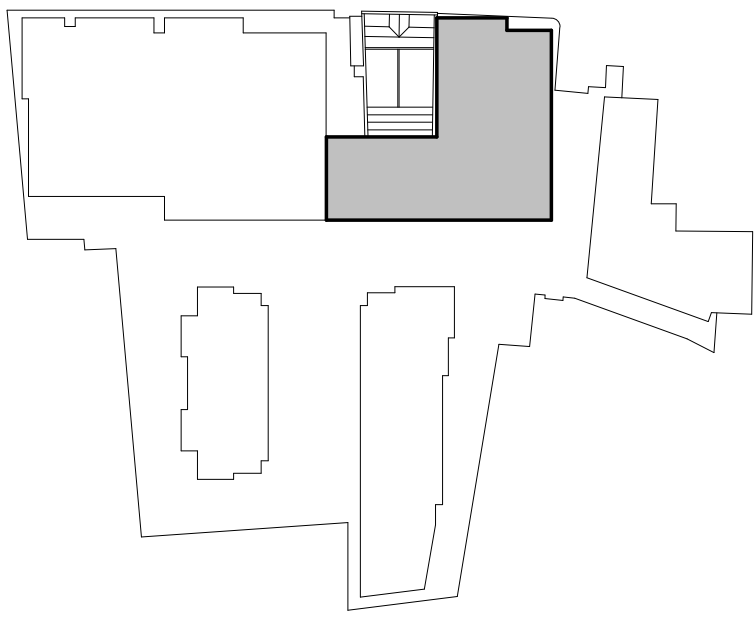

1 **BLOCK B - THIRD FLOOR PLAN**
1 : 100

COMMERCIAL BLOCK A, B & C RAINWATER DRAINAGE

- SIPHONIC RAINWATER OUTLET
- SIPHONIC DOWNPIPE
- INDICATIVE ROOF FALLS
- GRAVITY RAINWATER OUTLET
- GRAVITY DOWNPIPE
- SLOT DRAIN
- ATTENUATION TANK
- SIPHONIC RAINWATER ROUTE
- GRAVITY RAINWATER ROUTE

REV	DATE	DESCRIPTION	CHK	DRN
T03	17.08.2021	ISSUED FOR INFORMATION	XX	DK / PT
T02	06.08.2021	ISSUED FOR INFORMATION	XX	DK / PT
T01	03.04.2021	ISSUED FOR INFORMATION	XX	DK / PT
T00	26.03.2021	ISSUED FOR INFORMATION	XX	DK / PT

STATUS CODE DESCRIPTION

SUITABLE FOR COORDINATION

CLIENT
GA DEVELOPMENT DUBLIN ICAV

PROJECT
KEVIN STREET REDEVELOPMENT PROJECT

DRAWING
GA_BLOCK_B_THIRD_FLOOR_PLAN

PROJECT NUMBER		DATE
950612		17.08.2021
SCALE@ A0:		DRAWING CHECKED:
As indicated		Author/ Checker
STATUS CODE:	DRAWING NUMBER	REVISION
S1	KSC-HJL-B-03-DR-A-T1013_B	T03

Henry J Lyons

Architecture + Interiors
henryjlyons.com
+353 1 888 3333
info@henryjlyons.com
51-54 Parnassus Street
Dublin D02 XA66