


AREA - B - RECEPTION



GROUND FLOOR PLAN - B

Scale 1:75

SYMBOLS KEY	
	600mm x 600mm TEGRAL LOW GALRE LED
	RUNNING MAN
	1200MM X 50MM TEGRAL BATTON
	Ø150MM LED/12.9W LED DOWN LIGHT (L6 145MV - TEGRAL)
	TEGRAL EDL1NM DLEP5W
	SMOKE DETECTOR
	FIRE ALARM SOUNDER

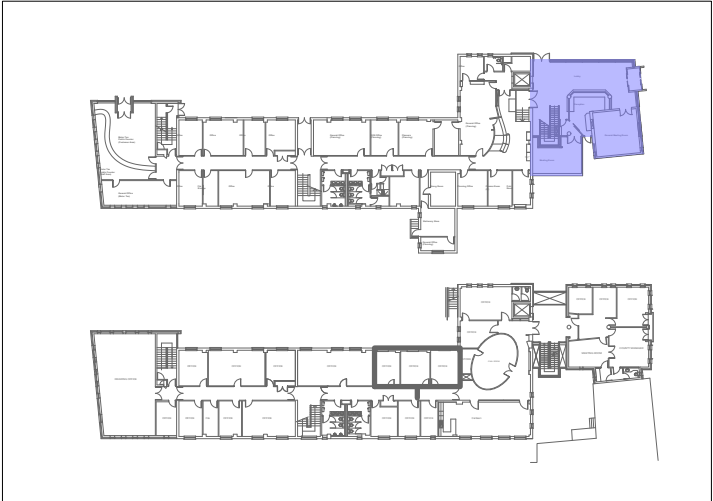

Key Plan

1	Updated to latest design	GT	05/09/26
Issue	Revision / Serial No.	Sig.	Date
	G-MECH SERVICES LTD		Grogan Lodge Hilltown Tacumshane Co. Wexford Y35 KO94
Consulting Mechanical + Electrical Engineers Tel: 00 353 (0)87 2295767 Email: info@gmechservices.com Web: www.gmechservices.com			
Client CARLOW COUNTY COUNCIL			
Location COUNTY BUILDINGS, ATHY ROAD, CO.CARLOW		Scale	1:750A3
Project BUILDING REFURBISHMENT WORKS		Date	05/09/26
		Drawn	GT
A3	Title: AREA B – RECEPTION LIGHTING, EMERGENCY LIGHTING, & FIRE ALARM		
DRG No.	CCC02 - ME04		001
THIS IS A CAD DRAWING DO NOT ALTER			