
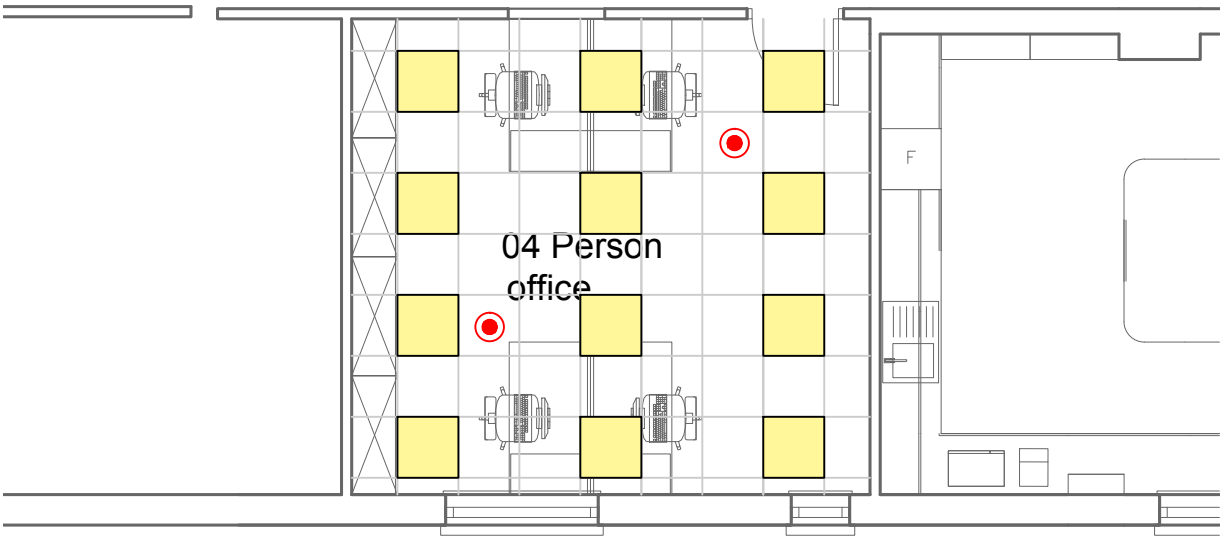
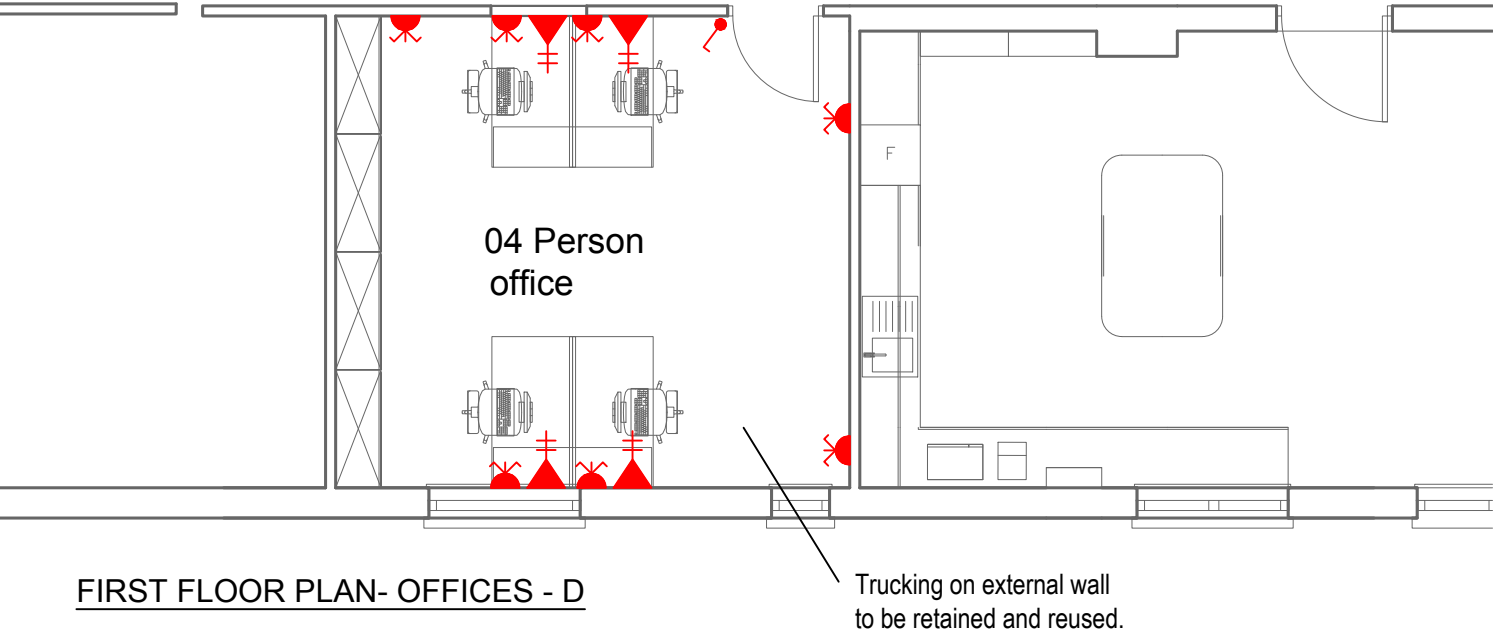
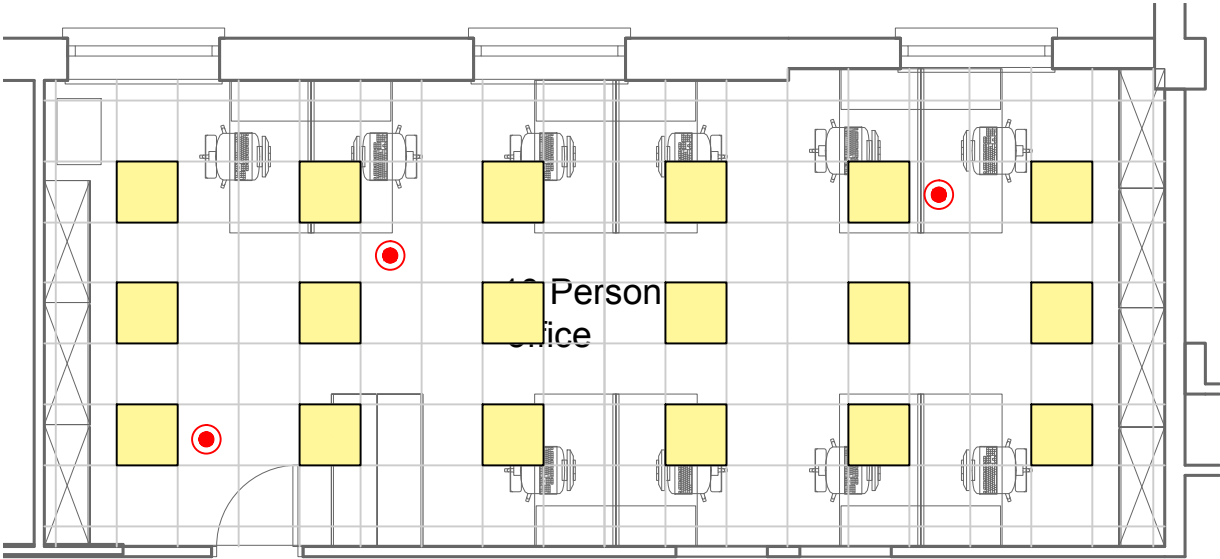


AREA - D - OFFICE ROOMS

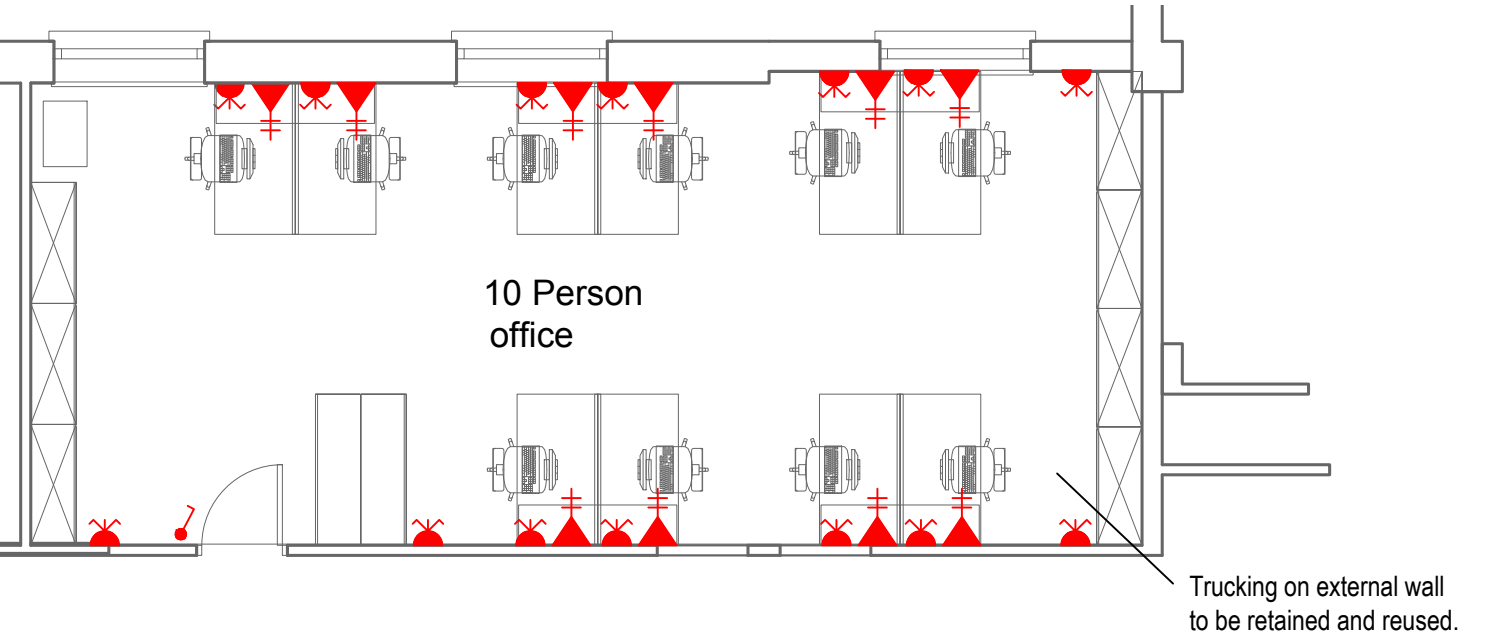


FIRST FLOOR PLAN- OFFICES - D

FIRST FLOOR PLAN- OFFICES - REFLECTIVE CEILING D

| SYMBOLS KEY |                              |
|-------------|------------------------------|
|             | SINGLE POLE LIGHT SWITCH     |
|             | TWIN SOCKET AT LOW LEVEL     |
|             | TWIN DATA POINT AT LOW LEVEL |

| LIGHTING KEY |                                    |
|--------------|------------------------------------|
|              | 600mm x 600mm TEGRAL LOW GALRE LED |
|              | TEGRAL EDL1NM DLEP5W               |

Scale 1:75

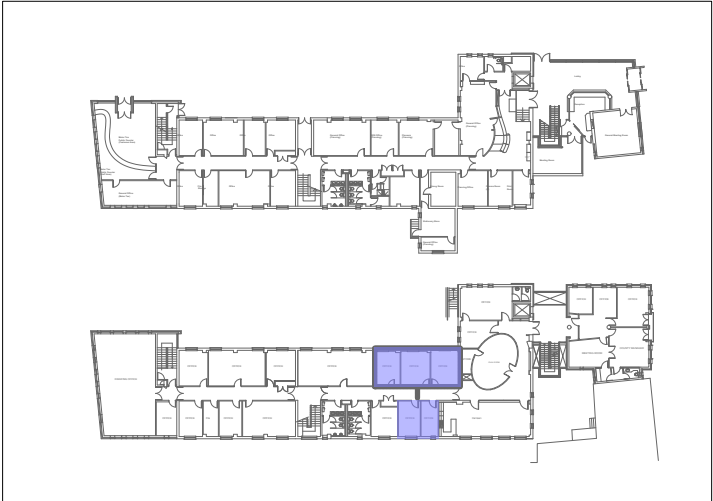

Key Plan

| 3                                                                                     |                                                                                                                                                                                                                                 |                         |          |
|---------------------------------------------------------------------------------------|---------------------------------------------------------------------------------------------------------------------------------------------------------------------------------------------------------------------------------|-------------------------|----------|
| 2                                                                                     |                                                                                                                                                                                                                                 |                         |          |
| 1                                                                                     | Updated to latest design                                                                                                                                                                                                        | GT                      | 09/02/26 |
| Issue                                                                                 | Revision / Serial No.                                                                                                                                                                                                           | Sig.                    | Date     |
|  | <div>Grogan Lodge<br/>Hilltown<br/>Tacumshane<br/>Co. Wexford<br/>Y35 KO94</div> <div>Consulting Mechanical + Electrical Engineers<br/>Tel: 00 353 (0)87 2295767 Email: info@gmechservices.com Web: www.gmechservices.com</div> |                         |          |
| <b>Client</b><br><b>CARLOW COUNTY COUNCIL</b>                                         |                                                                                                                                                                                                                                 |                         |          |
| <b>Location</b><br>COUNTY BUILDINGS, ATHY ROAD, CO.CARLOW                             |                                                                                                                                                                                                                                 | <b>Scale</b><br>1:75@A3 |          |
| <b>Project</b><br>BUILDING REFURBISHMENT WORKS                                        |                                                                                                                                                                                                                                 | <b>Date</b><br>05/09/26 |          |
|                                                                                       |                                                                                                                                                                                                                                 | <b>Drawn</b><br>GT      |          |
| A3                                                                                    | <b>Title:</b><br>AREA D - OFFICE ROOMS<br>SMALL POWER<br>LIGHTING & EMERGENCY LIGHTING                                                                                                                                          |                         |          |
| DRG No.                                                                               | CCC02 - ME06                                                                                                                                                                                                                    | 001                     |          |
| THIS IS A CAD DRAWING DO NOT ALTER                                                    |                                                                                                                                                                                                                                 |                         |          |