


AREA - E - CANTEEN

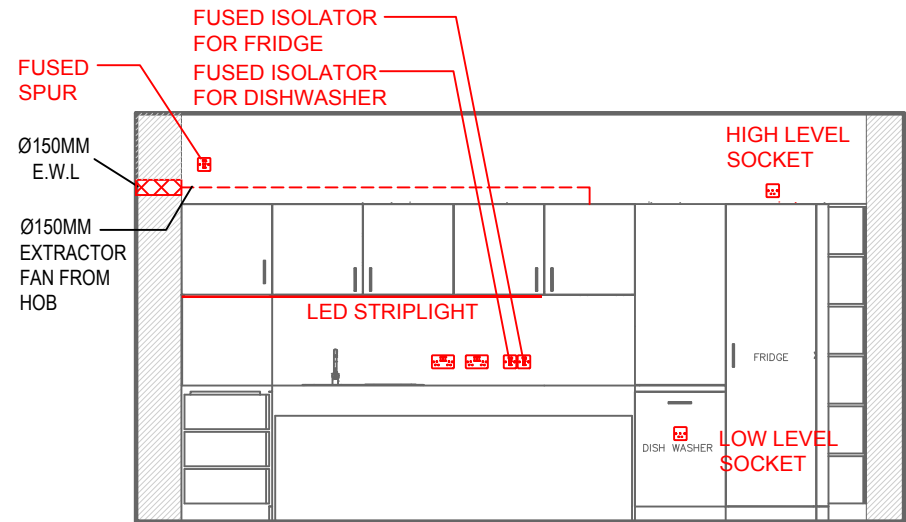


WALL ELEVATION - 01



WALL ELEVATION - 02


Scale 1:50

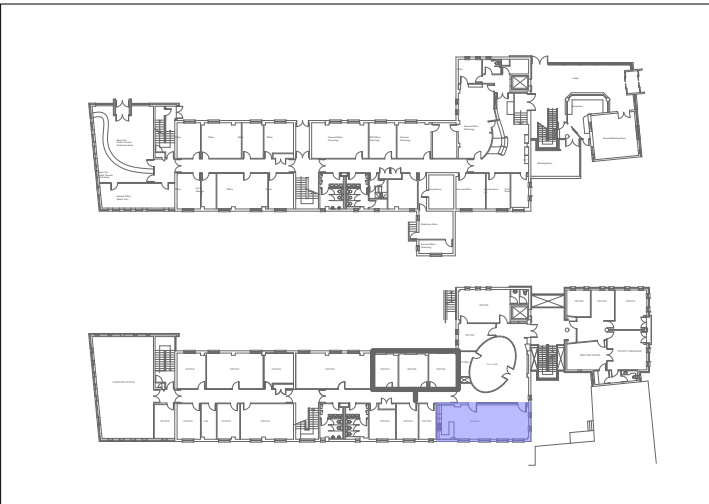

Key Plan


SYMBOLS KEY	
	TWO WAY POLE LIGHT SWITCH
	TWIN SOCKET AT COUNTER LEVEL
	TWIN SOCKET AT LOW LEVEL
	SINGLE SOCKET AT HIGH LEVEL
	SINGLE SOCKET AT LOW LEVEL
	FUSED SPUR AT COUNTER LEVEL
	LED STRIP LIGHT UNDER WALL MOUNTED CABINETS

SYMBOLS KEY	
	200mm Ø LED 15W DOWNLIGHT
	RUNNING MAN
	TEGRAL EDL1NM DLEP5W
	SMOKE DETECTOR
	FIRE ALARM SOUNDER
	HEAT DETECTOR

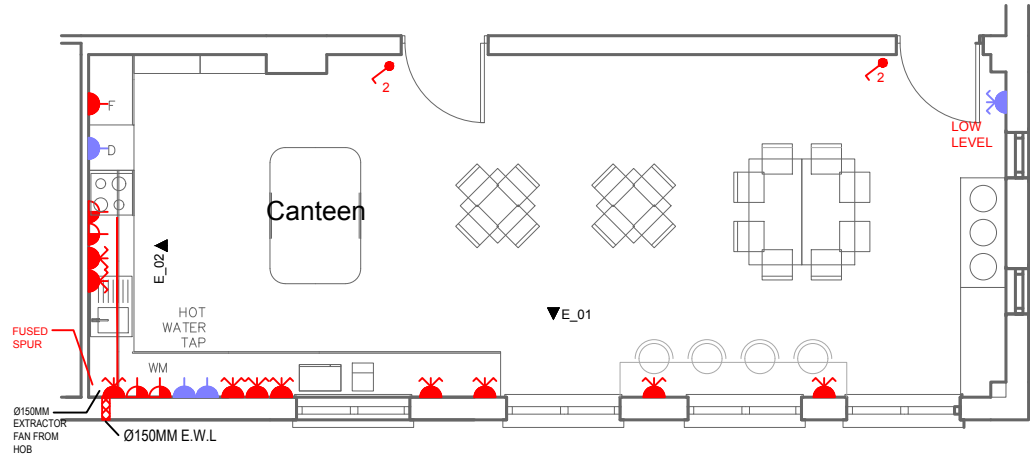

FIRST FLOOR PLAN- CANTEEN - E

Scale 1:100

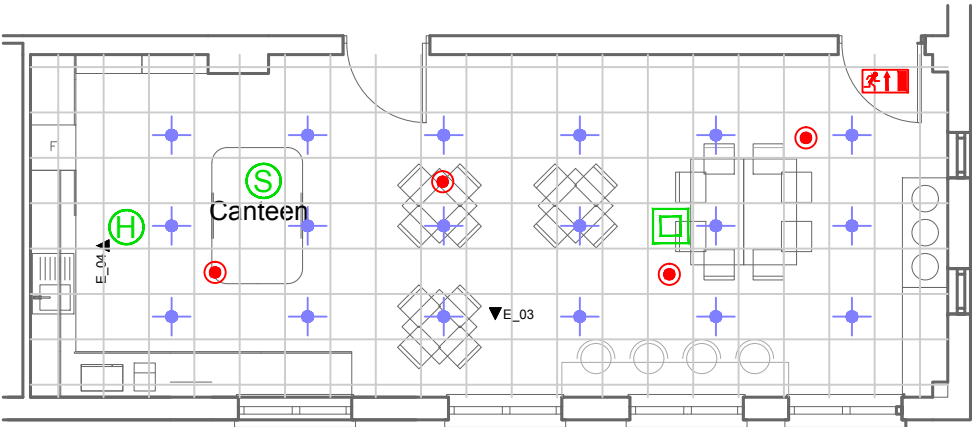

FIRST FLOOR PLAN- CANTEEN - REFLECTIVE CEILING - E

3			
2			
1	Updated to latest design	GT	05/09/26
Issue	Revision / Serial No.	Sig.	Date
	G-MECH SERVICES LTD		Grogan Lodge Hilltown Tacumshane Co. Wexford Y35 KQ94
Consulting Mechanical + Electrical Engineers Tel: 00 353 (0)87 2295767 Email: info@gmechservices.com Web: www.gmechservices.com			
Client CARLOW COUNTY COUNCIL			
Location COUNTY BUILDINGS, ATHY ROAD, CO.CARLOW		Scale 1:100/500A3	
Project BUILDING REFURBISHMENT WORKS		Date 05/09/26	
		Drawn GT	
A3	Title: AREA E – CANTEEN LIGHTING & EMERGENCY LIGHTING SMALL POWER & FIRE ALARM		
DRG No.	CCC02 - ME07		000
THIS IS A CAD DRAWING DO NOT ALTER			